

PERSONAL RESIDENCE

94 CUMBERLAND,
MEMPHIS, TN

SUPPLEMENTAL INTERIOR DESIGN DOCUMENTS - NOT FOR CONSTRUCTION

8/14/2023

DESIGNER CONTACTS:
CAROLINE HARRIS
CAROLINEH@MURPHYMAUDEINTERIORS.COM

ALISSA TANG
ALISSA@MURPHYMAUDEINTERIORS.COM

REFER TO CABINET SHOP DRAWINGS, FOR EXACT DIMENSIONS,
SPECIFICATIONS, ETC.
REFER TO TRIM CARPENTER FOR ALL CLOSETS, PANTRY, UTILITY ROOMS, &
FRIENDS ENTRY



SHEET LIST	
NUMBER	NAME
ID102	FURNITURE PLANS
ID201	FIRST FLOOR CEILING PLAN
ID202	SECOND FLOOR CEILING PLAN
ID301	FIRST FLOOR FINISH PLAN
ID302	SECOND FLOOR FINISH PLAN
ID602	DIAGRAMS AND DETAILS
ID204	FIRST FLOOR ELECTRICAL PLAN
ID205	SECOND FLOOR ELECTRICAL PLAN
ID001	COVER
ID402	INTERIOR ELEVATIONS
ID401	INTERIOR ELEVATIONS
ID203	CEILING FINISH PLANS
ID601	SCHEDULES
ID404	ENLARGED PLAN - KITCHEN
ID405	ENLARGED PLAN - MASTER BATH
ID407	ENLARGED PLANS - FIRST FLOOR BATHROOMS
ID101	FLOOR PLANS
ID406	ENLARGED PLANS - PANTRY, SCULLERY, OUTDOOR KITCHEN
ID408	ENLARGED PLANS - SECOND FLOOR BATHROOMS



500 Madison unit 107,
Nashville, Tennessee 37208
w: murphymaudeinteriors.com
p: (901) 848-6402
copyright 2022

FLOOR PLAN LEGEND

NAME

ROOM NAME

WALL

GENERAL NOTES:
DIMENSION STRINGS: DIMENSION FROM FACE OF FINISH TO FACE OF FINISH UNLESS NOTED OTHERWISE.
SEE ELECTRICAL SHEETS FOR FLOOR BOX LOCATIONS.

SHEET LIST	
NUMBER	NAME
ID102	FURNITURE PLANS
ID201	FIRST FLOOR CEILING PLAN
ID202	SECOND FLOOR CEILING PLAN
ID301	FIRST FLOOR FINISH PLAN
ID302	SECOND FLOOR FINISH PLAN
ID402	DIAGRAMS AND DETAILS
ID204	FIRST FLOOR ELECTRICAL PLAN
ID205	SECOND FLOOR ELECTRICAL PLAN
ID001	COVER
ID402	INTERIOR ELEVATIONS
ID401	INTERIOR ELEVATIONS
ID203	CEILING FINISH PLANS
ID401	SCHEDULES
ID404	ENLARGED PLAN - KITCHEN
ID405	ENLARGED PLAN - MASTER BATH
ID407	ENLARGED PLANS - FIRST FLOOR BATHROOMS
ID101	FLOOR PLANS
ID406	ENLARGED PLANS - PANTRY, SCULLERY, OUTDOOR KITCHEN
ID408	ENLARGED PLANS - SECOND FLOOR BATHROOMS

MURPHY MAUDE
INTERIORS

500 Madison unit 107,
Nashville, Tennessee 37208
w: murphymaudeinteriors.com
p: (901) 848-6402
copyright 2021

CLIENT
MR. AND MRS. CLIENT

PROJECT LOCATION
94 CUMBERLAND,
MEMPHIS, TN

PROJECT NAME
PERSONAL RESIDENCE



DATE ISSUED
DRAWING SCALE


8/14/2023
As indicated

DRAWING TITLE
FLOOR PLANS


REVISIONS:		
NUMBER	DATE	DESCRIPTION

SUPPLEMENTAL INTERIOR DESIGN
DOCUMENT
ID101

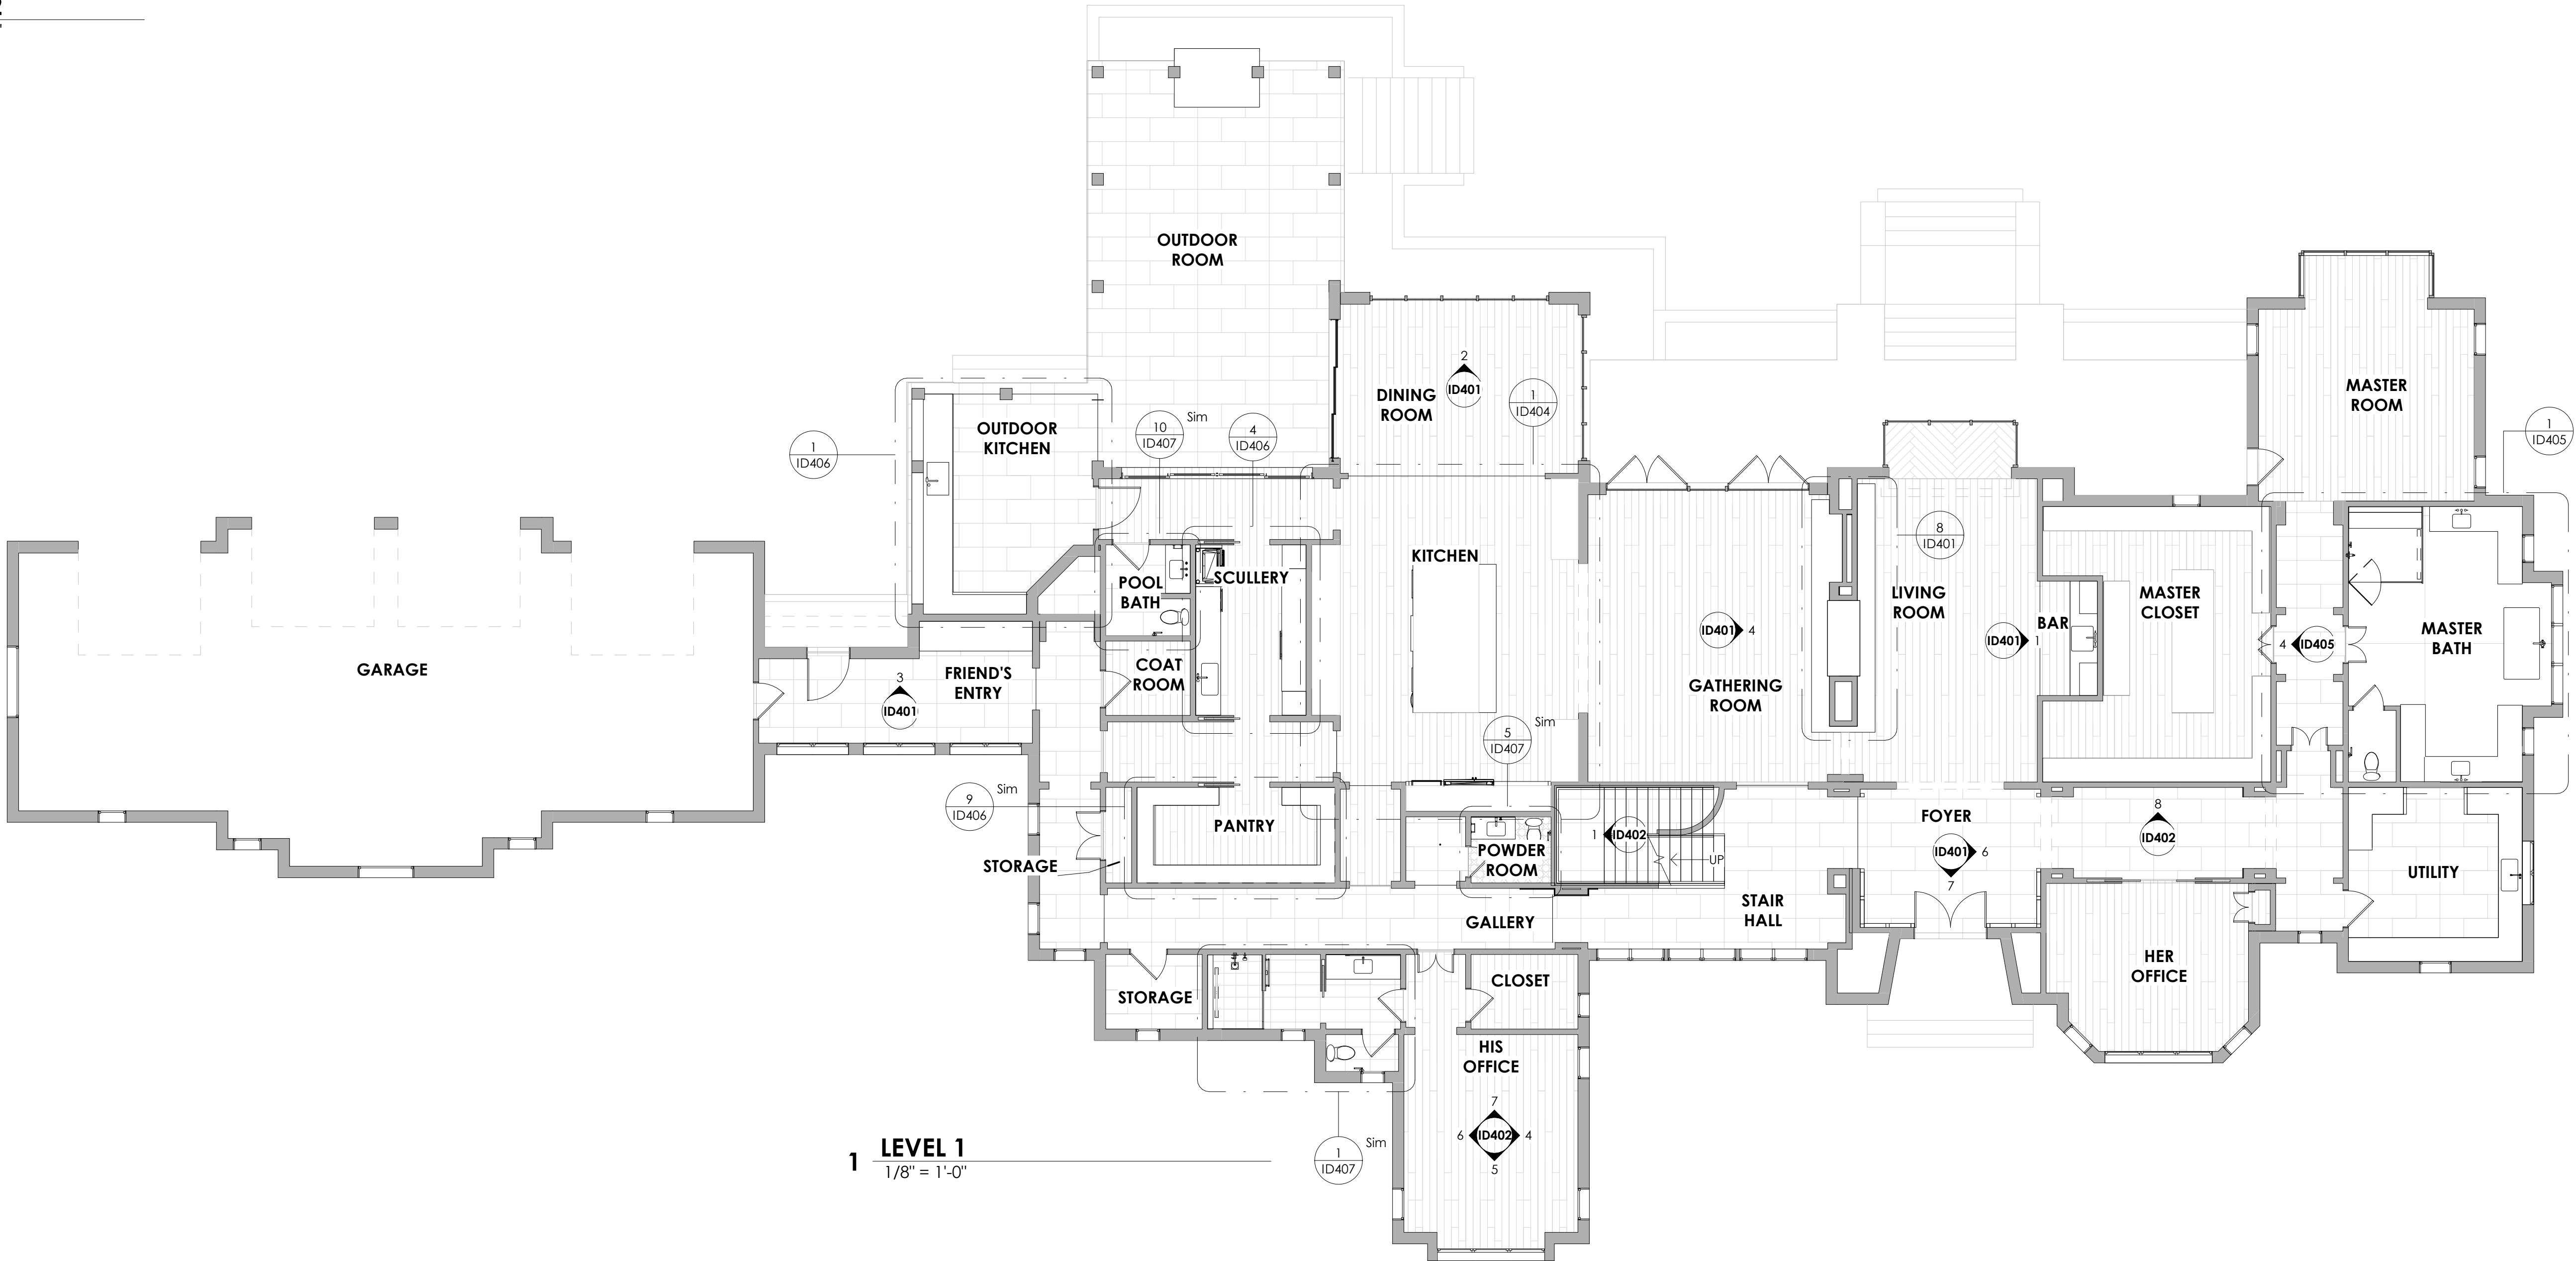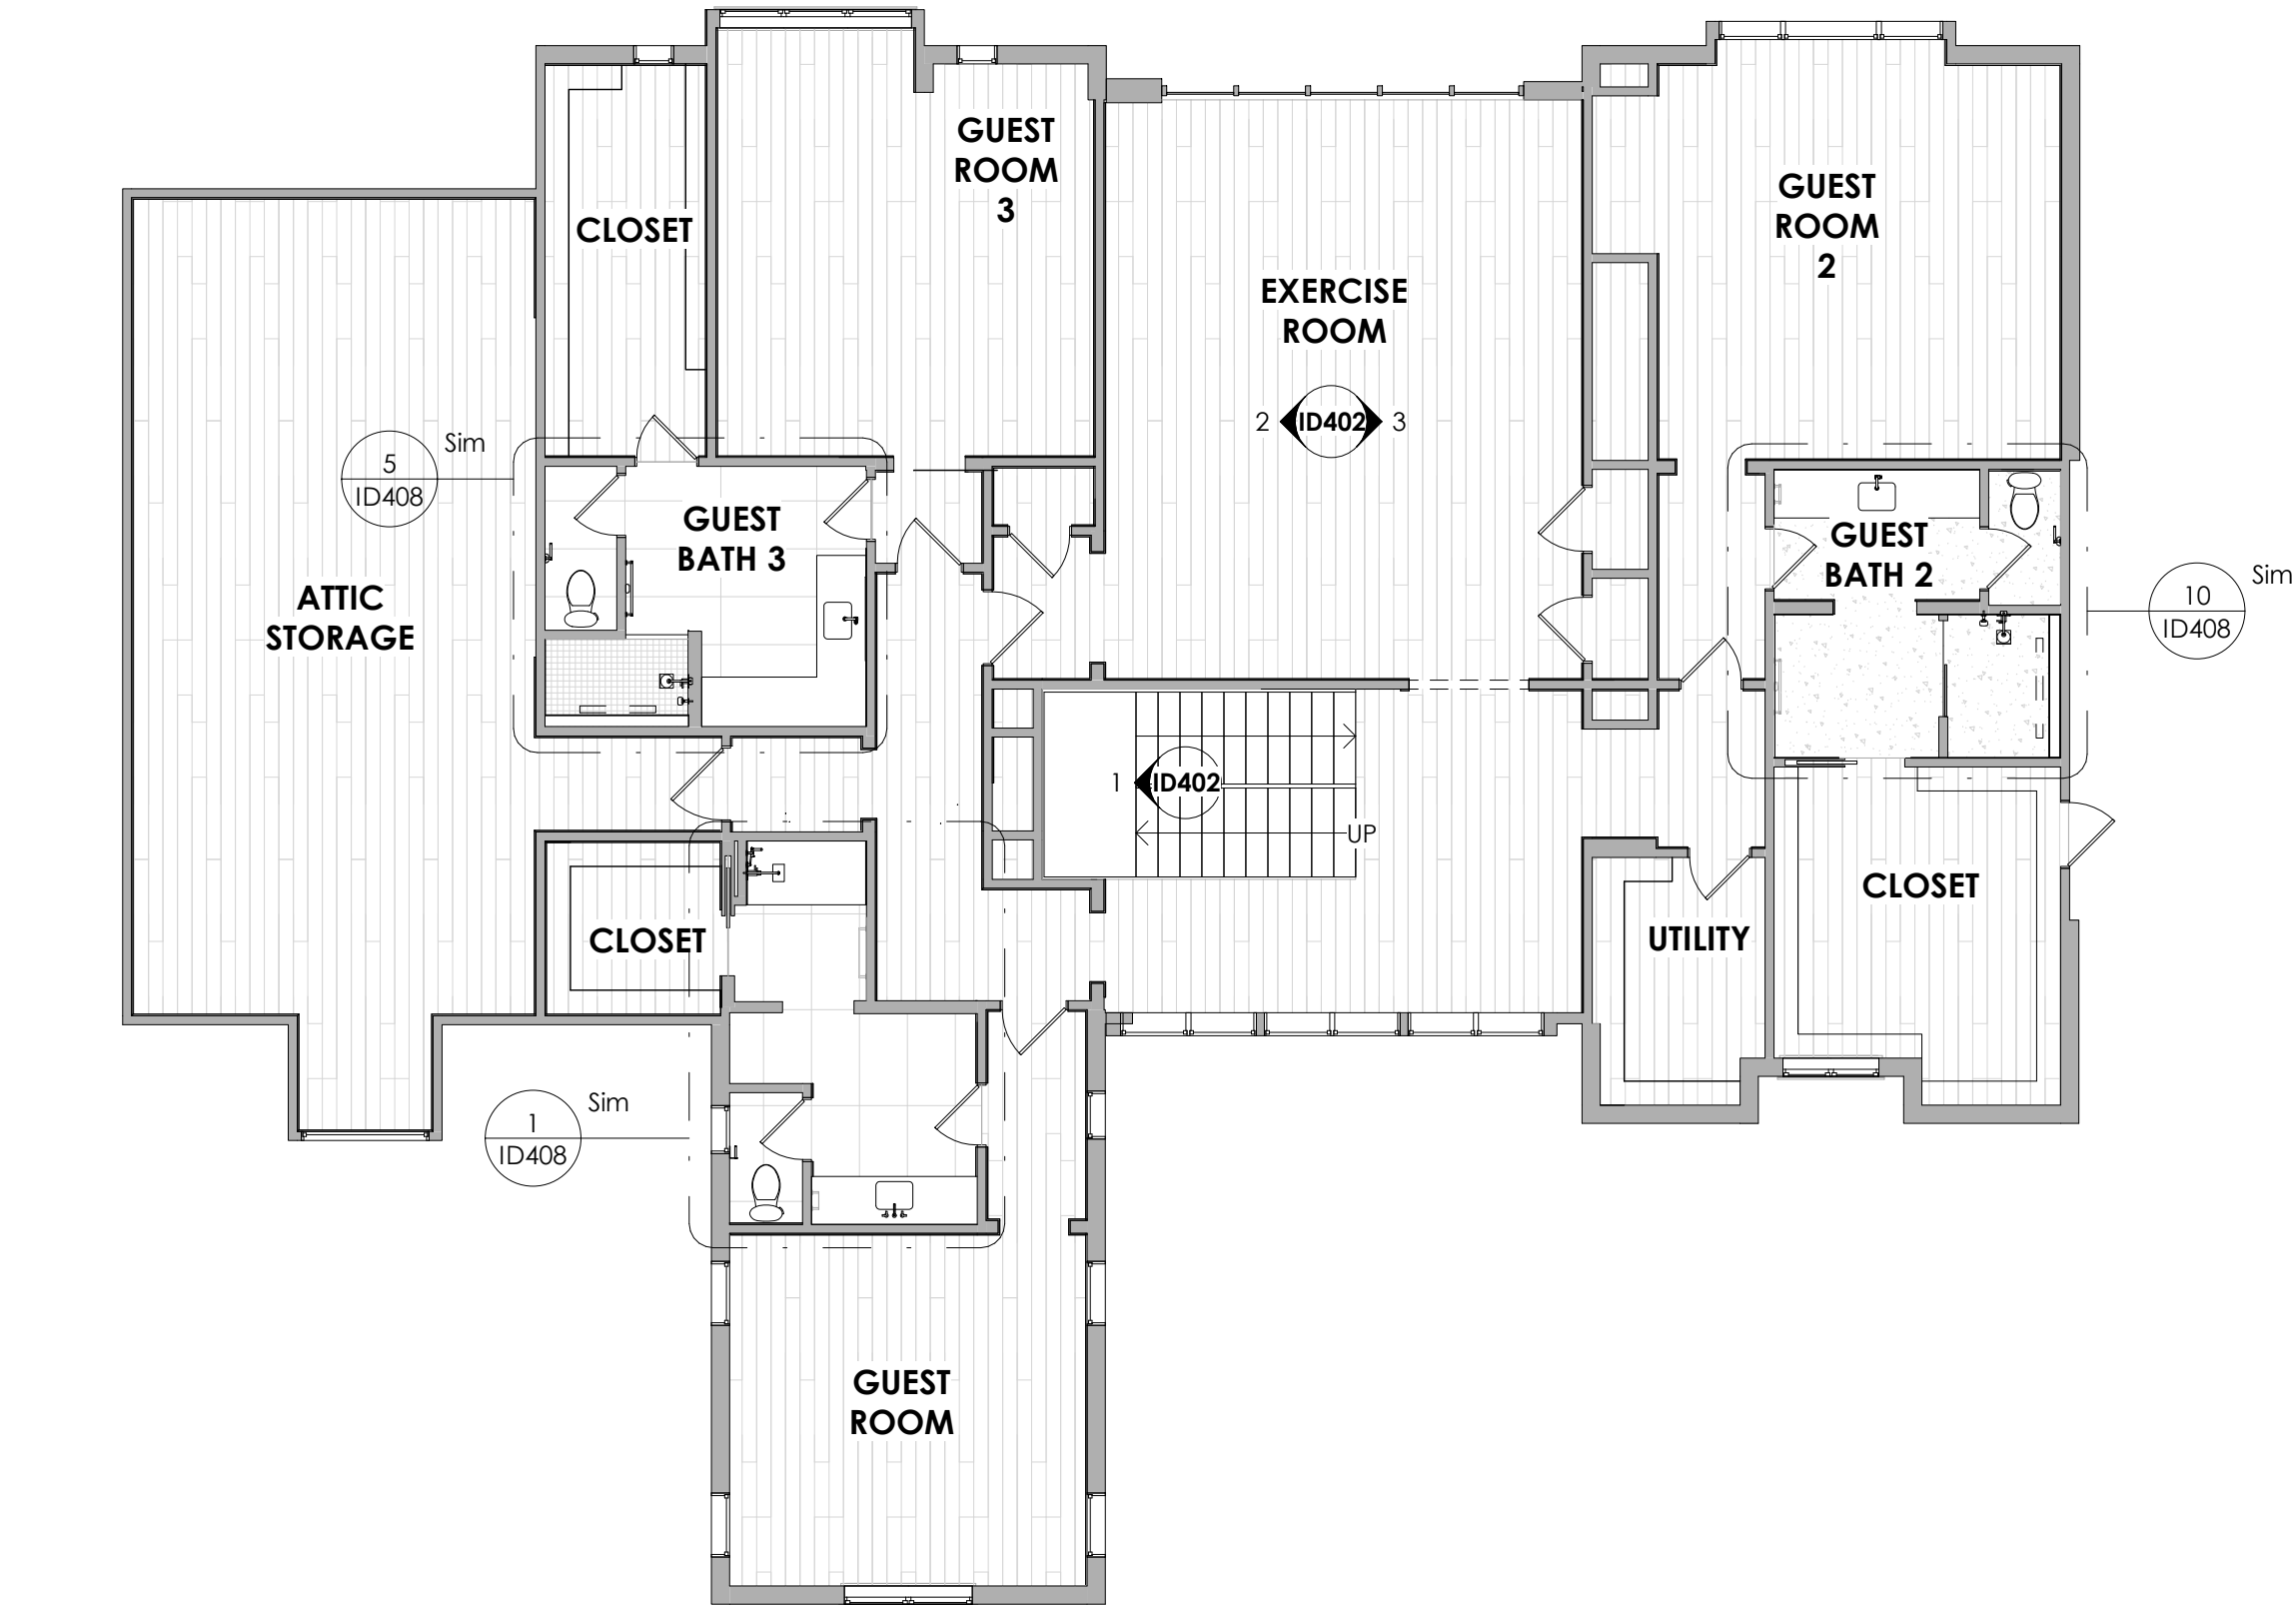

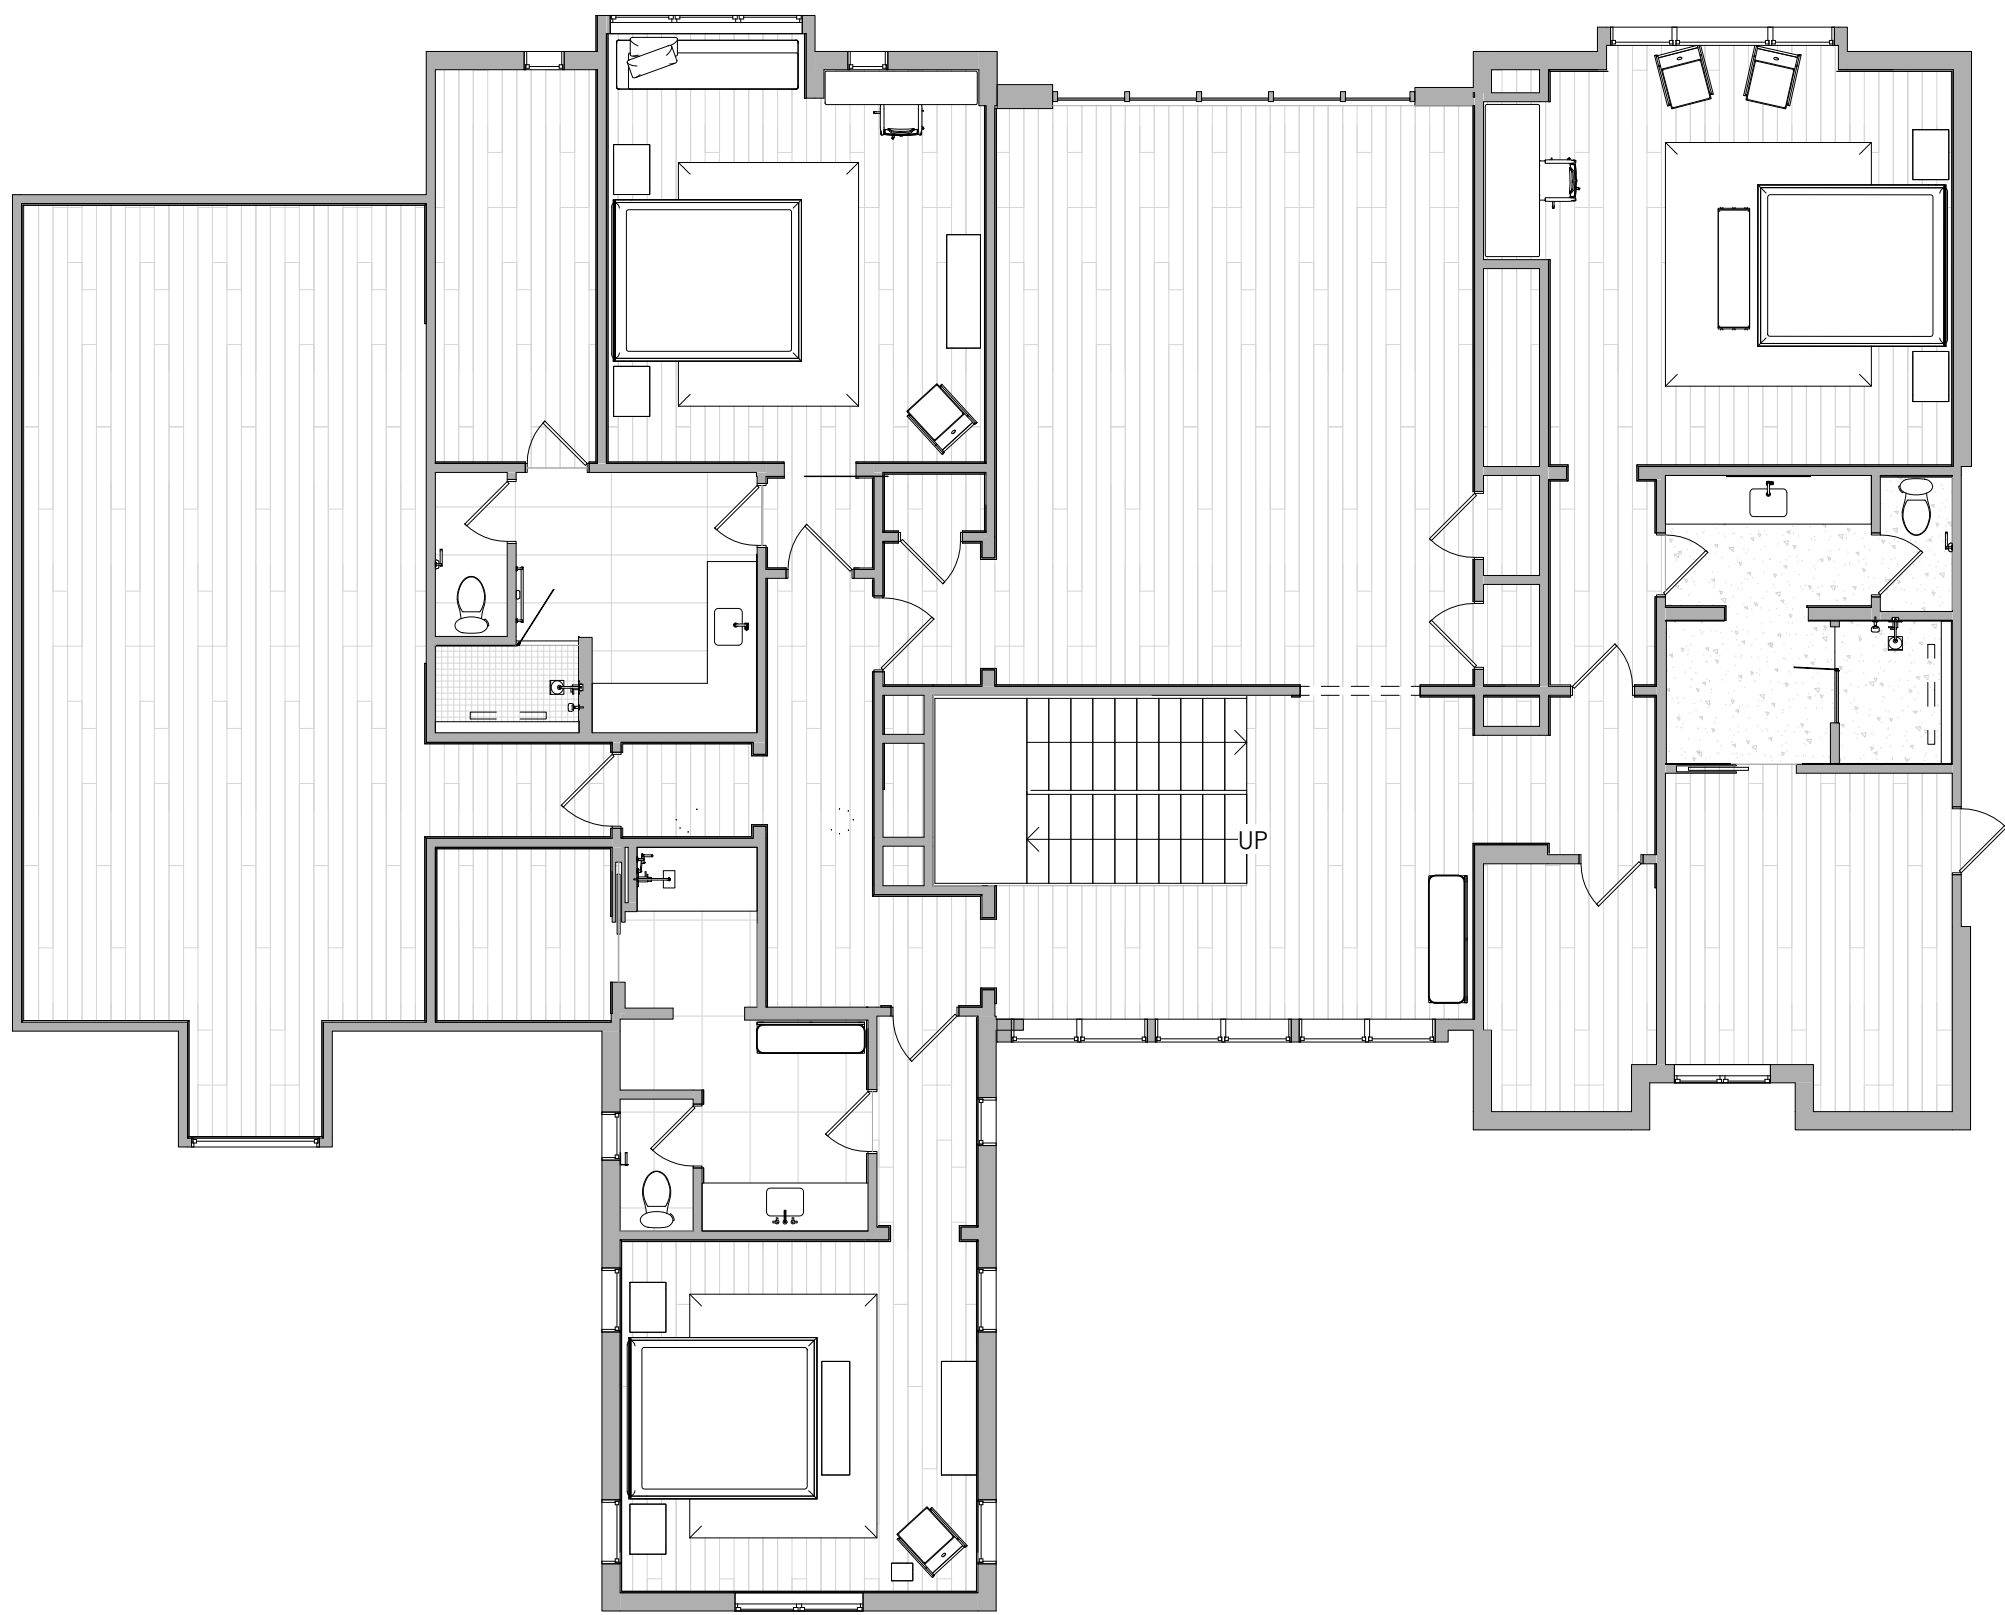


2 **LEVEL 2 FURNITURE PLAN**
1/8" = 1'-0"

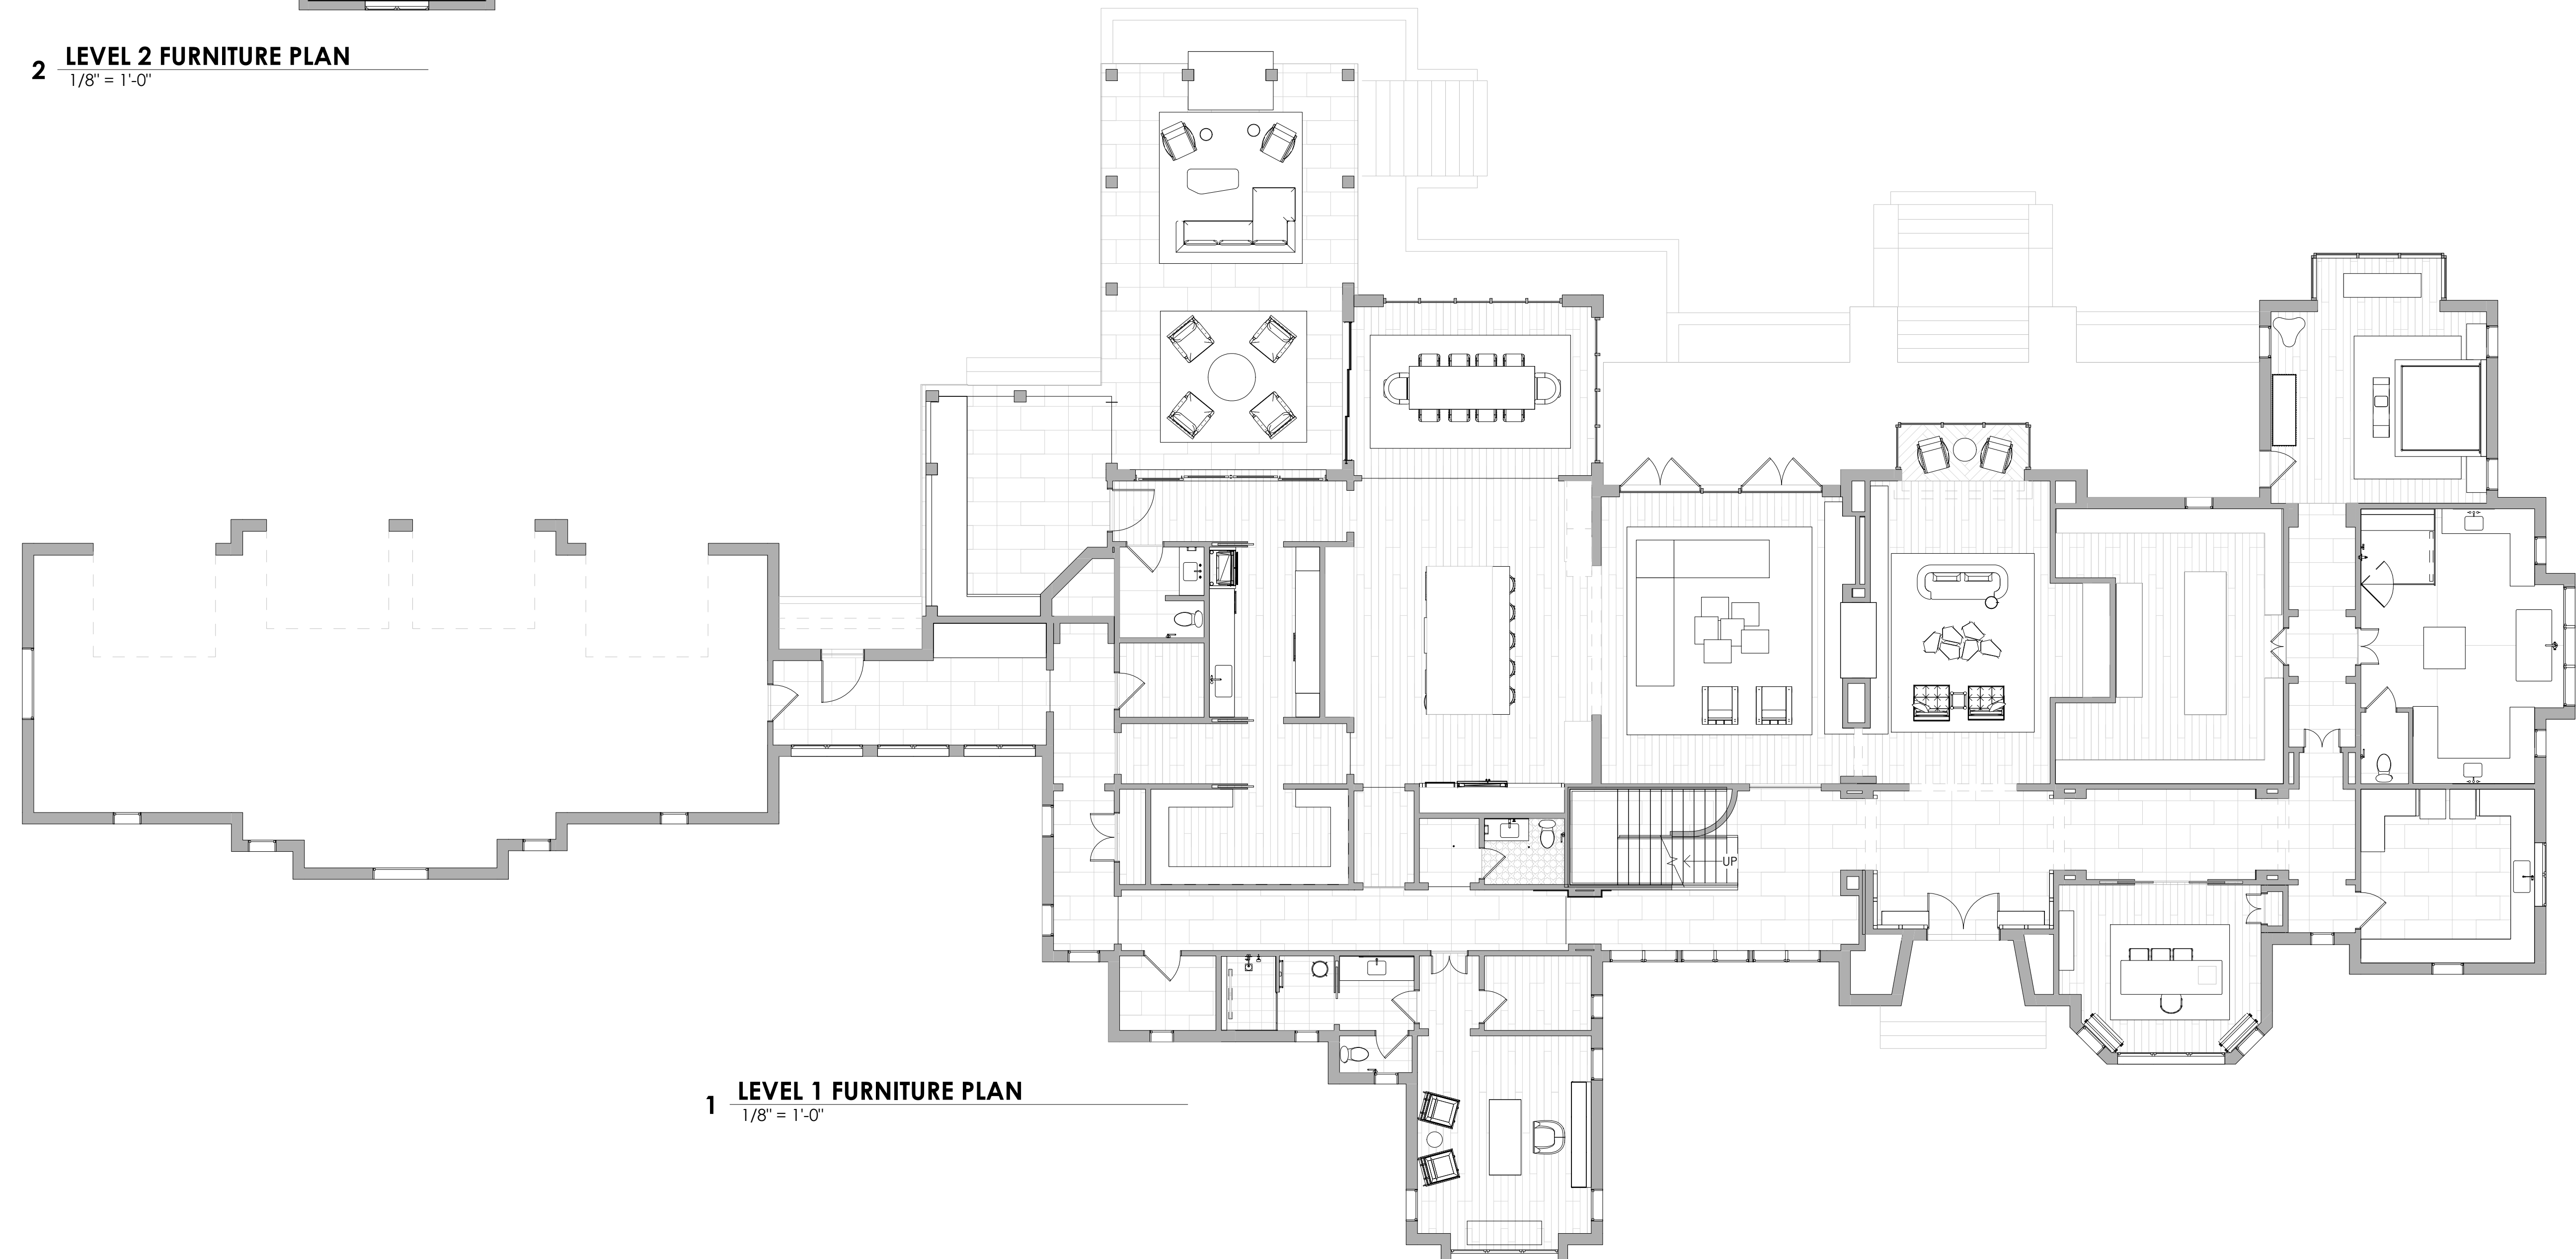

1 **LEVEL 1 FURNITURE PLAN**
1/8" = 1'-0"

FLOOR PLAN LEGEND

NAME	ROOM NAME
	WALL
GENERAL NOTES:	
DIMENSION STRINGS: DIMENSION FROM FACE OF FINISH TO FACE OF FINISH UNLESS NOTED OTHERWISE.	
SEE ELECTRICAL SHEETS FOR FLOOR BOX LOCATIONS.	



MURPHY MAUDE
INTERIORS
500 Madison unit 107,
Nashville, Tennessee 37208
w: murphymaudeinteriors.com
p: (901) 848-6402
copyright 2021

CLIENT
MR. AND MRS. CLIENT

PROJECT LOCATION
94 CUMBERLAND,
MEMPHIS, TN


PROJECT NAME
PERSONAL RESIDENCE

DATE ISSUED
DRAWING SCALE
8/14/2023
As indicated

DRAWING TITLE
FURNITURE PLANS

REVISIONS:		
NUMBER	DATE	DESCRIPTION

SUPPLEMENTAL INTERIOR DESIGN
DOCUMENT
ID102

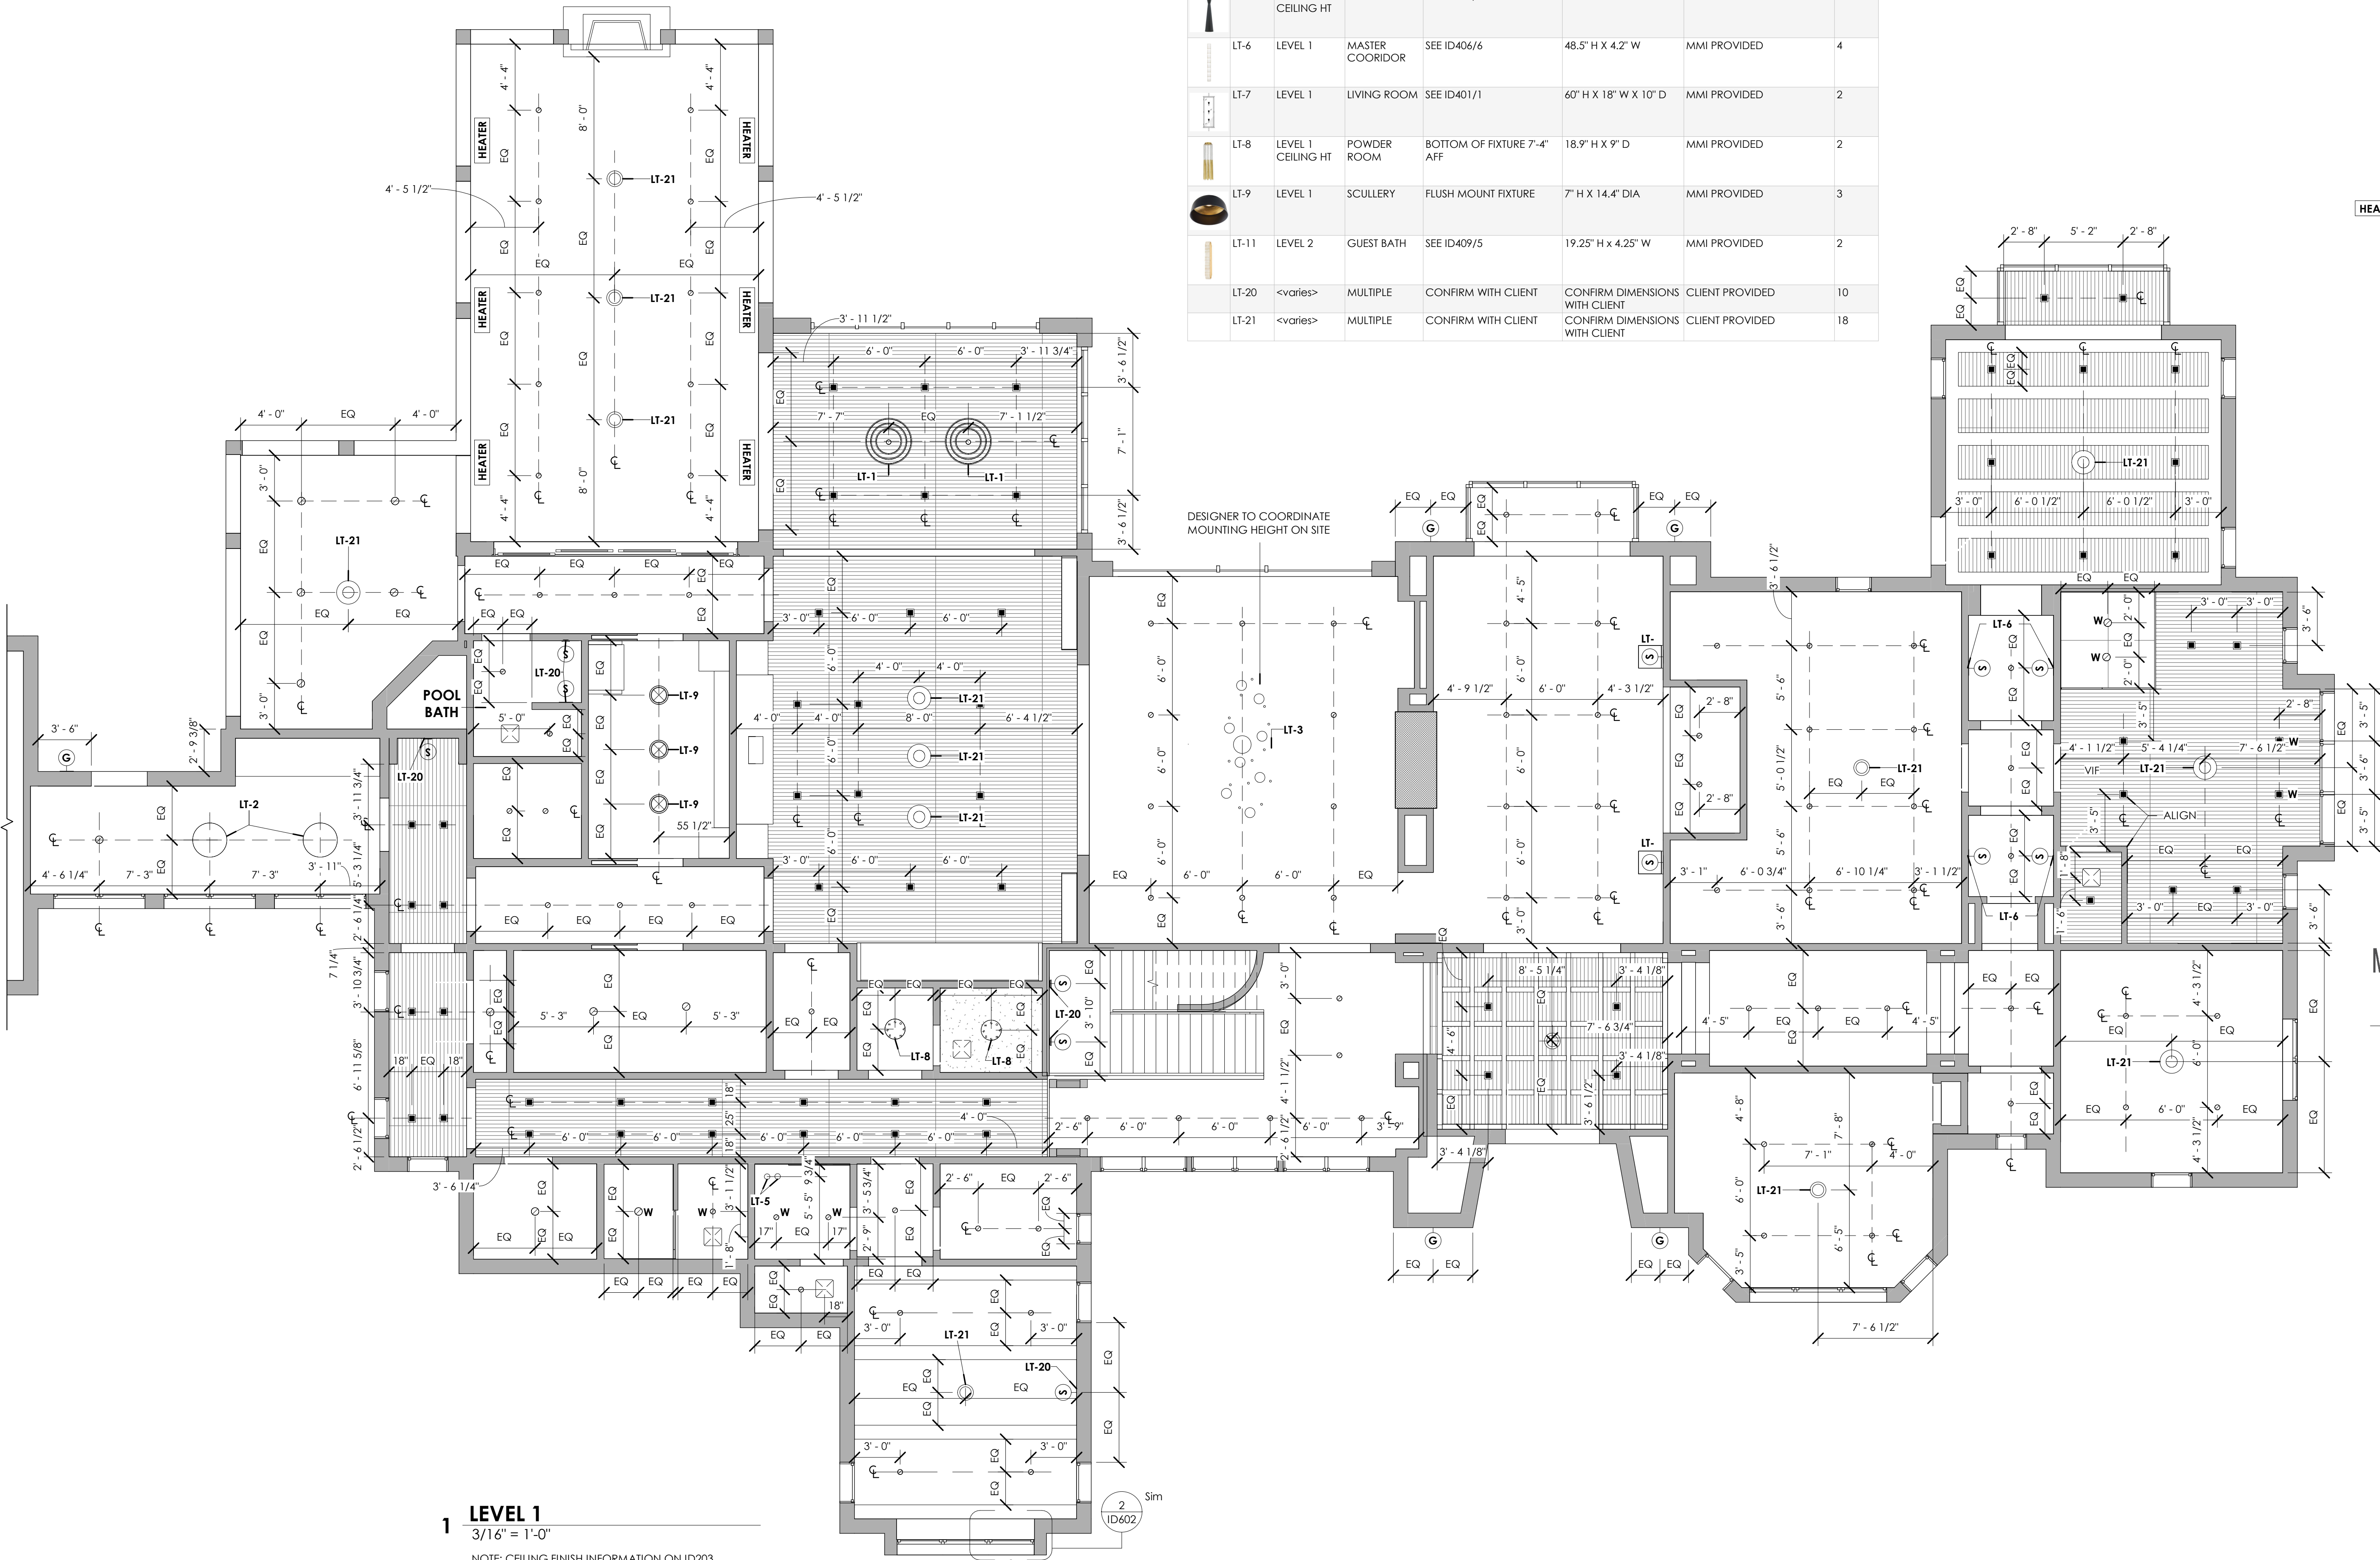

ACCENT LIGHTING SCHEDULE						
IMAGE	TAG	LEVEL	ROOM	HANGING HEIGHT	FIXTURE DIMENSIONS	WHERE ITS COMING FROM
	LT-1	LEVEL 1	DINING ROOM	BOTTOM OF FIXTURE 8'-5" AFF	48" H x 36" DIA.	MMI PROVIDED
	LT-2	LEVEL 1	FRIEND'S ENTRY	BOTTOM OF FIXTURE 9'-0" AFF	18.75" H X 27" DIA	MMI PROVIDED
	LT-3	LEVEL 1	GATHERING ROOM	BOTTOM OF FIXTURE 8'-0" AFF	108" L X 36" W	MMI PROVIDED
	LT-4	LEVEL 1	KITCHEN	SEE ID404/4	26" H X 8.5" W	MMI PROVIDED
	LT-5	LEVEL 1	JASON'S BATH	SEE ID408/6	18" H X 4.5" DIA	MMI PROVIDED
	LT-6	LEVEL 1	MASTER COORIDOR	SEE ID406/6	48.5" H X 4.2" W	MMI PROVIDED
	LT-7	LEVEL 1	LIVING ROOM	SEE ID401/1	60" H X 18" W X 10" D	MMI PROVIDED
	LT-8	LEVEL 1	POWDER ROOM	BOTTOM OF FIXTURE 7'-4" AFF	18.9" H X 9" D	MMI PROVIDED
	LT-9	LEVEL 1	SCULLERY	FLUSH MOUNT FIXTURE	7" H X 14.4" DIA	MMI PROVIDED
	LT-11	LEVEL 2	GUEST BATH	SEE ID409/5	19.25" H x 4.25" W	MMI PROVIDED
	LT-20	<varies>	MULTIPLE	CONFIRM WITH CLIENT	CONFIRM DIMENSIONS WITH CLIENT	CLIENT PROVIDED
	LT-21	<varies>	MULTIPLE	CONFIRM WITH CLIENT	CONFIRM DIMENSIONS WITH CLIENT	CLIENT PROVIDED

CEILING LEGEND

- NAME ROOM NAME
- 1' - 0" CEILING HEIGHT
- RECESSED LED STRIP**
COLOR TEMPERATURE: 3000K
COLOR RENDERING INDEX: MINIMUM 95
EQUAL TO ALLOY SLIM 5.5 TAILORED LED LIGHT FIXTURE
- 4" RECESSED CAN LIGHT**
3,000K, MIN 95 CRI, WHEN LOCATED IN ACCENT CEILING, USE FLANGELESS MODEL W/ BLACK BAFFLE. SPECIFIC MODEL SELECTED BY CONTRACTOR.
- 2" MINI RECESSED CAN LIGHT** WITH ABOVE SPECS
- 4" WATERPROOF RECESSED CAN LIGHT** WITH ABOVE SPECS
- 4" SQUARE TRIMLESS INTEGRATED LED LIGHT**
- JUNCTION BOX**
- SCONCE** WITH THE WALL NOTED IN WHICH THE SCONCE PROJECTS FROM
- HEATER** **61.25" SURFACE MOUNTED HEATER:**

ISLAND PENDANT LIGHTING:
BOTTOM OF PENDANT LIGHTS MOUNTED AT 36" ABOVE COUNTER SURFACE

CHANDELIER HEIGHT:
BOTTOM OF CHANDELIER MOUNTED AT 7' ABOVE FLOOR, FOR EVERY FOOT OVER 8' CEILINGS, ADD AN ADDITIONAL 3" OF HEIGHT.



MURPHY MAUDE
INTERIORS

500 Madison unit 107,
Nashville, Tennessee 37208
w: murphymaudeinteriors.com
p: (901) 848-6402
copyright 2021

CLIENT
MR. AND MRS. CLIENT

PROJECT LOCATION
94 CUMBERLAND,
MEMPHIS, TN

PROJECT NAME
PERSONAL RESIDENCE

DATE ISSUED 8/14/2023
DRAWING SCALE As indicated

DRAWING TITLE
FIRST FLOOR CEILING
PLAN

REVISIONS:
NUMBER DATE DESCRIPTION

SUPPLEMENTAL INTERIOR DESIGN
DOCUMENT
ID201



NOTE: CEILING FINISH INFORMATION ON ID203


1.5" TRIMLESS LINEAR RECESSED LED LIGHT
TO BE FLUSH WITH CEILING

2' - 0"


LED STRIPS TO BE INSTALLED 2'-0"
AWAY FROM PERIMETER OF ENTIRE
EXERCISE ROOM.

$$1'' = 1' - 0''$$


CHANDELIER HEIGHT:
BOTTOM OF CHANDELIER MOUNTED AT 7" ABOVE FLOOR.
FOR EVERY FOOT OVER 8' CEILINGS, ADD AN ADDITIONAL
3" OF HEIGHT.

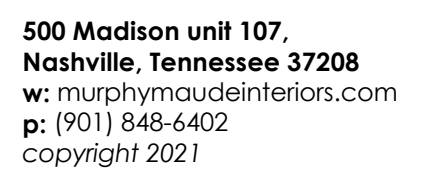

**SUPPLEMENTAL INTERIOR DESIGN
DOCUMENT
ID202**

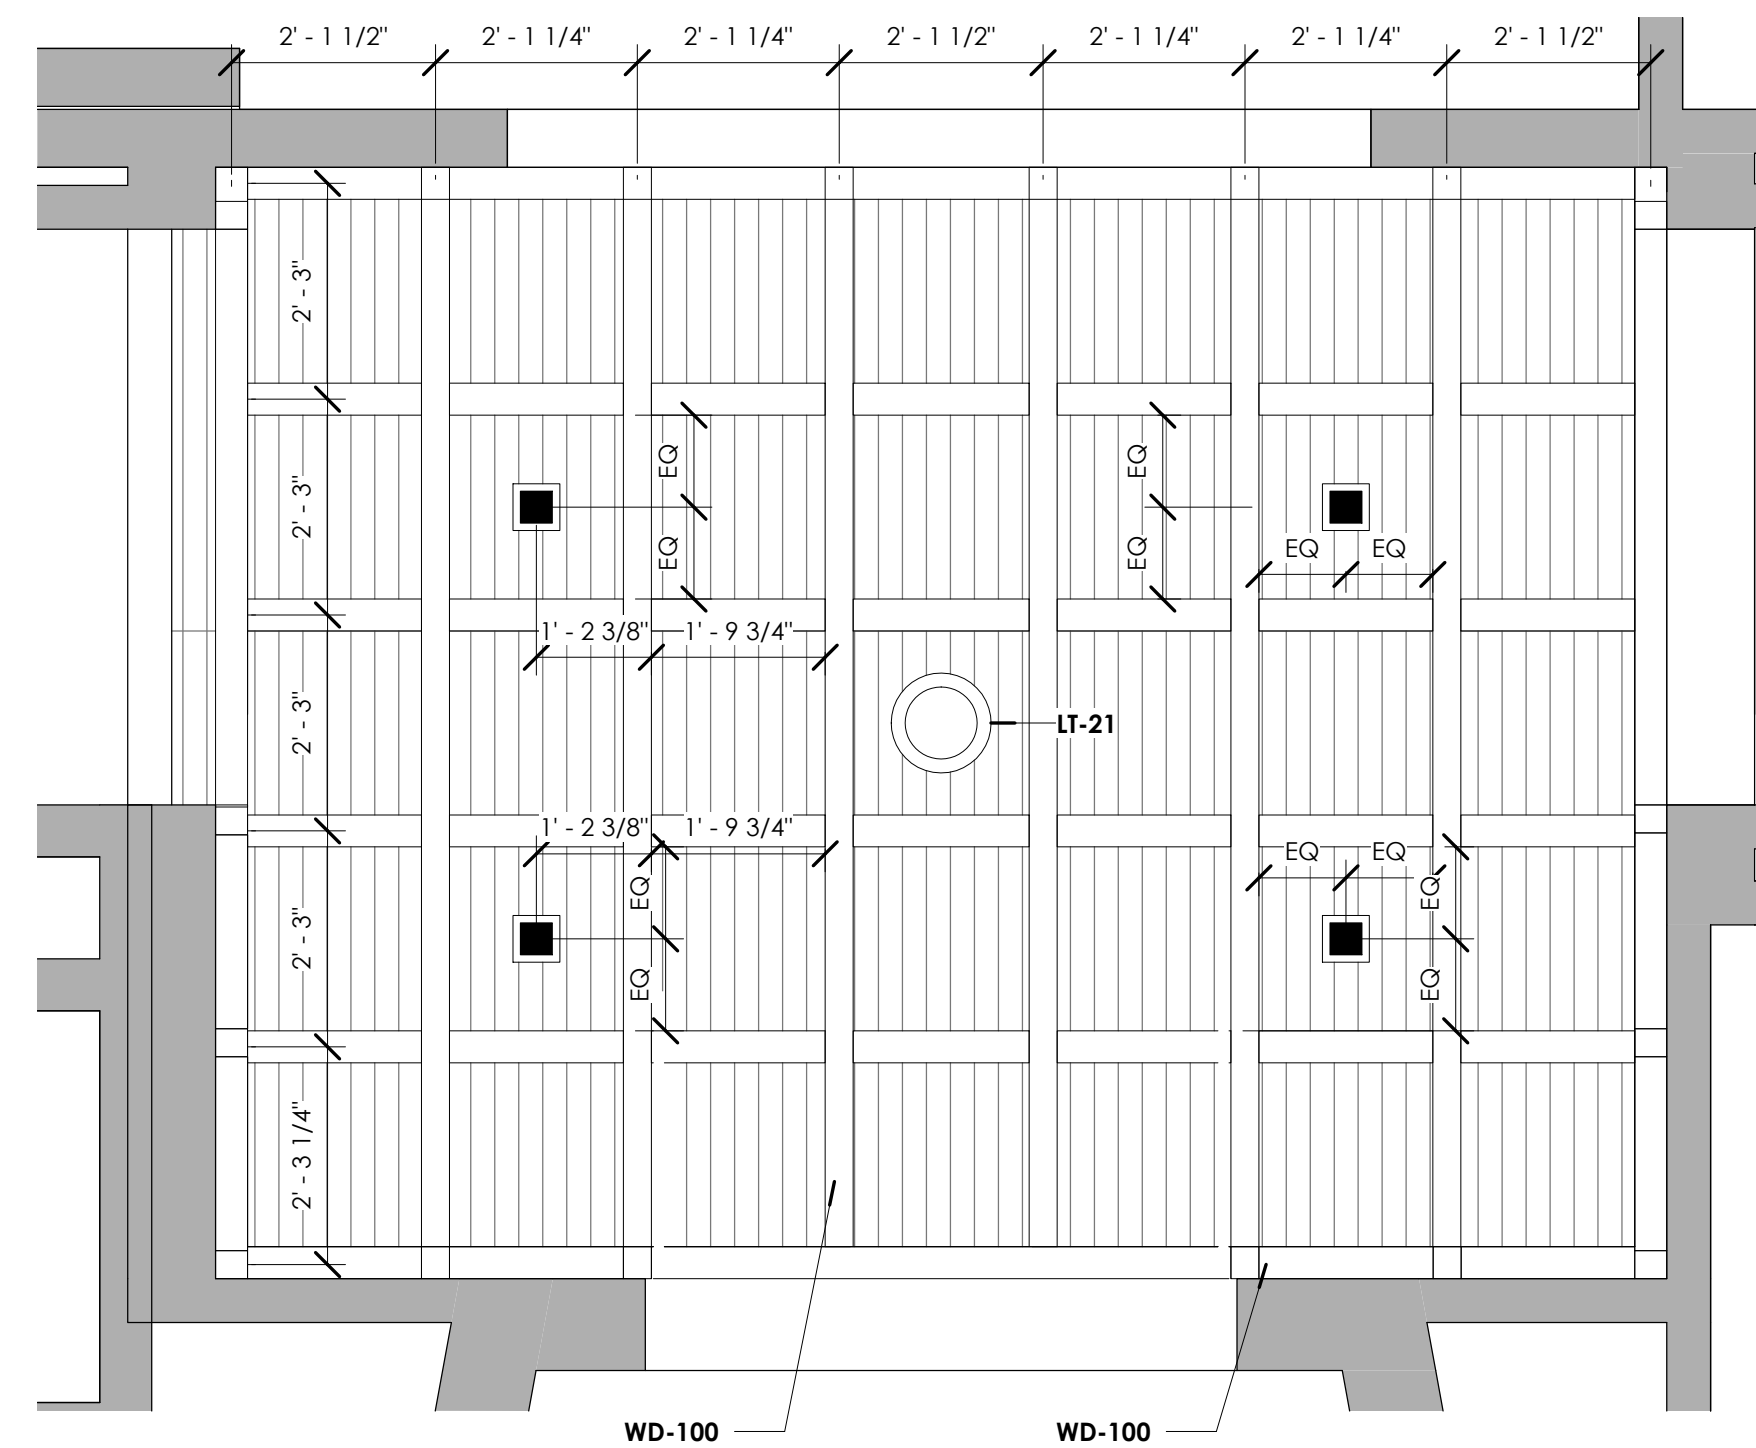


**3 LEVEL 1 FOYER CEILING
ENLARGED PLAN**
1/2" = 1'-0"

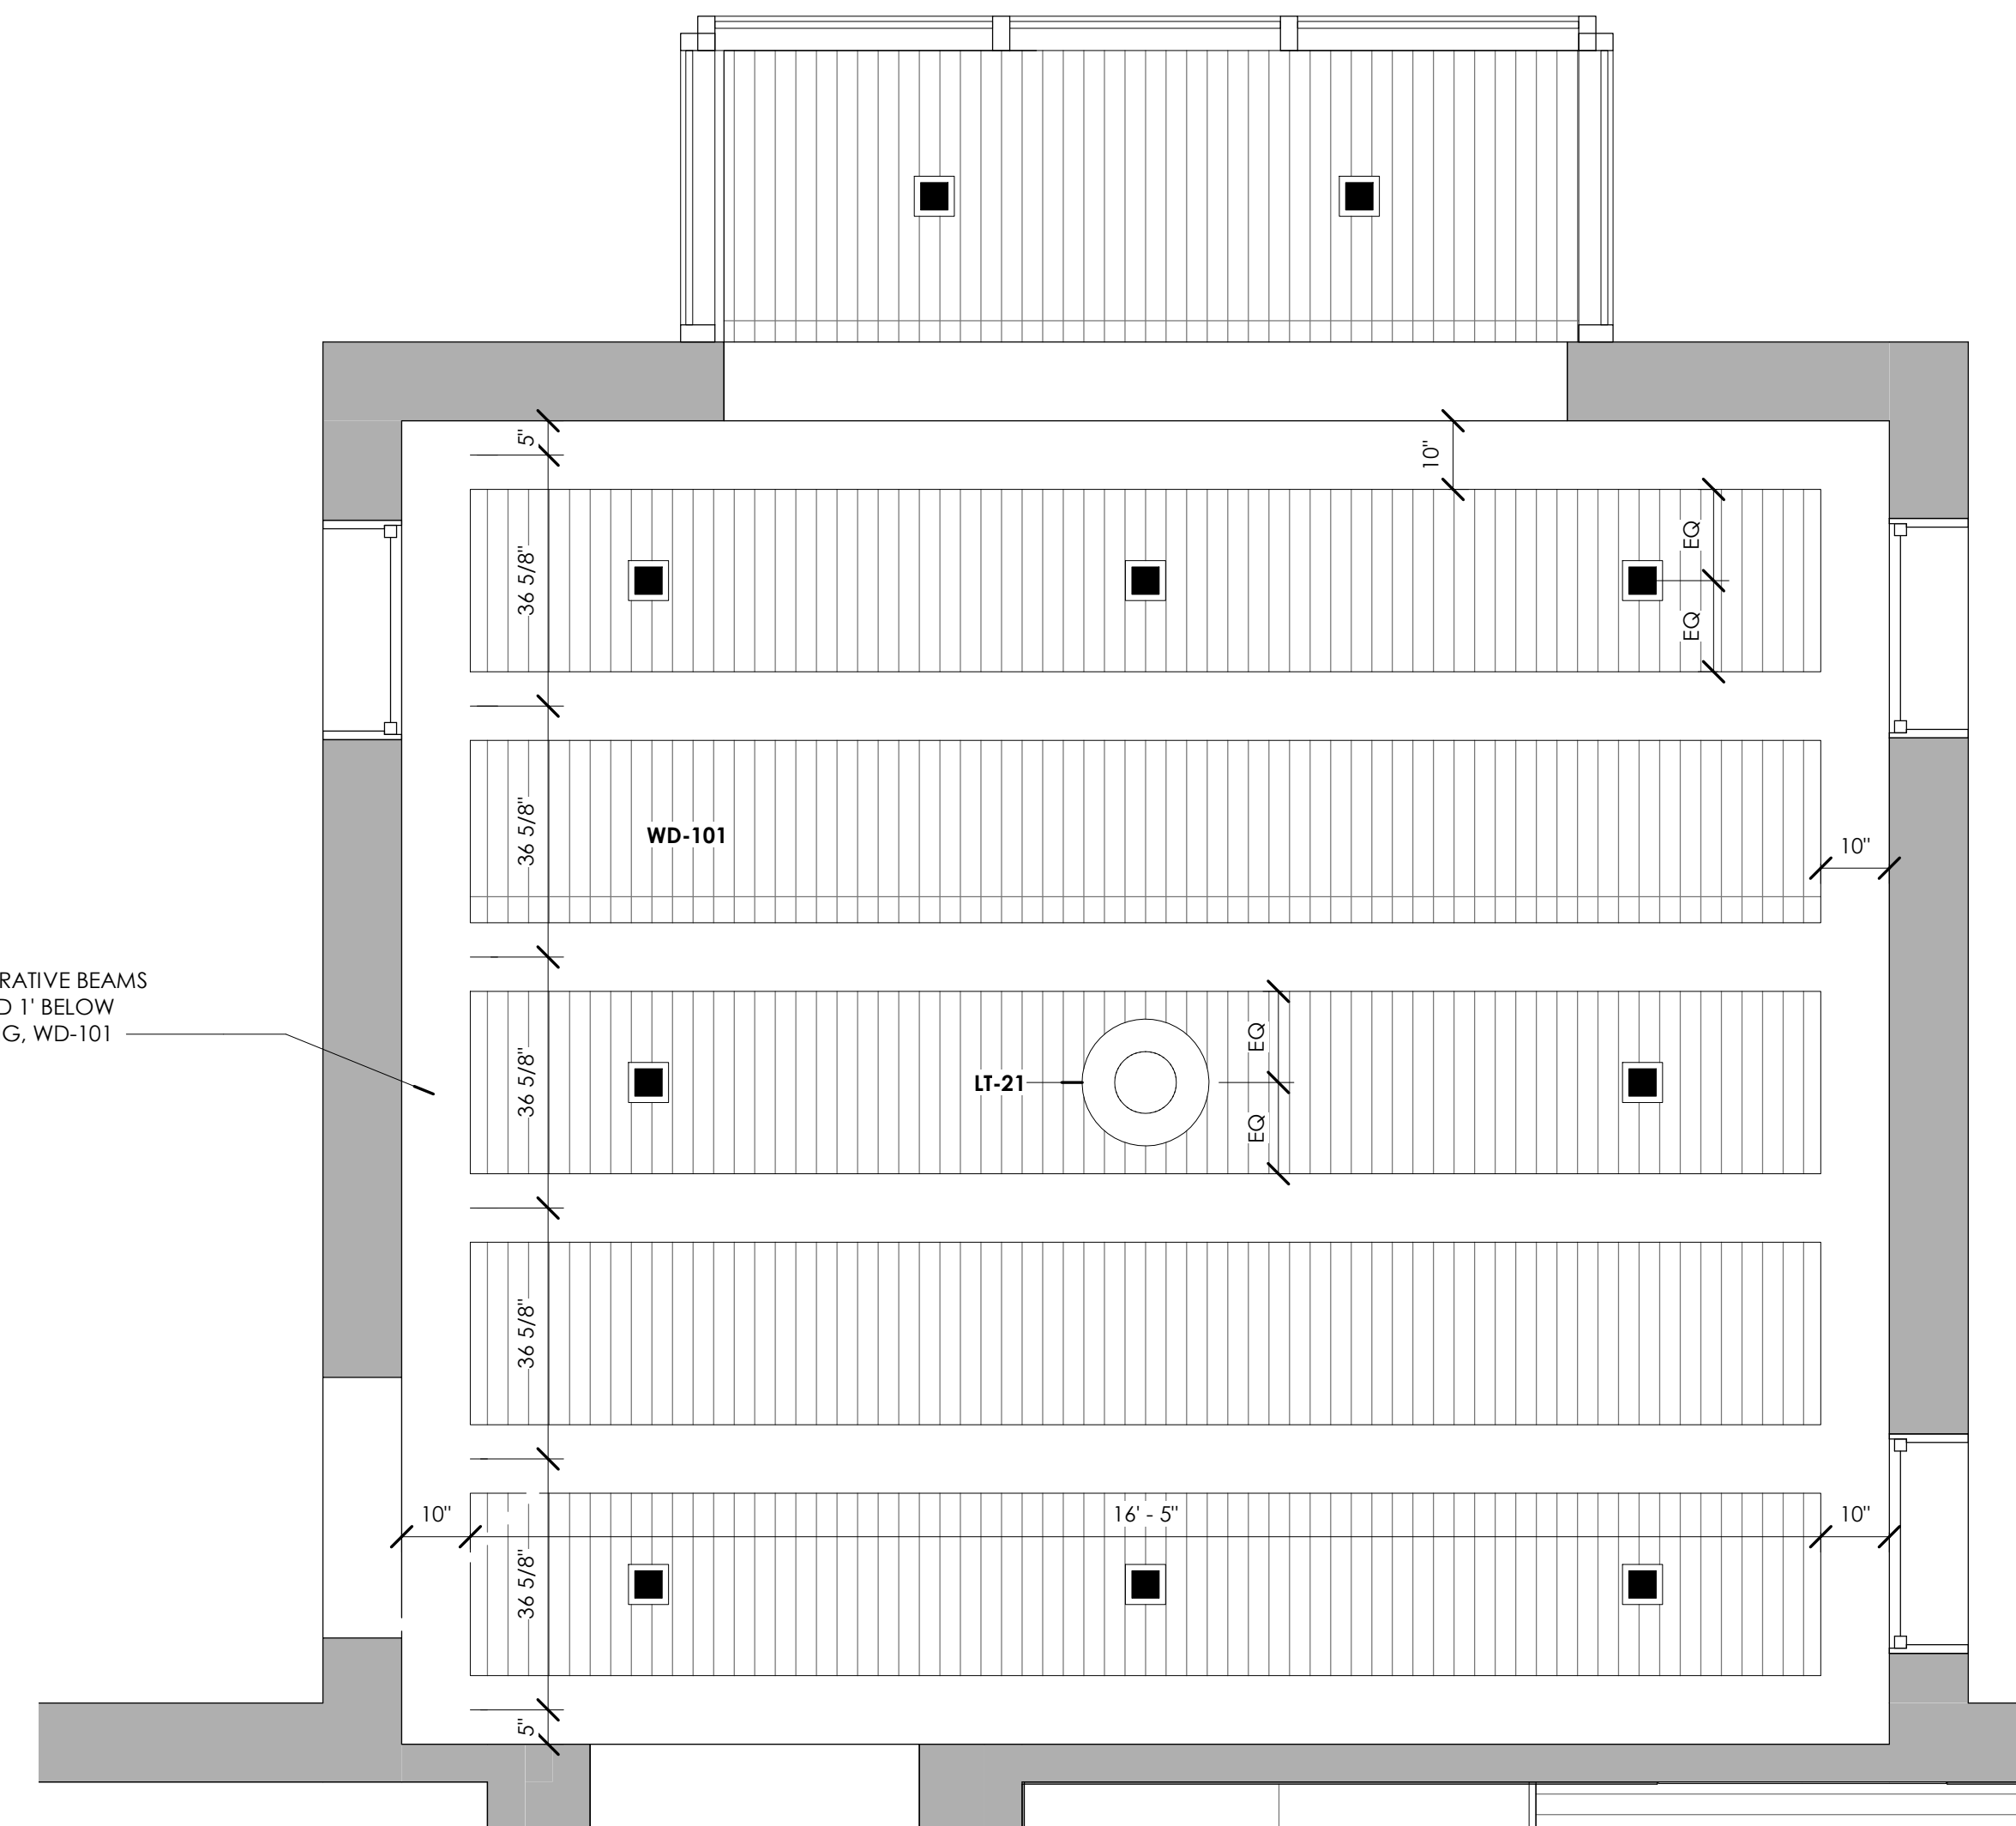

**4 LEVEL 1 MASTER BEDROOM
CEILING ENLARGED PLAN**
1/2" = 1'-0"




2 SECOND FLOOR CEILING PLAN

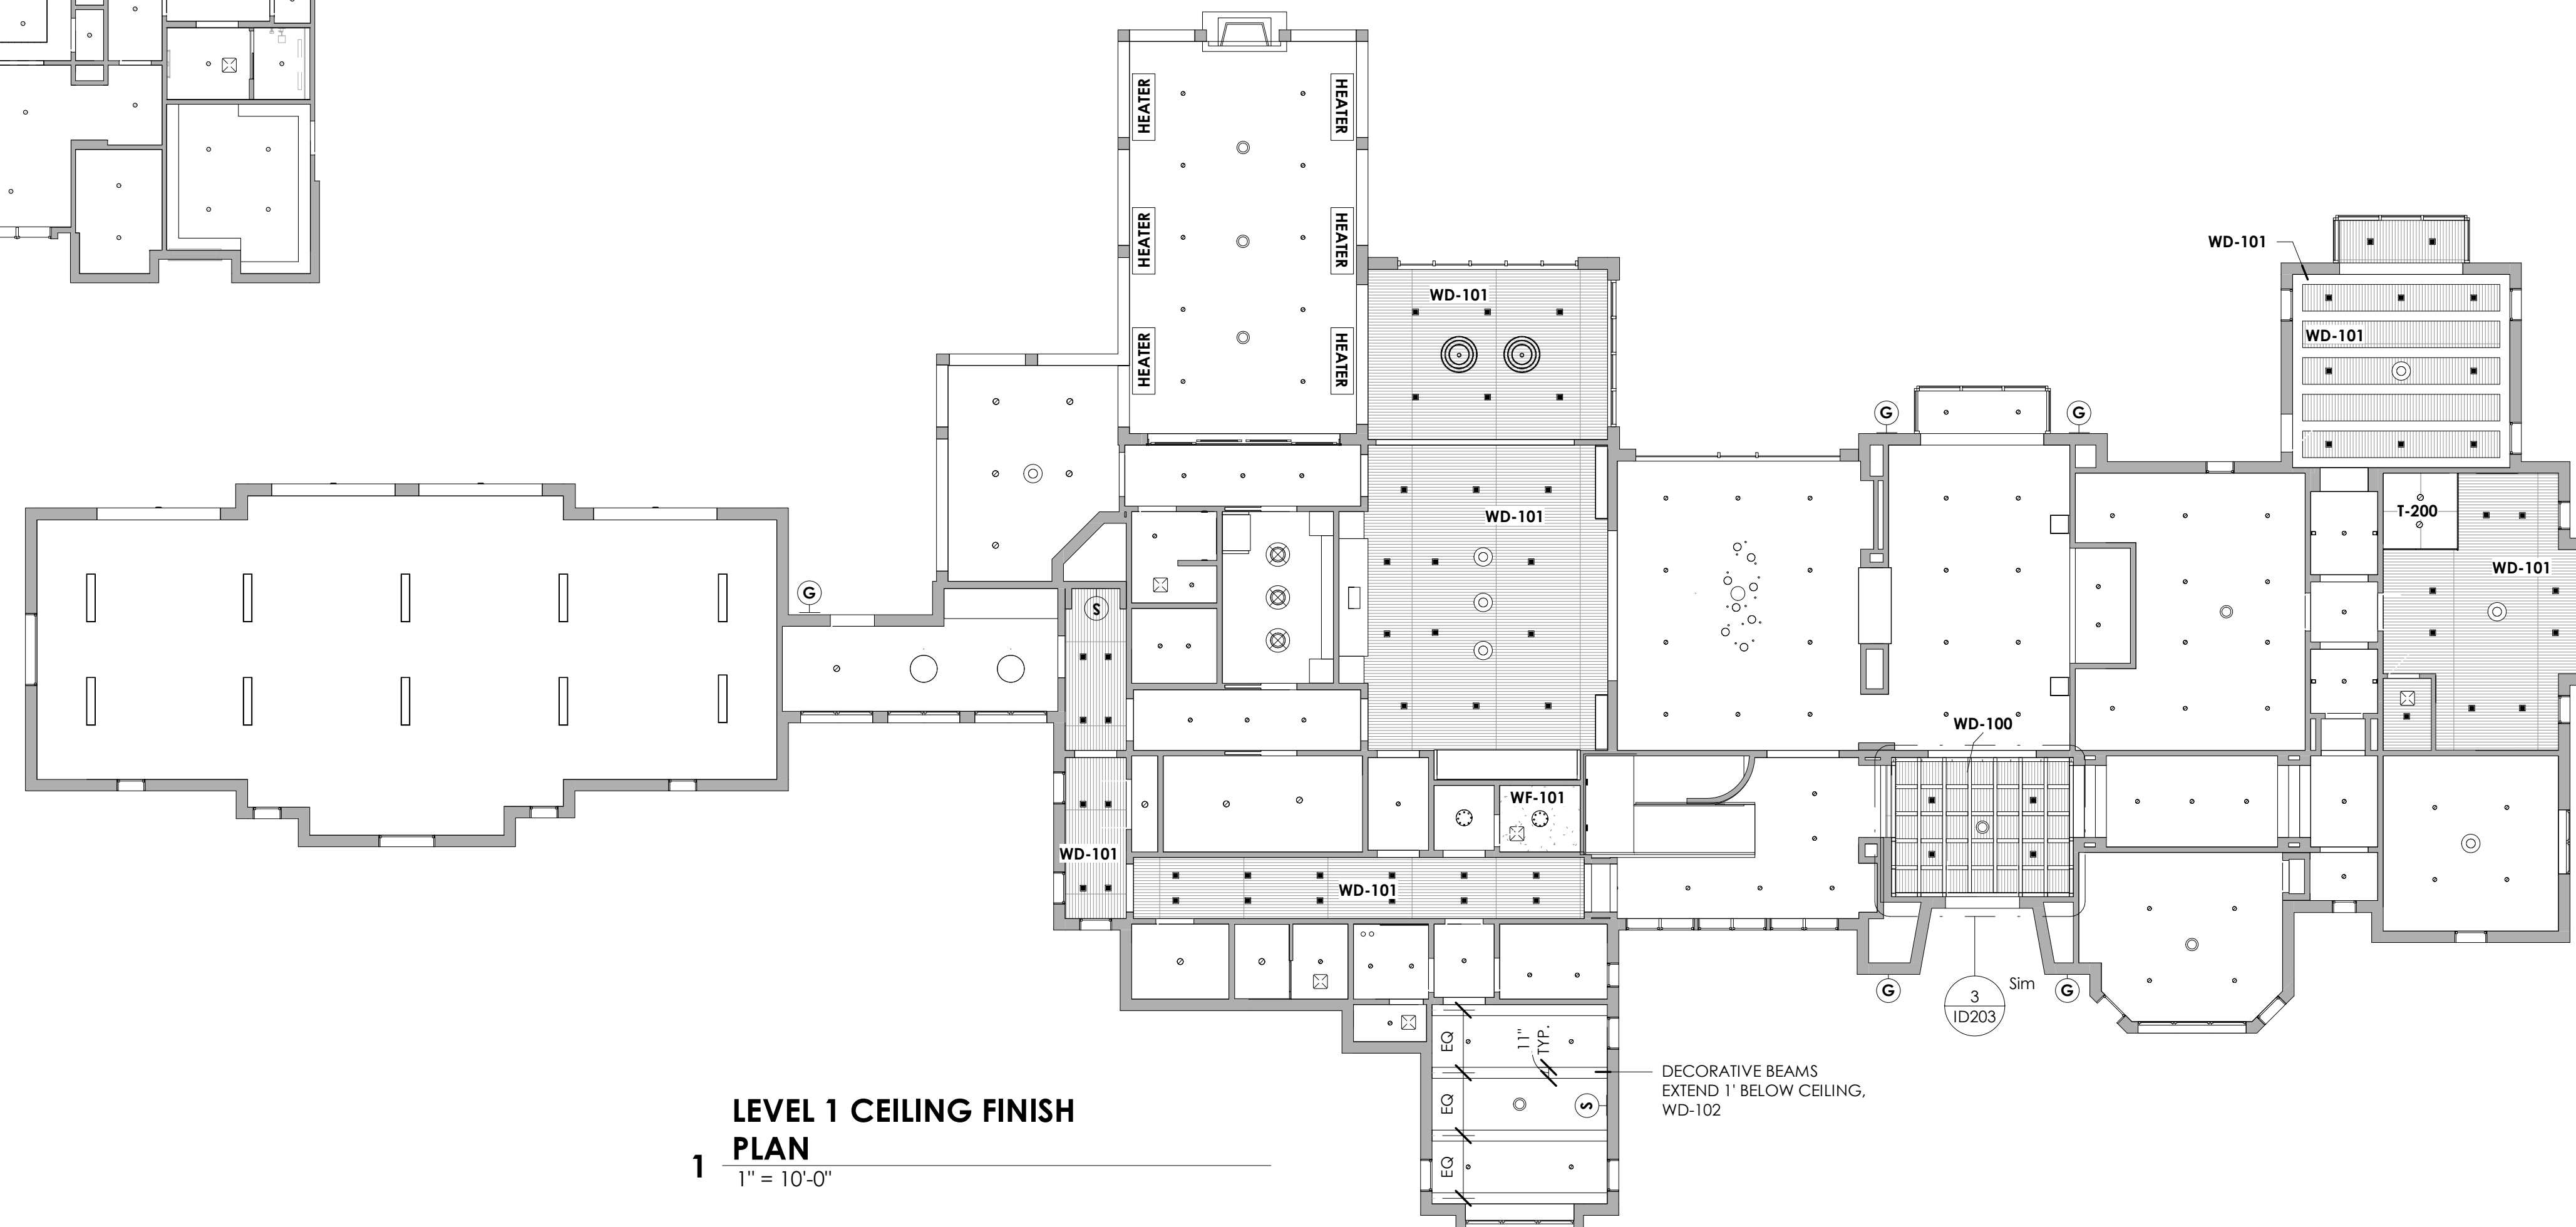

LEVEL 1 CEILING FINISH PLAN
1" = 10'-0"

CEILING FINISH LEGEND

NOTE: PROVIDE SAMPLE TO DESIGNER FOR APPROVAL

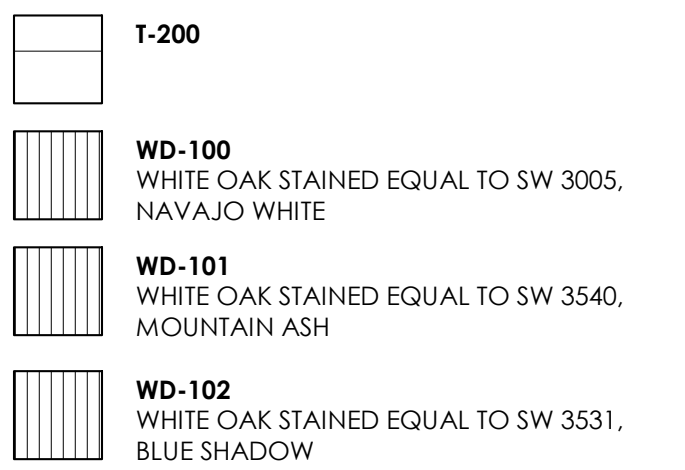

CLIENT
MR. AND MRS. CLIENT

PROJECT LOCATION
94 CUMBERLAND,
MEMPHIS, TN

PROJECT NAME
PERSONAL RESIDENCE

DATE ISSUED	8/14/2023
DRAWING SCALE	As indicated

CEILING FINISH PLANS

REVISIONS:		
NUMBER	DATE	DESCRIPTION

**SUPPLEMENTAL INTERIOR DESIGN
DOCUMENT
ID203**

CEILING LEGEND

NAME ROOM NAME

1' = 0" CEILING HEIGHT

RECESSED LED STRIP
COLOR TEMPERATURE: 3000K
COLOR RENDERING INDEX: MINIMUM 95
EQUAL TO ALLOY SLIM 5.5 TAILORED LED LIGHT FIXTURE

4" RECESSED CAN LIGHT
3,000K, MIN 95 CRI, WHEN LOCATED IN ACCENT CEILING,
USE FLANGELESS MODEL W/ BLACK BAFFLE, SPECIFIC
MODEL SELECTED BY CONTRACTOR.

2" MINI RECESSED CAN LIGHT WITH ABOVE SPECS

4" WATERPROOF RECESSED CAN LIGHT WITH ABOVE
SPECS

4" SQUARE TRIMLESS INTEGRATED LED LIGHT

JUNCTION BOX

SCONCE WITH THE WALL NOTED IN WHICH THE SCONCE
PROJECTS FROM

HEATER 61.25" SURFACE MOUNTED HEATER:

ISLAND PENDANT LIGHTING:
BOTTOM OF PENDANT LIGHTS MOUNTED AT 36" ABOVE
COUNTER SURFACE

CHANDELIER HEIGHT:
BOTTOM OF CHANDELIER MOUNTED AT 7' ABOVE FLOOR.
FOR EVERY FOOT OVER 8' CEILINGS, ADD AN ADDITIONAL
3" OF HEIGHT.

ELECTRICAL LEGEND

NAME ROOM NAME

RECEPTACLE WALL DUPLEX - 12" A.F.F.U.N.O.

RECEPTACLE WALL DUPLEX (ABOVE COUNTERTOPS) - 42" A.F.F.U.N.O.

RECEPTACLE INTEGRATED W/ CABINET DESIGN - SEE CABINET
ELEVATIONS FOR EXACT LOCATIONS

EQUAL TO DESIGNMOD SMOOTHLINE FLUSH-MOUNT WALL PLATE
RECEPTACLE

GFCI RECEPTACLE WALL DUPLEX - 12" AFF U.N.O.

SWITCH

THREE WAY SWITCH

FOUR WAY SWITCH

AUTOMATIC SWITCH

FLOOR BOX DUPLEX OUTLET

TV + POWER + DATA+CAT 6 - 54" A.F.F.U.N.O.

INCORPORATE USB/USB-C

GAS WALL MOUNT FIXTURE

- NOTES:
- OUTDOOR OUTLETS OR ADJACENT TO WATER SOURCE SHALL BE GFCI.
 - PROVIDE ADEQUATE AMPERAGE PER EQUIPMENT.
 - REFER TO ELECTRICAL CONTRACTOR TO ACHIEVE DESIGN INTENT IN ACCORDANCE WITH APPLICABLE CODE REQUIREMENTS



MURPHY MAUDE
INTERIORS

500 Madison unit 107,
Nashville, Tennessee 37208
w: murphymaudeinteriors.com
p: (901) 848-6402
copyright 2021

CLIENT
MR. AND MRS. CLIENT

PROJECT LOCATION
94 CUMBERLAND,
MEMPHIS, TN

PROJECT NAME
PERSONAL RESIDENCE

DATE ISSUED
DRAWING SCALE


8/14/2023
As indicated

DRAWING TITLE
FIRST FLOOR ELECTRICAL
PLAN

REVISIONS:
NUMBER DATE DESCRIPTION


SUPPLEMENTAL INTERIOR DESIGN
DOCUMENT
ID204

1 LEVEL 1 ELECTRICAL PLAN
3/16" = 1'-0"

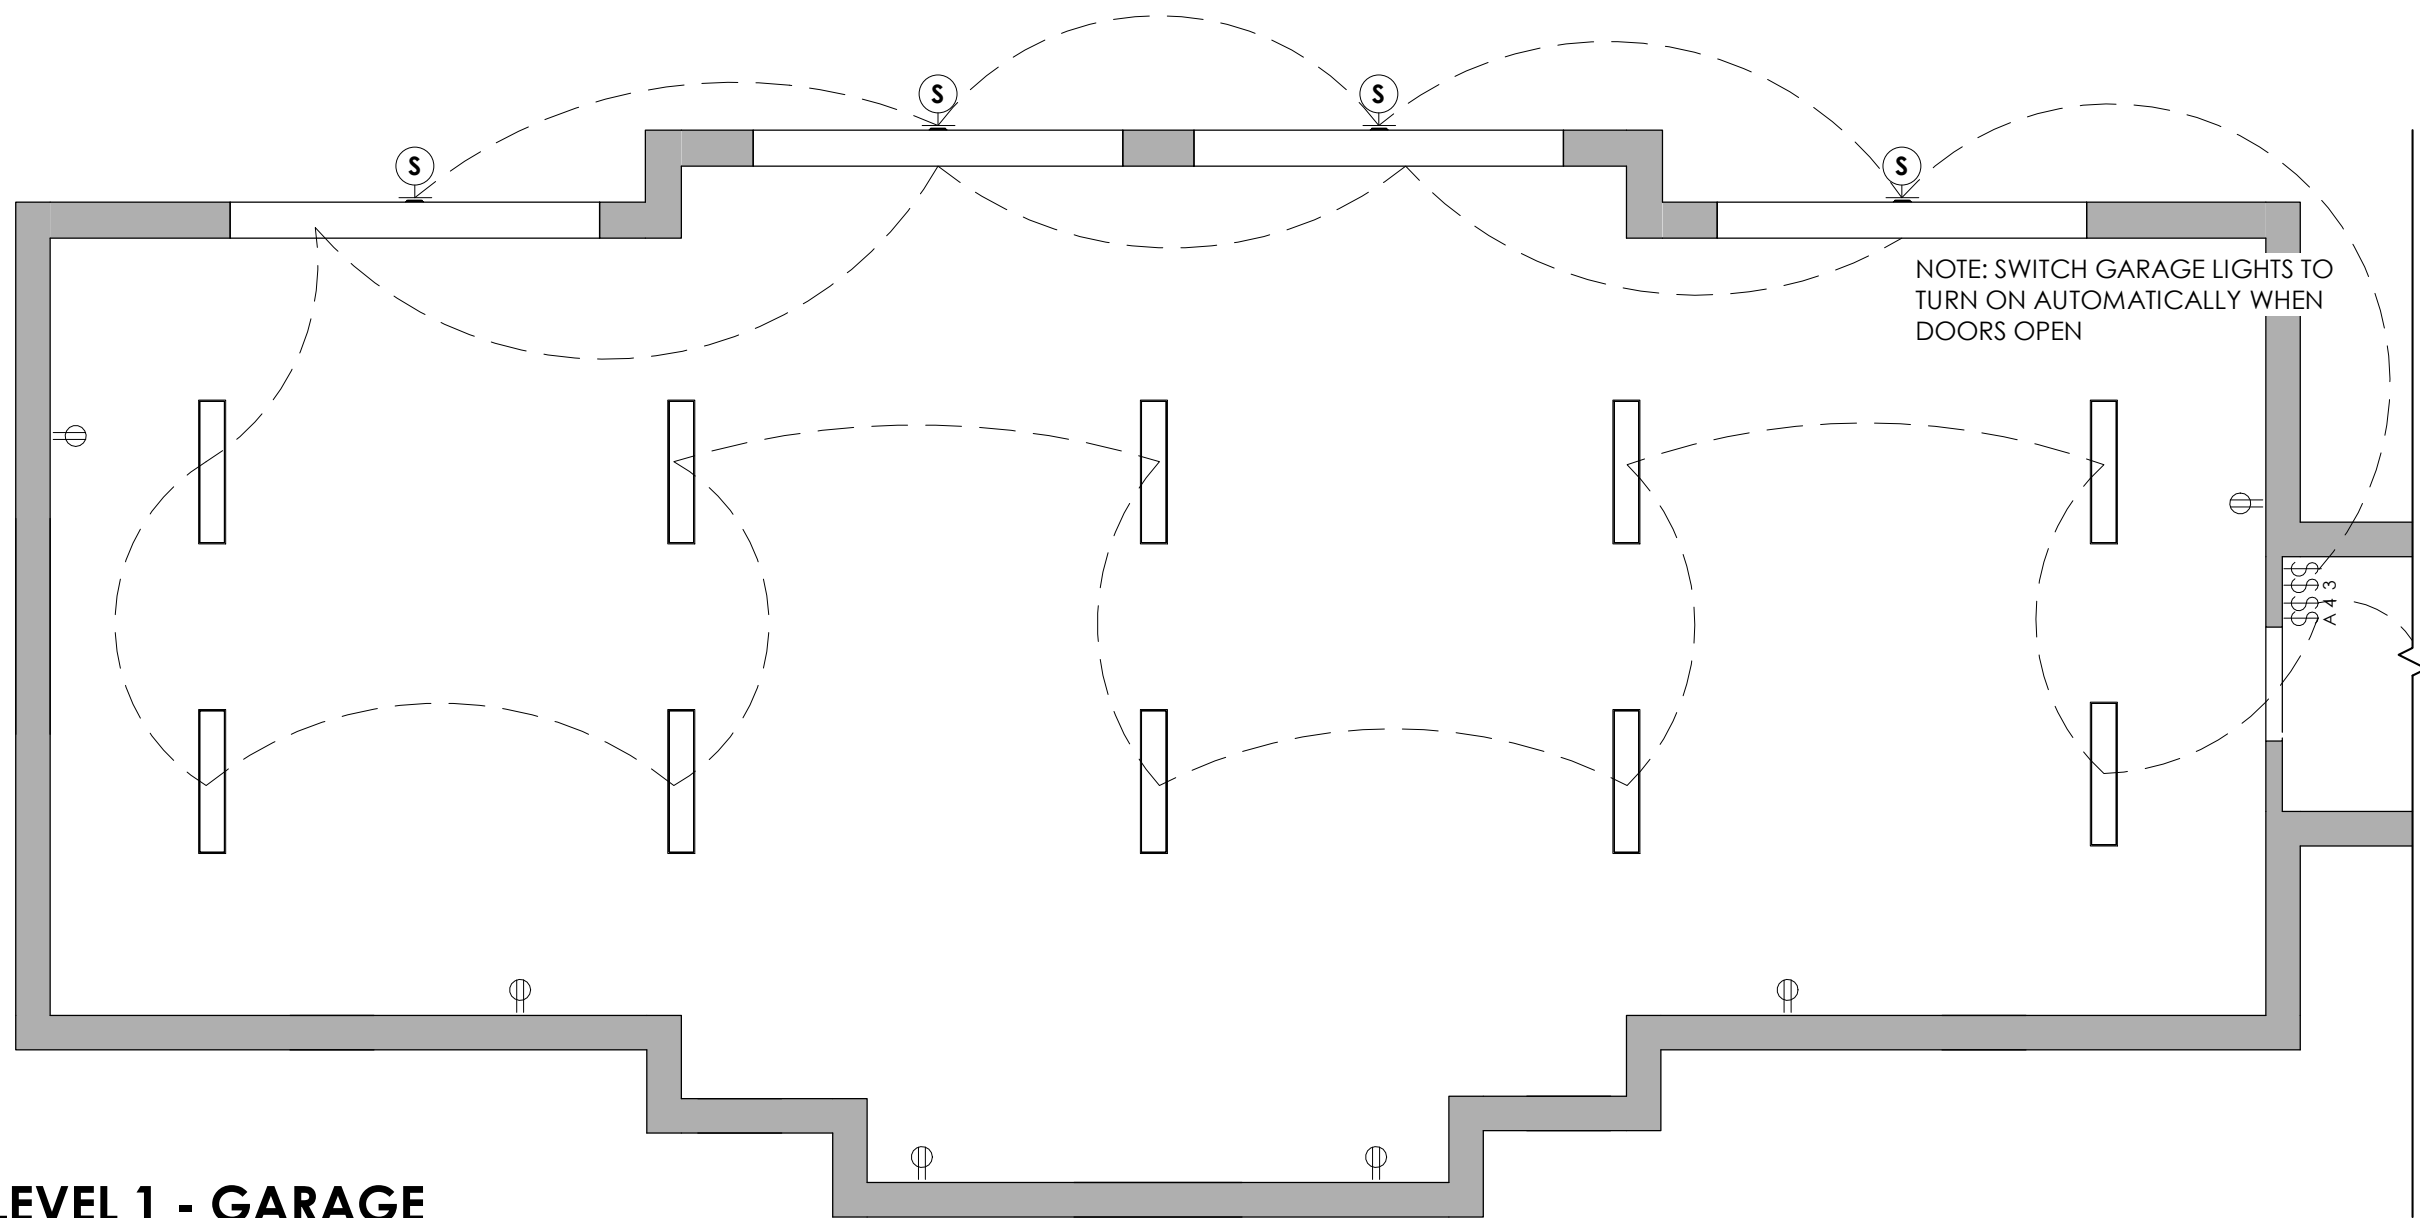

LEVEL 1 - GARAGE
ELECTRICAL PLAN

2
3/16" = 1'-0"
NOTE: CONFER WITH CLIENT FOR OUTLETS FOR FUTURE ELECTRONIC VEHICLES

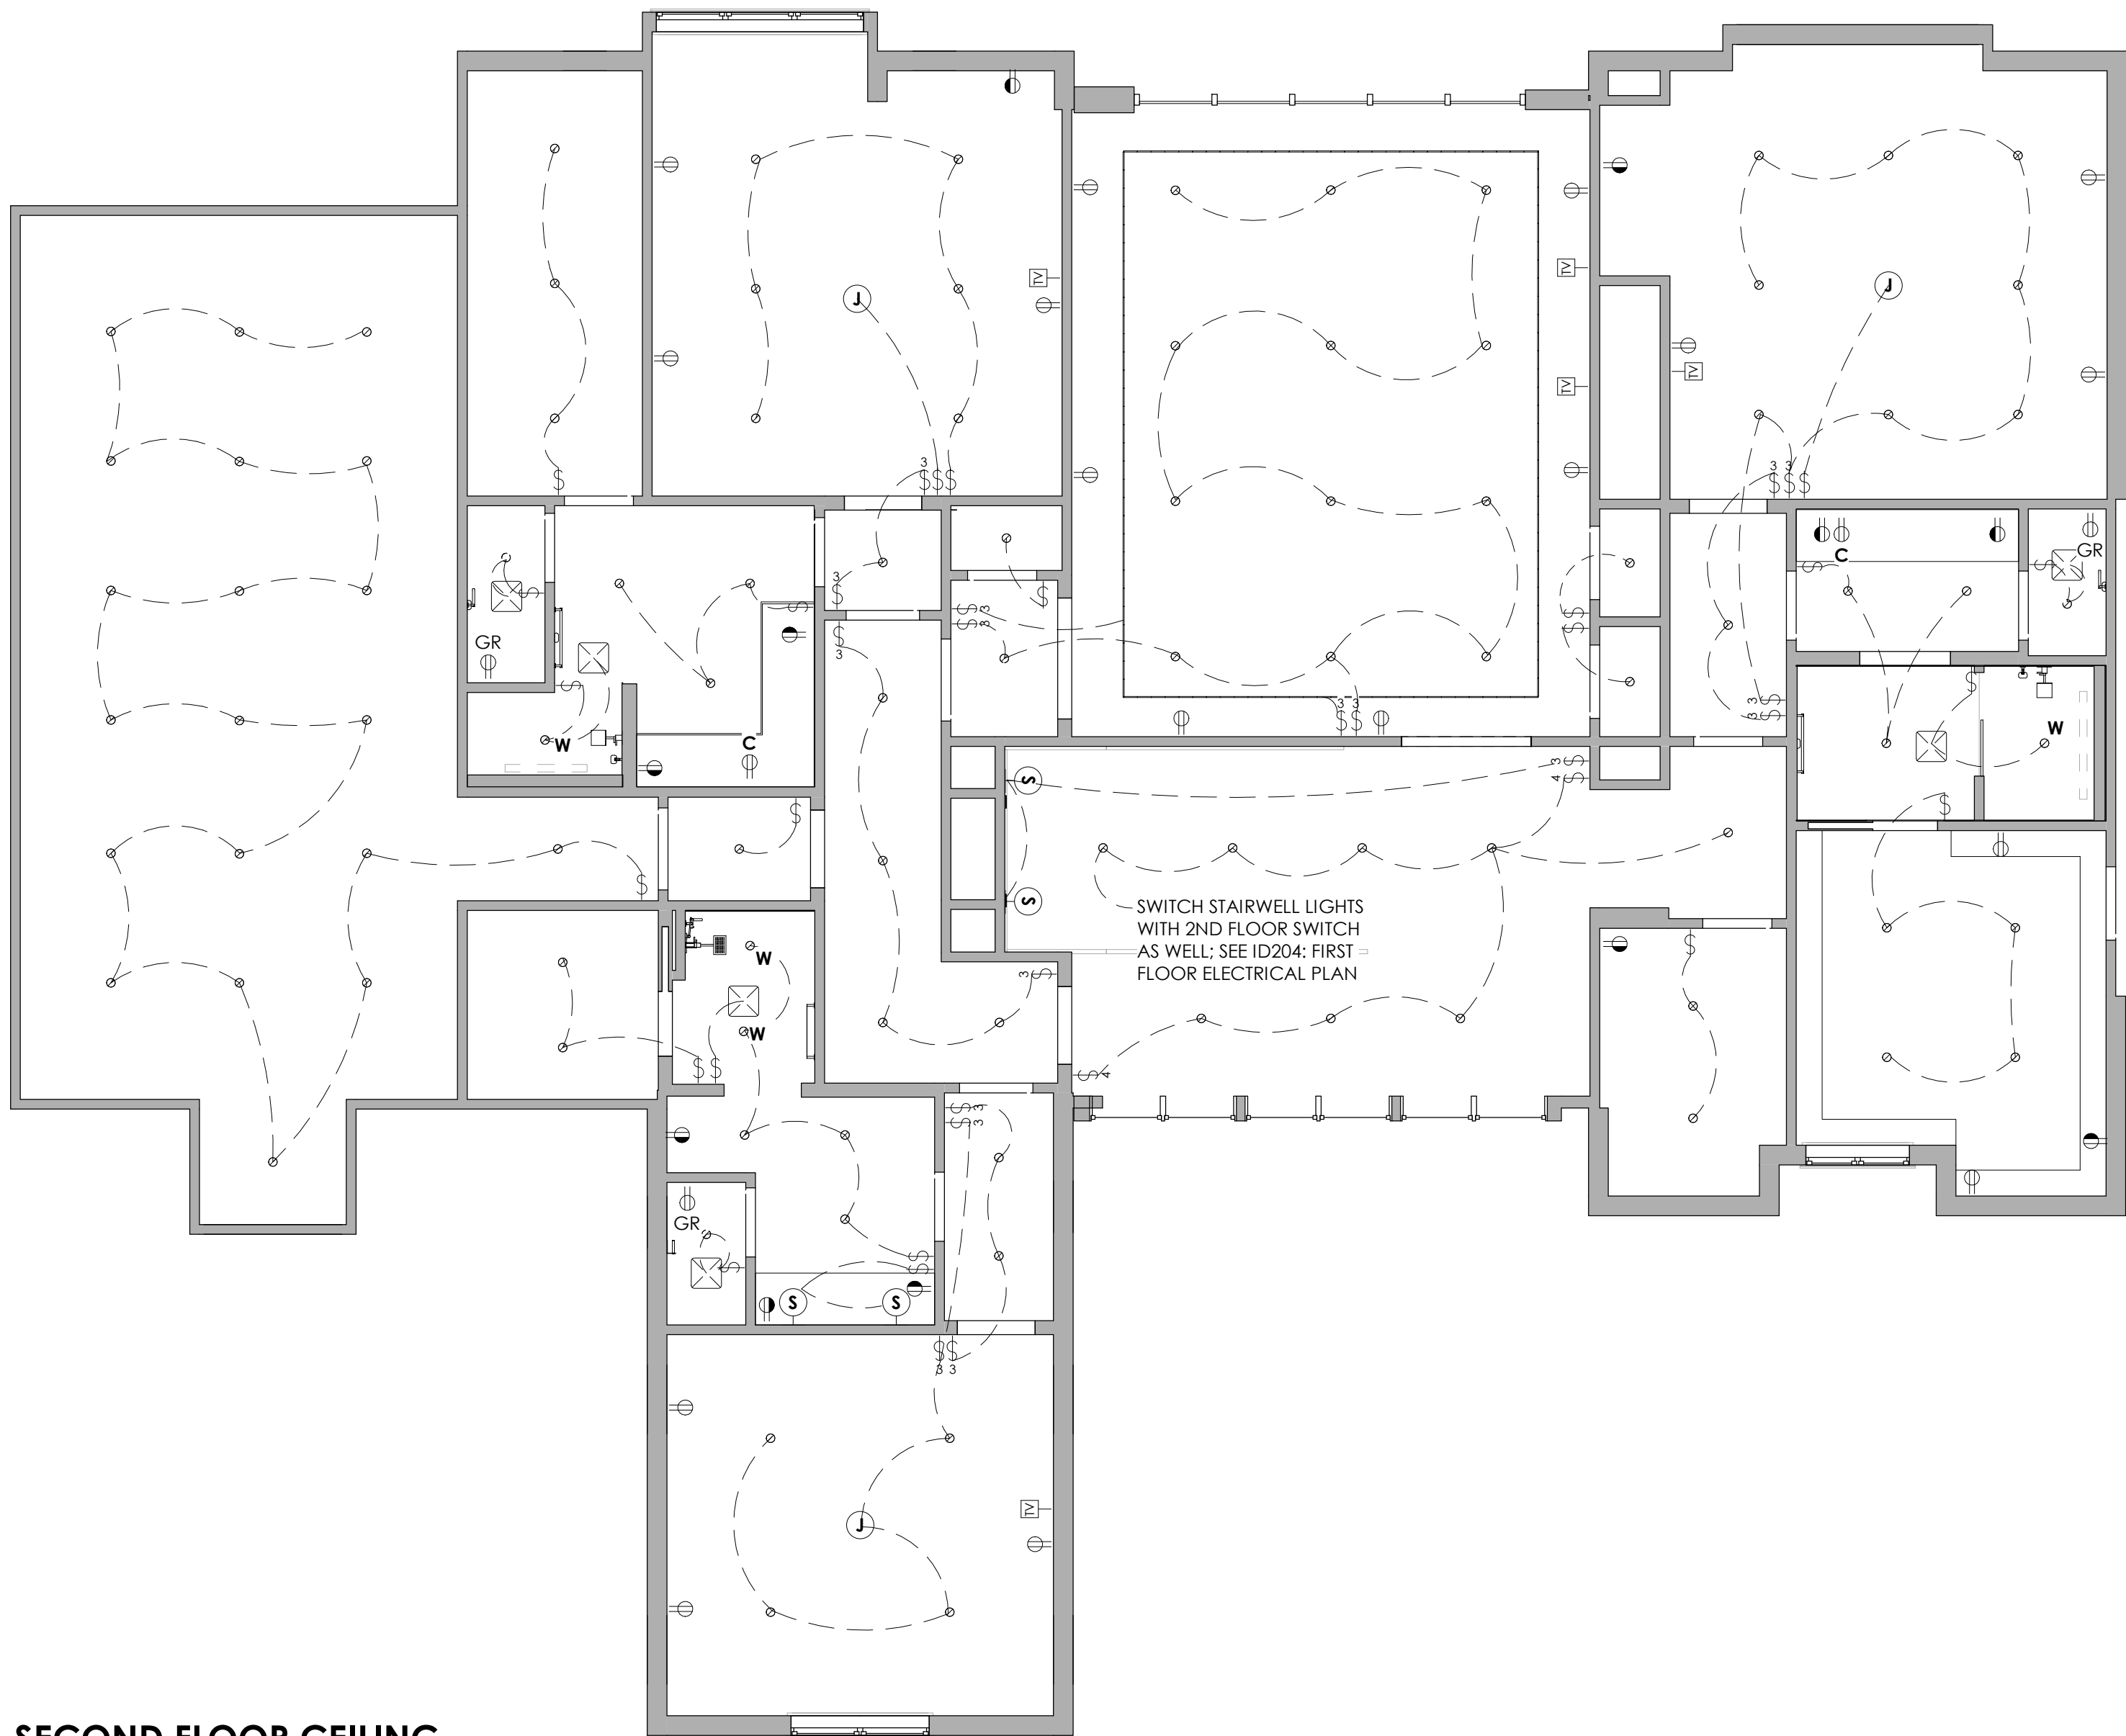

SECOND FLOOR CEILING
PLAN

1
3/16" = 1'-0"

CEILING LEGEND

NAME	ROOM NAME
1'-0"	CEILING HEIGHT
	RECESSED LED STRIP COLOR TEMPERATURE: 3000K COLOR RENDERING INDEX: MINIMUM 95 EQUAL TO ALLOY SLIM 5.5 TAILORED LED LIGHT FIXTURE
	4" RECESSED CAN LIGHT 3,000K; MIN 95 CRI. WHEN LOCATED IN ACCENT CEILING, USE FLANGELESS MODEL W/ BLACK BAFFLE. SPECIFIC MODEL SELECTED BY CONTRACTOR.
M	2" MINI RECESSED CAN LIGHT WITH ABOVE SPECS
W	4" WATERPROOF RECESSED CAN LIGHT WITH ABOVE SPECS
	4" SQUARE TRIMLESS INTEGRATED LED LIGHT
J	JUNCTION BOX
S	SCONCE WITH THE WALL NOTED IN WHICH THE SCONCE PROJECTS FROM
HEATER	61.25" SURFACE MOUNTED HEATER:
	ISLAND PENDANT LIGHTING: BOTTOM OF PENDANT LIGHTS MOUNTED AT 36" ABOVE COUNTER SURFACE
	CHANDELIER HEIGHT: BOTTOM OF CHANDELIER MOUNTED AT 7' ABOVE FLOOR. FOR EVERY FOOT OVER 8' CEILINGS, ADD AN ADDITIONAL 3" OF HEIGHT.

ELECTRICAL LEGEND

NAME	ROOM NAME
	RECEPTACLE WALL DUPLEX - 12" A.F.F U.N.O
	RECEPTACLE WALL DUPLEX (ABOVE COUNTERTOPS) - 42" A.F.F U.N.O
C	RECEPTACLE INTEGRATED W/ CABINET DESIGN - SEE CABINET ELEVATIONS FOR EXACT LOCATIONS
F	EQUAL TO DESIGNMOD SMOOTHLINE FLUSH-MOUNT WALL PLATE RECEPTACLE
GR	GFCI RECEPTACLE WALL DUPLEX - 12" AFF U.N.O
	SWITCH
	THREE WAY SWITCH
	FOUR WAY SWITCH
	AUTOMATIC SWITCH
	FLOOR BOX DUPLEX OUTLET
TV	TV + POWER + DATA+CAT 6 - 54" A.F.F.U.N.O.
	INCORPORATE USB/USB-C
	GAS WALL MOUNT FIXTURE

NOTES:
• OUTDOOR OUTLETS OR ADJACENT TO WATER SOURCE SHALL
BE GFCI.
• PROVIDE ADEQUATE AMPERAGE PER EQUIPMENT.
• REFER TO ELECTRICAL CONTRACTOR TO ACHIEVE DESIGN
INTENT IN ACCORDANCE WITH APPLICABLE CODE
REQUIREMENTS



MURPHY MAUDE
INTERIORS

500 Madison unit 107,
Nashville, Tennessee 37208
w: murphymaudeinteriors.com
p: (901) 848-6402
copyright 2021

CLIENT
MR. AND MRS. CLIENT
PROJECT LOCATION
94 CUMBERLAND,
MEMPHIS, TN

PROJECT NAME
PERSONAL RESIDENCE



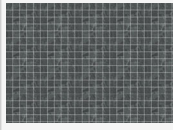
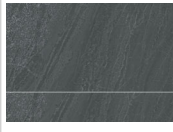
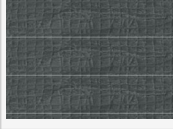
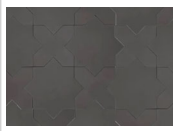



DATE ISSUED
DRAWING SCALE
8/14/2023
As indicated

DRAWING TITLE
SECOND FLOOR
ELECTRICAL PLAN

REVISIONS:
NUMBER DATE DESCRIPTION

SUPPLEMENTAL INTERIOR DESIGN
DOCUMENT
ID205

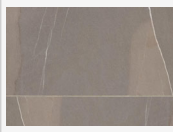FINISH SCHEDULE LEVEL 01					
LEVEL	NAME	CEILING FINISH	WALL FINISH	FLOOR FINISH	COMMENTS
LEVEL 1	BAR	PT-100	ST-100	T-117	
LEVEL 1	CLOSET	PT-100	PT-100	WD-1	
LEVEL 1	COAT ROOM	PT-100	PT-100	WD-1	
LEVEL 1	DINING ROOM	WD-101	PT-100	WD-1	
LEVEL 1	FOYER	WD-100	WD-100	T-117	
LEVEL 1	FRIEND'S ENTRY	PT-100	PT-100	T-117	
LEVEL 1	GALLERY	PT-100	PT-100	T-117	
LEVEL 1	GARAGE	PT-100	PT-100		
LEVEL 1	GATHERING ROOM	PT-100	PT-100	WD-1	
LEVEL 1	HER OFFICE	PT-100	PT-100	WD-1	
LEVEL 1	HIS BATH	PT-102	PT-102	T-105	
LEVEL 1	HIS OFFICE	PT-102	PT-102	WD-1	
LEVEL 1	HIS OFFICE BATH	T-107	T-107, T-106	T-106	
LEVEL 1	HIS OFFICE WC	PT-102	PT-102	T-105	
LEVEL 1	KITCHEN	WD-101	PT-100	WD-1	
LEVEL 1	LIVING ROOM	PT-100	PT-100	WD-1	
LEVEL 1	MASTER BATH	WD-101	PT-100	T-200	
LEVEL 1	MASTER BATH	WD-101	PT-100	T-200	
LEVEL 1	MASTER CLOSET	PT-100	PT-100	WD-1	
LEVEL 1	MASTER ROOM	WD-101	PT-100	WD-1	
LEVEL 1	MASTER SHOWER	T-102	T-102	T-200	
LEVEL 1	OUTDOOR KITCHEN			T-116	
LEVEL 1	OUTDOOR ROOM			T-116	
LEVEL 1	PANTRY	PT-100	PT-100	WD-1	
LEVEL 1	POOL BATH	PT-102	WC-100	T-101	
LEVEL 1	POWDER ROOM	WF-100	WF-100	T-119	
LEVEL 1	SCULLERY	PT-100	PT-100	WD-1	
LEVEL 1	STAIR HALL	PT-100	PT-100	T-117	
LEVEL 1	STORAGE	PT-100	PT-100	T-117	
LEVEL 1	STORAGE	PT-100	PT-100	WD-1	
LEVEL 1	UTILITY	PT-100	PT-100	T-117	

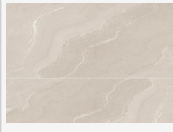TILE SCHEDULE LEVEL 01								
TYPE MARK	ROOM	LOCATION	MANUFACTOR	NAME	FINISH / SIZE	GROUT	IMAGE	LEVEL
T-101	Pool Bath	FLOOR	Emil Ceramica	Plase	Spazzolata, 60 x 120 cm	G-103		LEVEL 1
T-105	His Office	FLOOR	MIR Mosaics	JUMANJI	JUMANJI BLACK 12X25	G-100		LEVEL 1
T-106	His Office	SHOWER FLOOR	MIR Mosaics	JUMANJI	BLACK MOSAIC	G-100		LEVEL 1
T-107	His Office	SHOWER WALLS	MIR Mosaics	JUMANJI	BLACK 24X48	G-100		LEVEL 1
T-108	His Office	ACCENT SHOWER WALLS	MIR Mosaics	JUMANJI	BLACK TEXTURES DECO	G-100		LEVEL 1
T-116	Outdoor	FLOOR	Contact Client for Specifications	Outdoor Floor	Outdoor Floor	G-100		LEVEL 1
T-117	First Floor	FLOOR	Contact Client for Specifications	Main First Floor Tile	Main First Floor Tile	G-100		LEVEL 1
T-119	Powder Room	FLOOR	Zia Tile	Stars and Cross	Ash	G-102		LEVEL 1
T-200	Master Bathroom	FLOOR, SHOWER FLOOR	Cosentino	Dekton	Morpheus, 327 x 147 cm, 0.8 cm	G-100		LEVEL 1
T-201	Master Bathroom	SHOWER WALLS, VANITY WALLS	Cosentino	Dekton	Morpheus 327 x 147 cm, 0.8 cm	G-100		LEVEL 1
T-202	Scullery	BACKSPLASH	Emil Group	Ergon, Stone Talk, Martellata	Sand Martellata, 60 x 120 cm, 9.5 mm	G-101		LEVEL 1

FINISH LEGEND

WOOD

WOOD FLOORING. WOOD FLOORS RUN LENGTH OF ROOM UNLESS NOTED OTHERWISE.

- WD-100**WHITE OAK STAINED EQUAL TO SW 3005, NAVAJO WHITE
- WD-101**WHITE OAK STAINED EQUAL TO SW 3540, MOUNTAIN ASH
- WD-102**WHITE OAK STAINED EQUAL TO SW 3531, BLUE SHADOW
- WD-103**7" RIFT CUT WHITE OAK. STAIN SAMPLE PROVIDED BY DESIGNER.
- WD-104**7" RIFT CUT WHITE OAK, LAID IN HERRINGBONE PATTERN. STAIN SAMPLE PROVIDED BY DESIGNER.

STONE VENEER

- ST-100**EQUAL TO COBBLE STONE VENEER

PAINT

- PT-100**BENJAMIN MOORE, OC-45, SWISS COFFEE
- PT-101**BENJAMIN MOORE, 2126-20, RACCOON FUR
- PT-102**SHERWIN WILLIAMS, 7069, IRON ORE

GROUT

- G-100**EQUAL TO MAPEI 10 BLACK
- G-101**EQUAL TO MAPEI 02 PEWTER
- G-102**EQUAL TO MAPEI 47 CHARCOAL
- G-103**EQUAL TO MAPEI 09 GRAY
- G-104**EQUAL TO MAPEI 01 ALABASTER
- G-105**EQUAL TO MAPEI 93 WARM GRAY
- G-106**EQUAL TO MAPEI 103 COBBLESTONE
- G-107**EQUAL TO MAPEI 39 IVORY

 
ADDITIONAL FINISHES

- WF-100**SW IRON ORE PLASTER FINISH
- WF-101**PLASTER FINISH

PAINT+WALLCOVERING LEGEND

- NAME

ROOM NAME

FINISH TYPE. LEADERS SHOW EXTENTS OF FINISH
- PAINT COLORS:

01

WALLS/TRIM: ALL WALLS AND TRIM ARE BENJAMIN MOORE OC-45 SWISS COFFEE

02

DOORS/WINDOWS: SW 7069 IRON ORE

CEILINGS: 50% OF THE WALL/TRIM COLOR.
- PAINT FINISHES:

TRIM AND DOORS/WINDOWS: SATIN

WALLS: EGGSHELL

CEILINGS: FLAT
- WALLCOVERING:

01

WC-1

CLIENT PROVIDED



MURPHY MAUDE

INTERIORS

500 Madison unit 107,
Nashville, Tennessee 37208

w: murphymaudeinteriors.com

p: (901) 848-6402

copyright 2021

CLIENT
MR. AND MRS. CLIENT

PROJECT LOCATION
94 CUMBERLAND,
MEMPHIS, TN

PROJECT NAME
PERSONAL RESIDENCE

DATE ISSUED
DRAWING SCALE


8/14/2023
As indicated

DRAWING TITLE
FIRST FLOOR FINISH PLAN

REVISIONS:

NUMBER	DATE	DESCRIPTION
--------	------	-------------

SUPPLEMENTAL INTERIOR DESIGN DOCUMENT
ID301

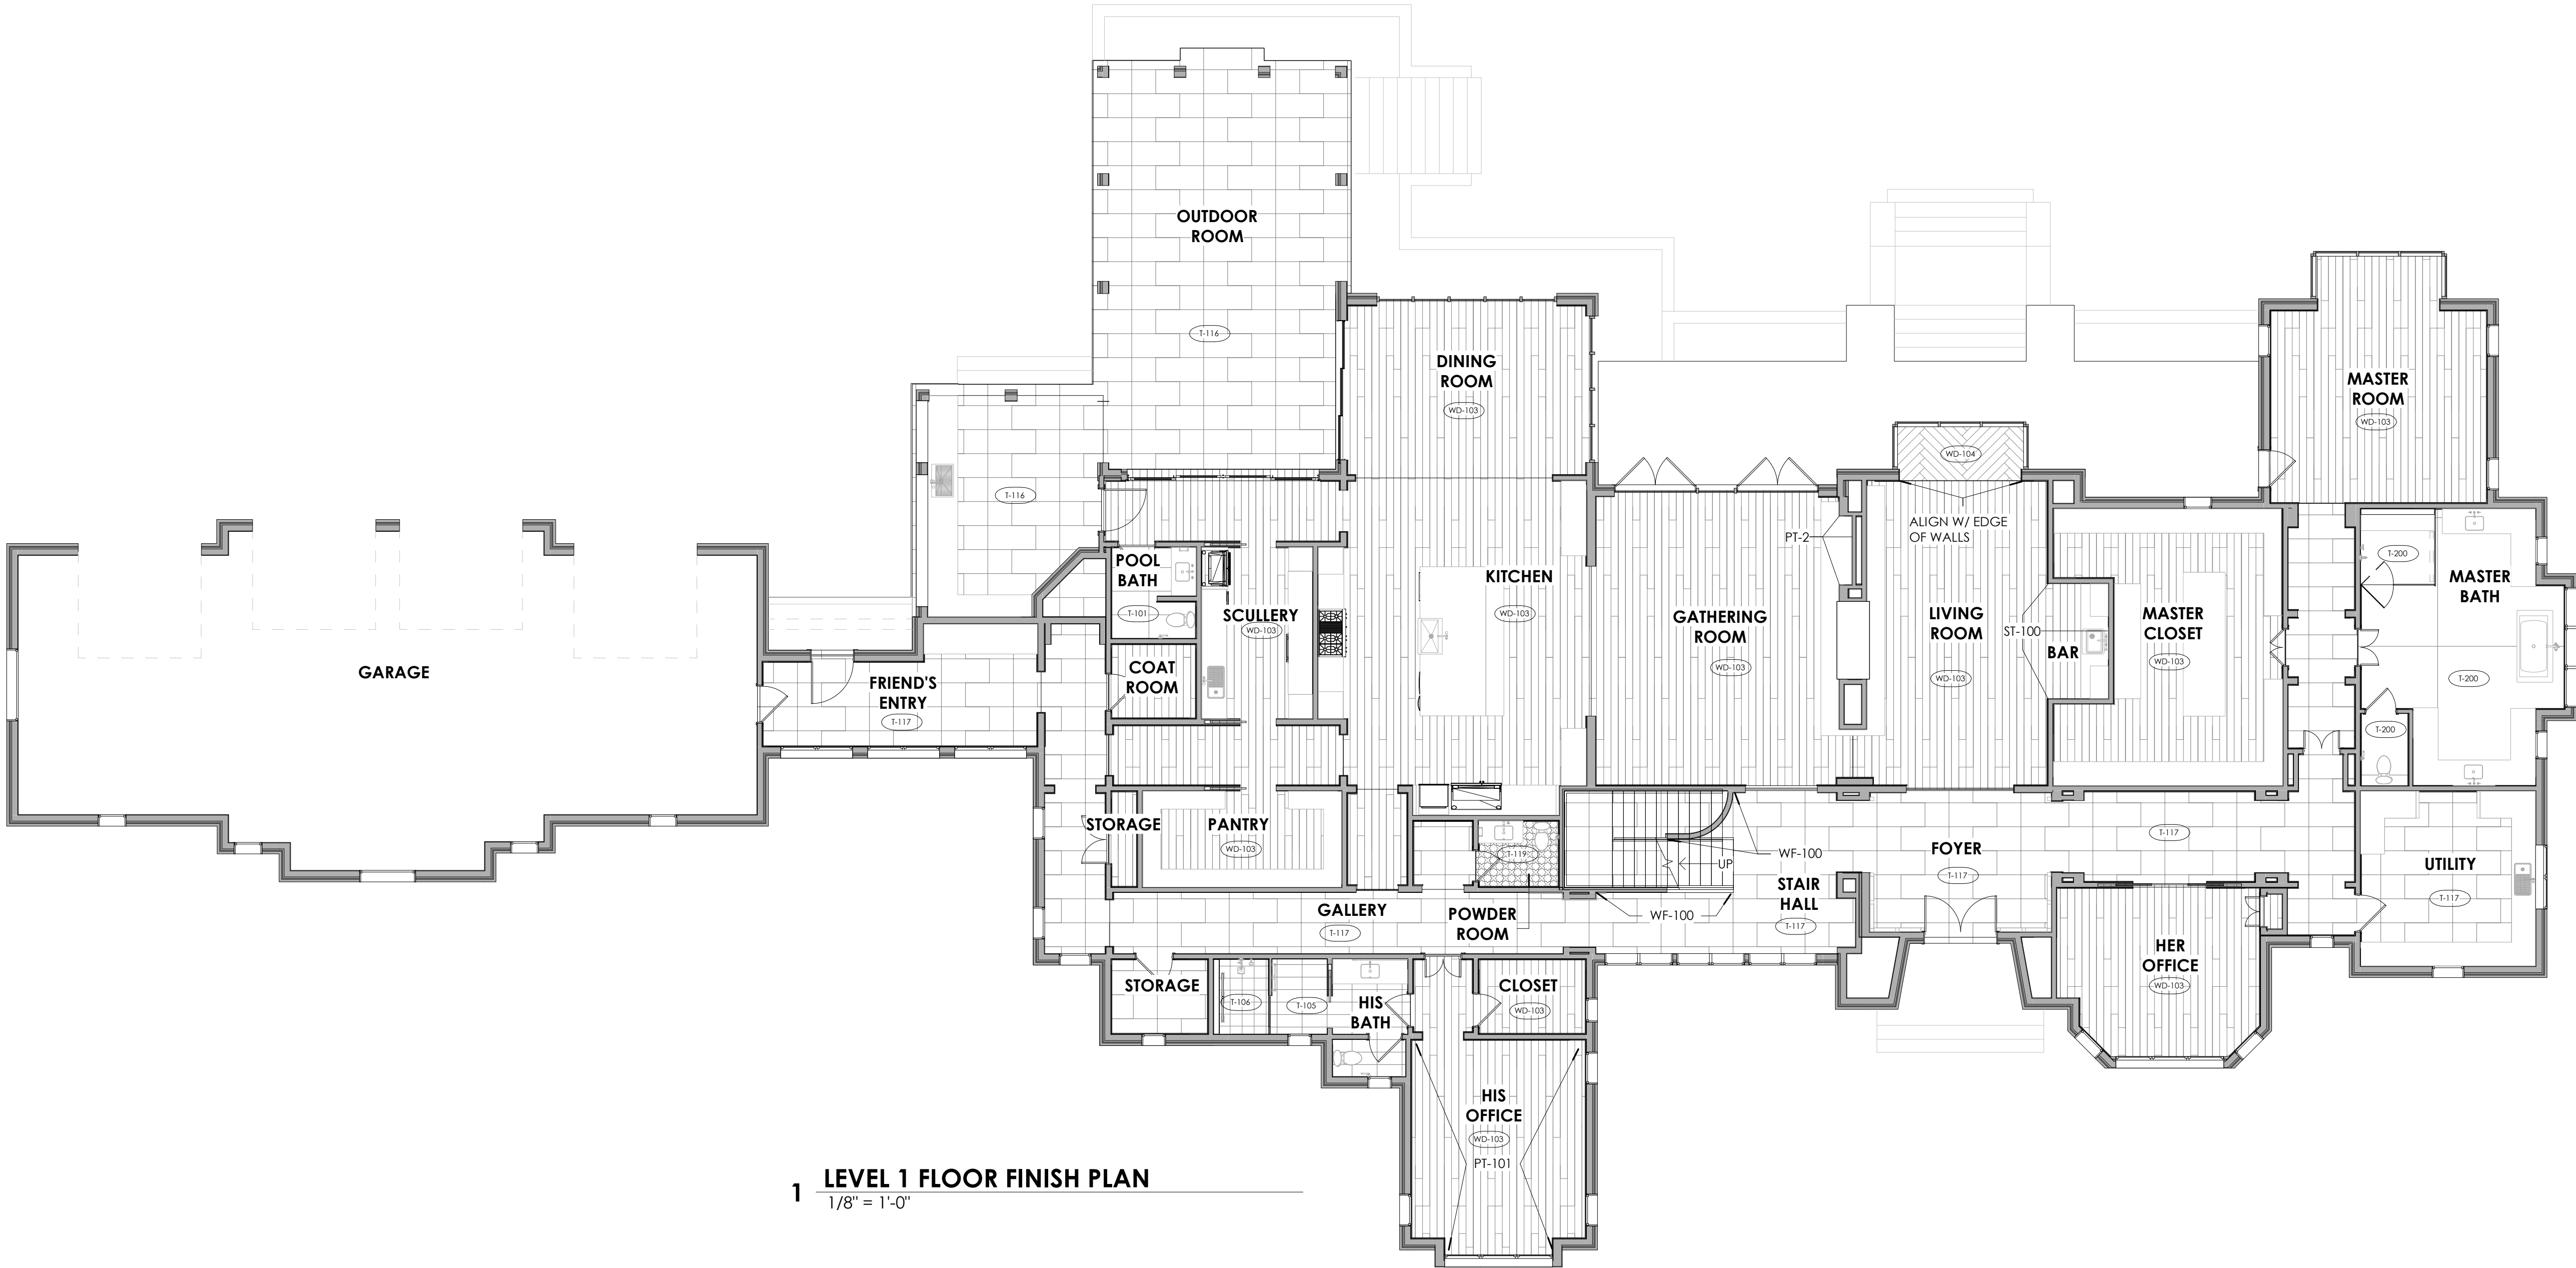

1 LEVEL 1 FLOOR FINISH PLAN
1/8" = 1'-0"

FINISH SCHEDULE LEVEL 02					
LEVEL	NAME	CEILING FINISH	WALL FINISH	FLOOR FINISH	COMMENTS
LEVEL 2	GUEST ROOM	PT-100	PT-100	WD-1	
LEVEL 2	GUEST BATH	PT-100	PT-100, T-114	T-102	
LEVEL 2	ATTIC STORAGE		PT-100	WD-1	
LEVEL 2	CLOSET	PT-100	PT-100	WD-1	
LEVEL 2	GUEST BATH 3	PT-100	PT-100, T-110	T-300	
LEVEL 2	CLOSET	PT-100	PT-100	WD-1	
LEVEL 2	GUEST ROOM 3	PT-100	PT-100	WD-1	
LEVEL 2	EXERCISE ROOM	PT-100	PT-100	WD-1	
LEVEL 2	GUEST ROOM 2	PT-100	PT-100	WD-1	
LEVEL 2	GUEST BATH 2	PT-100	T-115	T-113	
LEVEL 2	CLOSET	PT-100	PT-100	T-15	
LEVEL 2	UTILITY	PT-100	PT-100	T-17	
LEVEL 2	GUEST BATH 3 SHOWER	T-111	T-110, T-111	T-109	
LEVEL 2	GUEST BATH 2 SHOWER	T-115	T-115	T-113	
LEVEL 2	GUEST BATH 2 WC	PT-100	PT-100	T-113	
LEVEL 2	GUEST BATH 3 WC	PT-100	PT-100	T-300	
LEVEL 2	GUEST BATH WATER CLOSET	PT-100	PT-100	T-102	

TILE SCHEDULE LEVEL 02								
TYPE MARK	ROOM	LOCATION	MANUFACTOR	NAME	FINISH / SIZE	GROUT	IMAG E	LEVEL
T-102	Guest Bath	FLOOR	Emil Group	Grain Stone, Ergon	Rough Grain - White, 60 x 120 cm	G-104		LEVEL 2
T-109	Guest Bath 3	SHOWER FLOOR	Emil Group	Grain Stone, Ergon	SAND MOSAICO 3X3	G-104		LEVEL 2
T-110	Guest Bath 3	ACCENT SHOWER WALL, VANITY WALLS	MIR Mosaics	ATLANTIS	WHITE DECO	G-106		LEVEL 2
T-111	Guest Bath 3	SHOWER WALLS	MIR Mosaics	ATLANTIS	WHITE 12x40	G-105		LEVEL 2
T-113	Guest Bath 2	FLOOR	Tile Bar	Cobblestone	Obsidian Black Pebble Polished	G-100		LEVEL 2
T-114	Guest Bath	SHOWER WALLS	Emil Group	Salt Stone by Provenza	Grey Ash Naturale, 60 x 120 cm	G-104		LEVEL 2
T-115	Guest Bath 2	SHOWER WALLS	Atlas Concarde	Enfice	Ash Oak Elegant, Matte, 18.5 cm x 150 cm	G-107		LEVEL 2
T-203	Guest Bath 2	ACCENT SHOWER WALL, VANITY WALLS	Tile Bar	Kenridge	Ribbon Black 24x48	G-100		LEVEL 2

FINISH LEGEND

WOOD

WOOD FLOORING. WOOD FLOORS RUN LENGTH OF ROOM UNLESS NOTED OTHERWISE.

WD-100 WHITE OAK STAINED EQUAL TO SW 3005, NAVAJO WHITE

WD-101 WHITE OAK STAINED EQUAL TO SW 3540, MOUNTAIN ASH

WD-102 WHITE OAK STAINED EQUAL TO SW 3531, BLUE SHADOW

WD-103 7" RIFT CUT WHITE OAK. STAIN SAMPLE PROVIDED BY DESIGNER.

WD-104 7" RIFT CUT WHITE OAK, LAID IN HERRINGBONE PATTERN. STAIN SAMPLE PROVIDED BY DESIGNER.

STONE VENEER

ST-100 EQUAL TO COBBLE STONE VENEER

PAINT

PT-100 BENJAMIN MOORE, OC-45, SWISS COFFEE

PT-101 BENJAMIN MOORE, 2126-20, RACCOON FUR

PT-102 SHERWIN WILLIAMS, 7069, IRON ORE


GROUT

G-100 EQUAL TO MAPEI 10 BLACK
G-101 EQUAL TO MAPEI 02 PEWTER
G-102 EQUAL TO MAPEI 47 CHARCOAL
G-103 EQUAL TO MAPEI 09 GRAY
G-104 EQUAL TO MAPEI 01 ALABASTER
G-105 EQUAL TO MAPEI 93 WARM GRAY
G-106 EQUAL TO MAPEI 103 COBBLESTONE
G-107 EQUAL TO MAPEI 39 IVORY

ADDITIONAL FINISHES

WF-100 SW IRON ORE PLASTER FINISH

WF-101 PLASTER FINISH

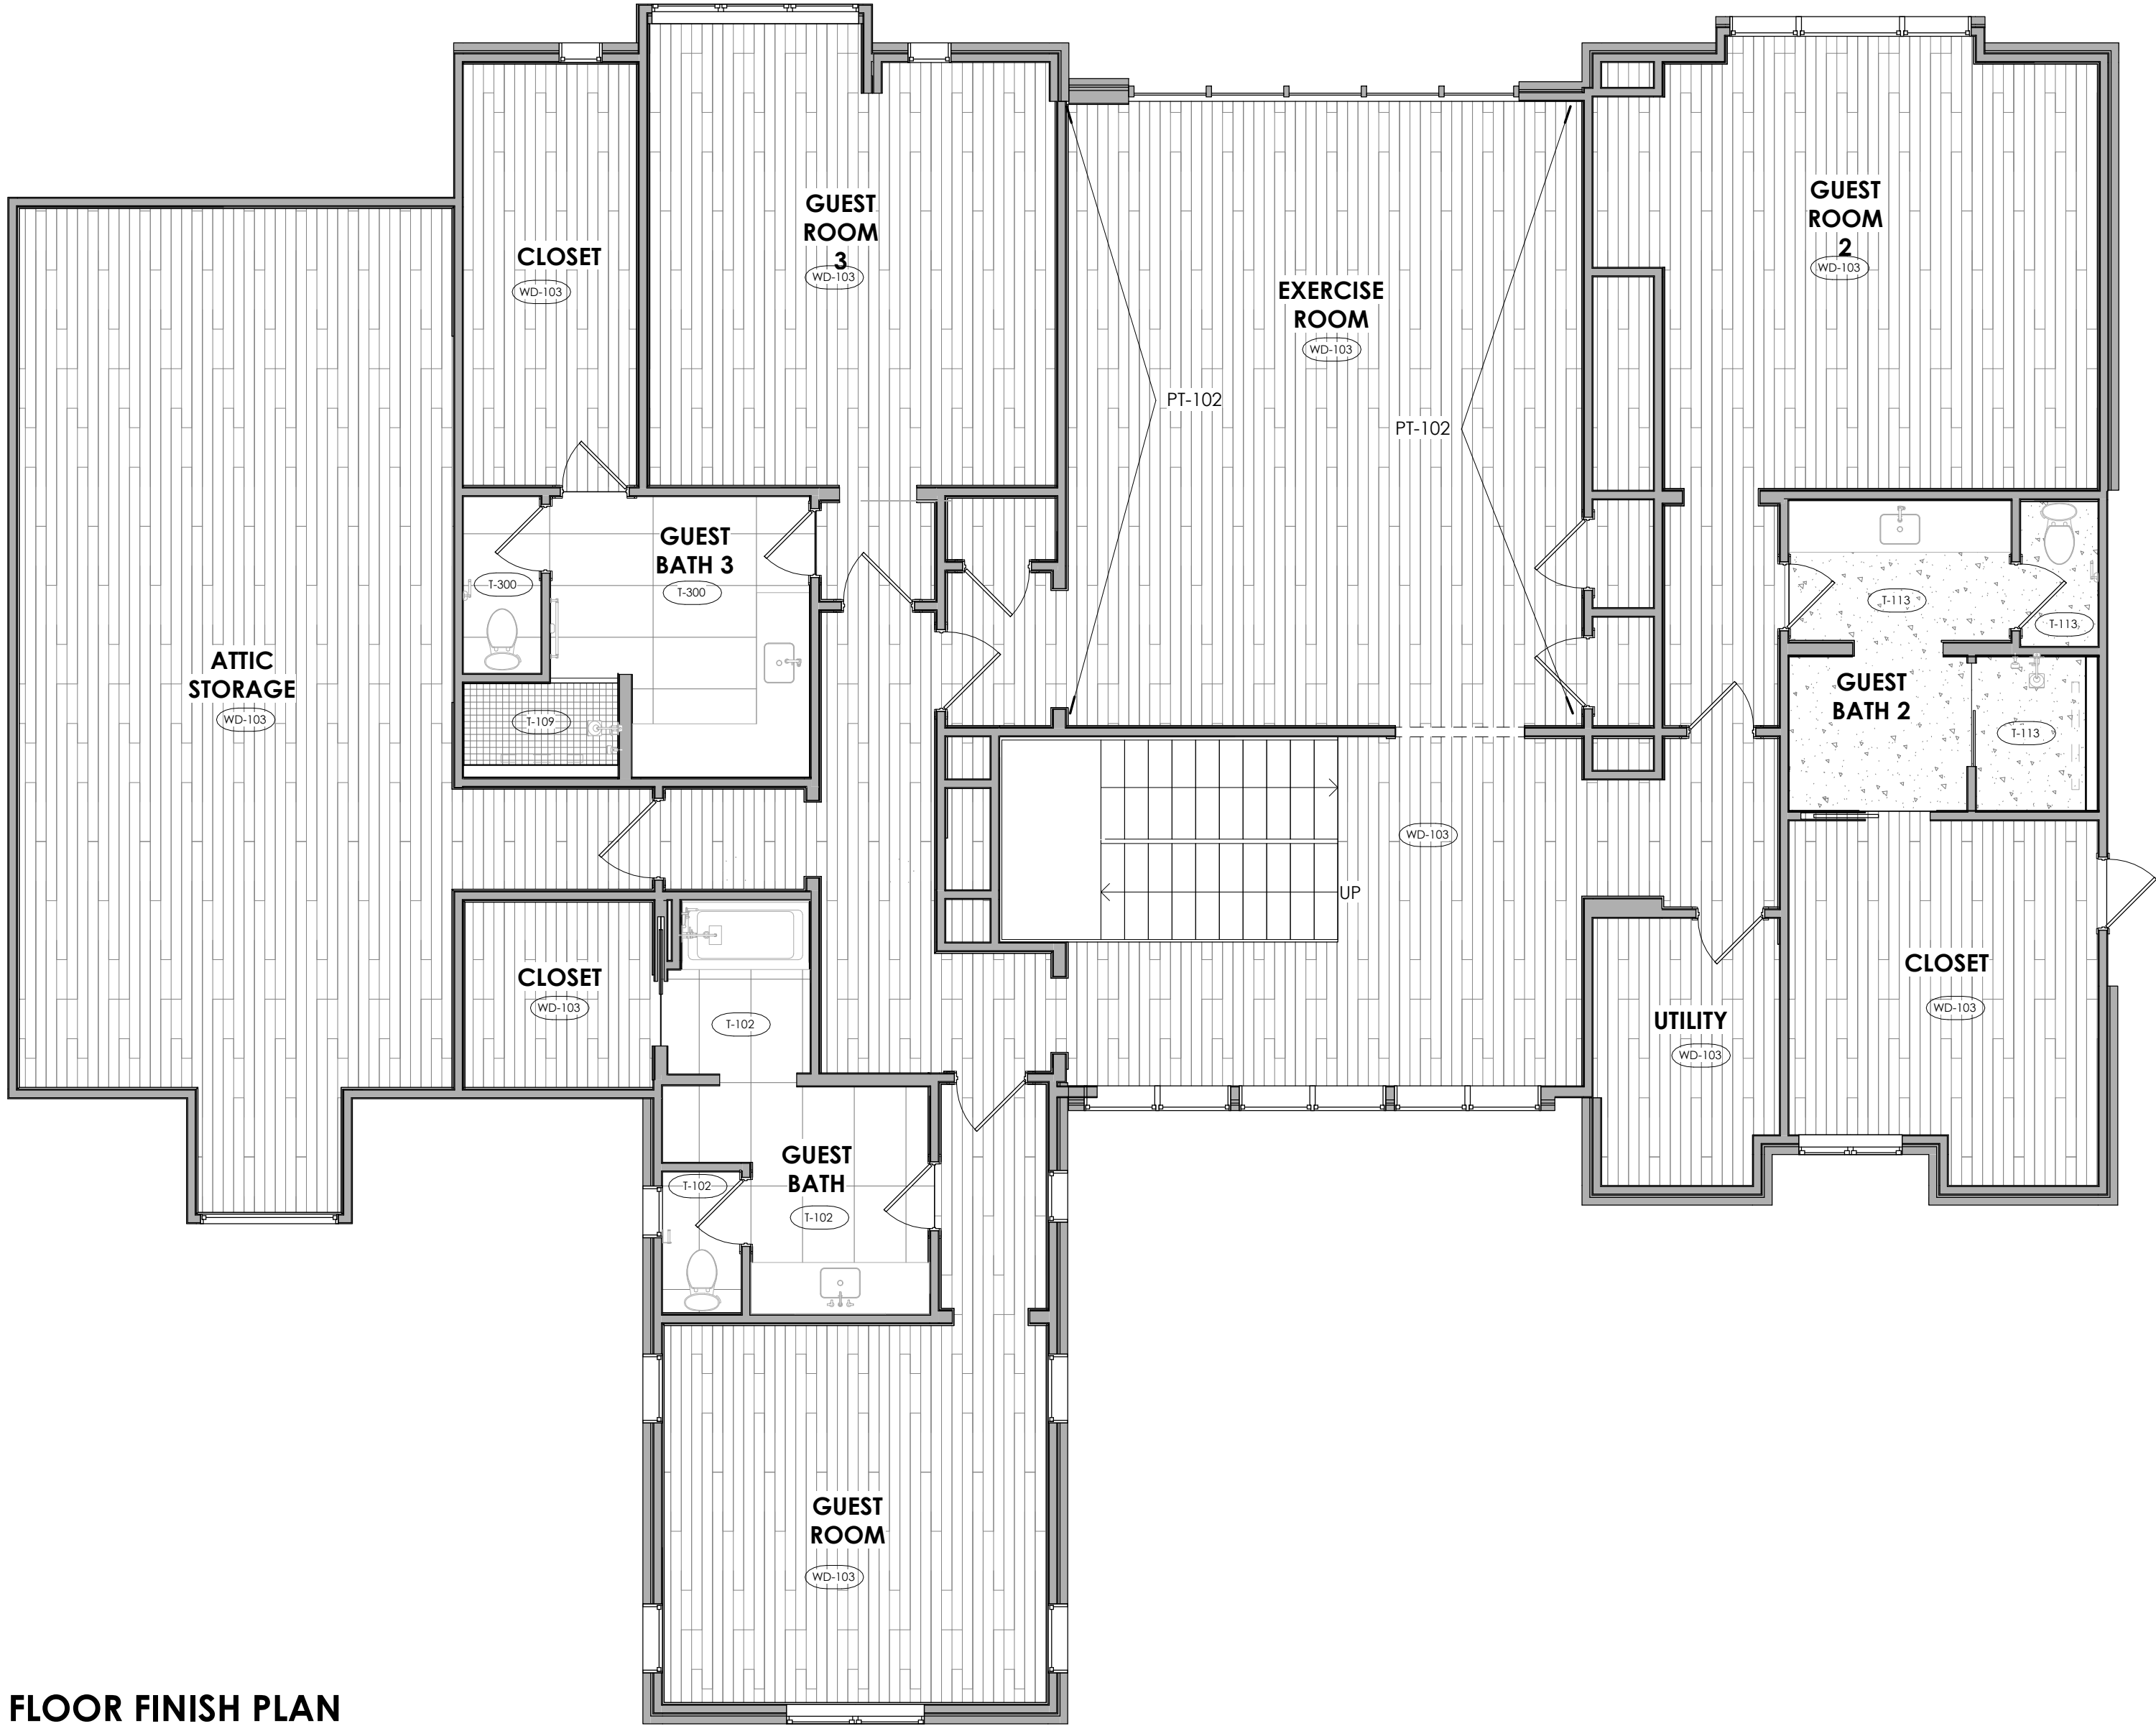

PAINT+WALLCOVERING LEGEND

NAME	ROOM NAME
#	FINISH TYPE. LEADERS SHOW EXTENTS OF FINISH

PAINT COLORS:
01 WALLS/TRIM: ALL WALLS AND TRIM ARE BENJAMIN MOORE OC-45 SWISS COFFEE
02 DOORS/WINDOWS: SW 7069 IRON ORE

CEILINGS: 50% OF THE WALL/TRIM COLOR.

PAINT FINISHES:
TRIM AND DOORS/WINDOWS: SATIN
WALLS: EGGSHELL
CEILINGS: FLAT

WALLCOVERING:
01 WC-1 CLIENT PROVIDED



MURPHY MAUDE
INTERIORS

500 Madison unit 107,
Nashville, Tennessee 37208
w: murphymaudeinteriors.com
p: (901) 848-6402
copyright 2021

CLIENT
MR. AND MRS. CLIENT
PROJECT LOCATION
94 CUMBERLAND,
MEMPHIS, TN

PROJECT NAME
PERSONAL RESIDENCE


DATE ISSUED 8/14/2023
DRAWING SCALE As indicated

DRAWING TITLE
SECOND FLOOR FINISH
PLAN


REVISIONS:
NUMBER DATE DESCRIPTION

SUPPLEMENTAL INTERIOR DESIGN
DOCUMENT
ID302


1 LEVEL 2 FLOOR FINISH PLAN
3/16" = 1'-0"

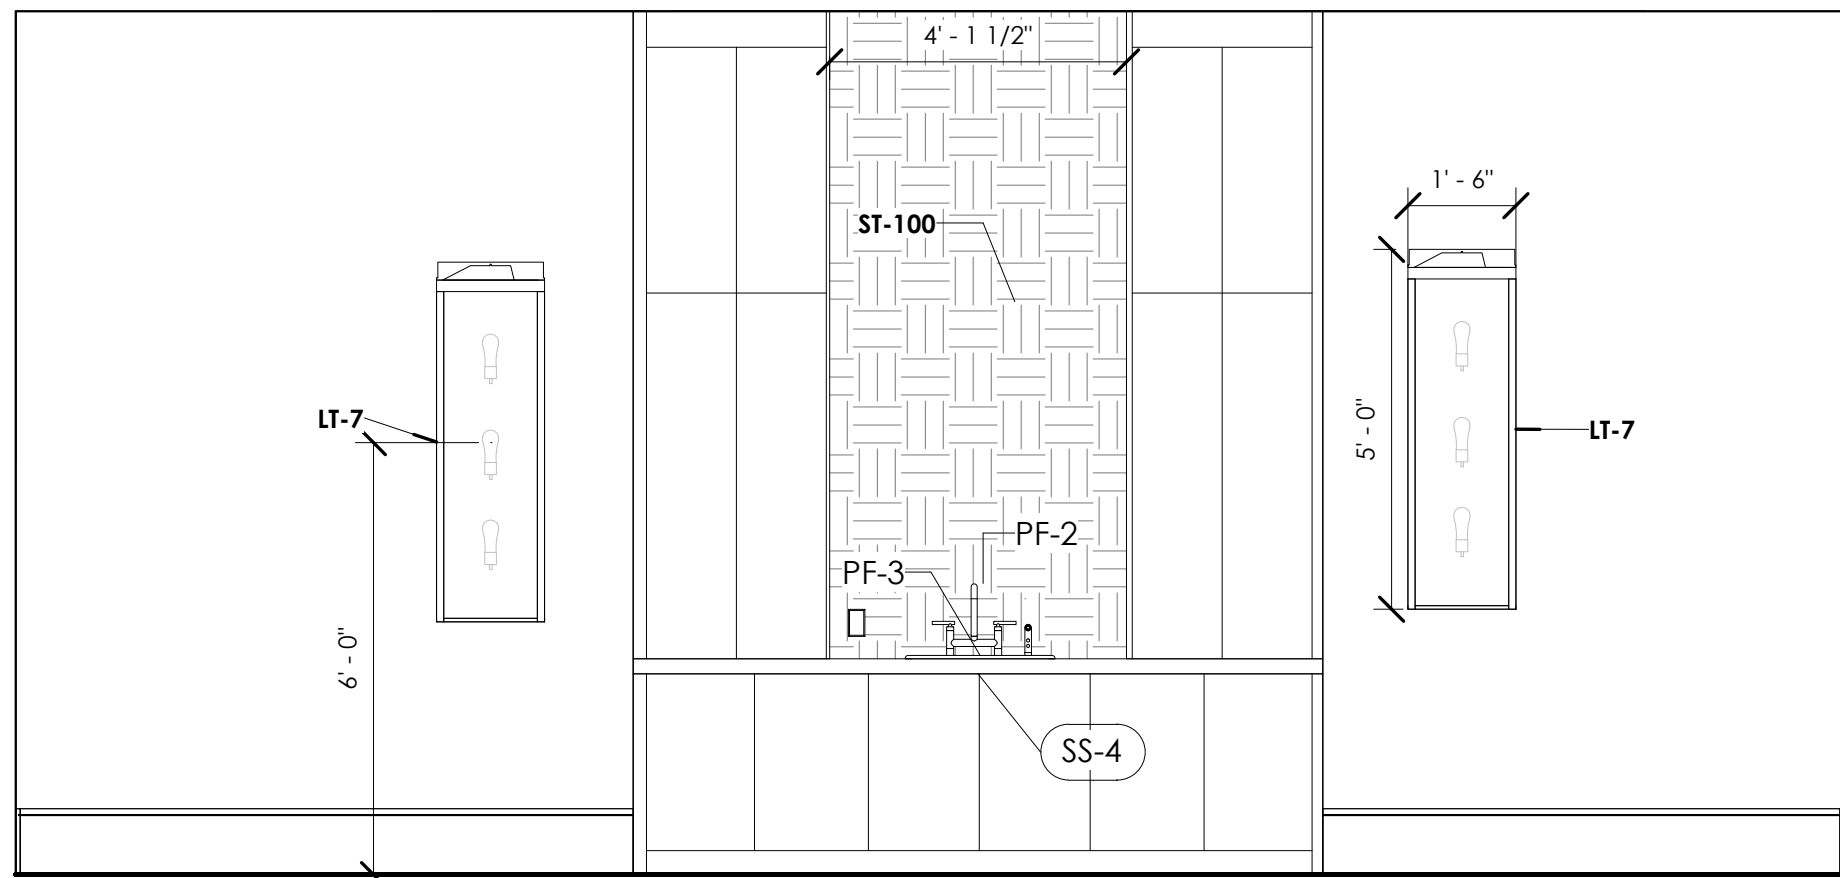


1 WET BAR
3/8" = 1'-0"

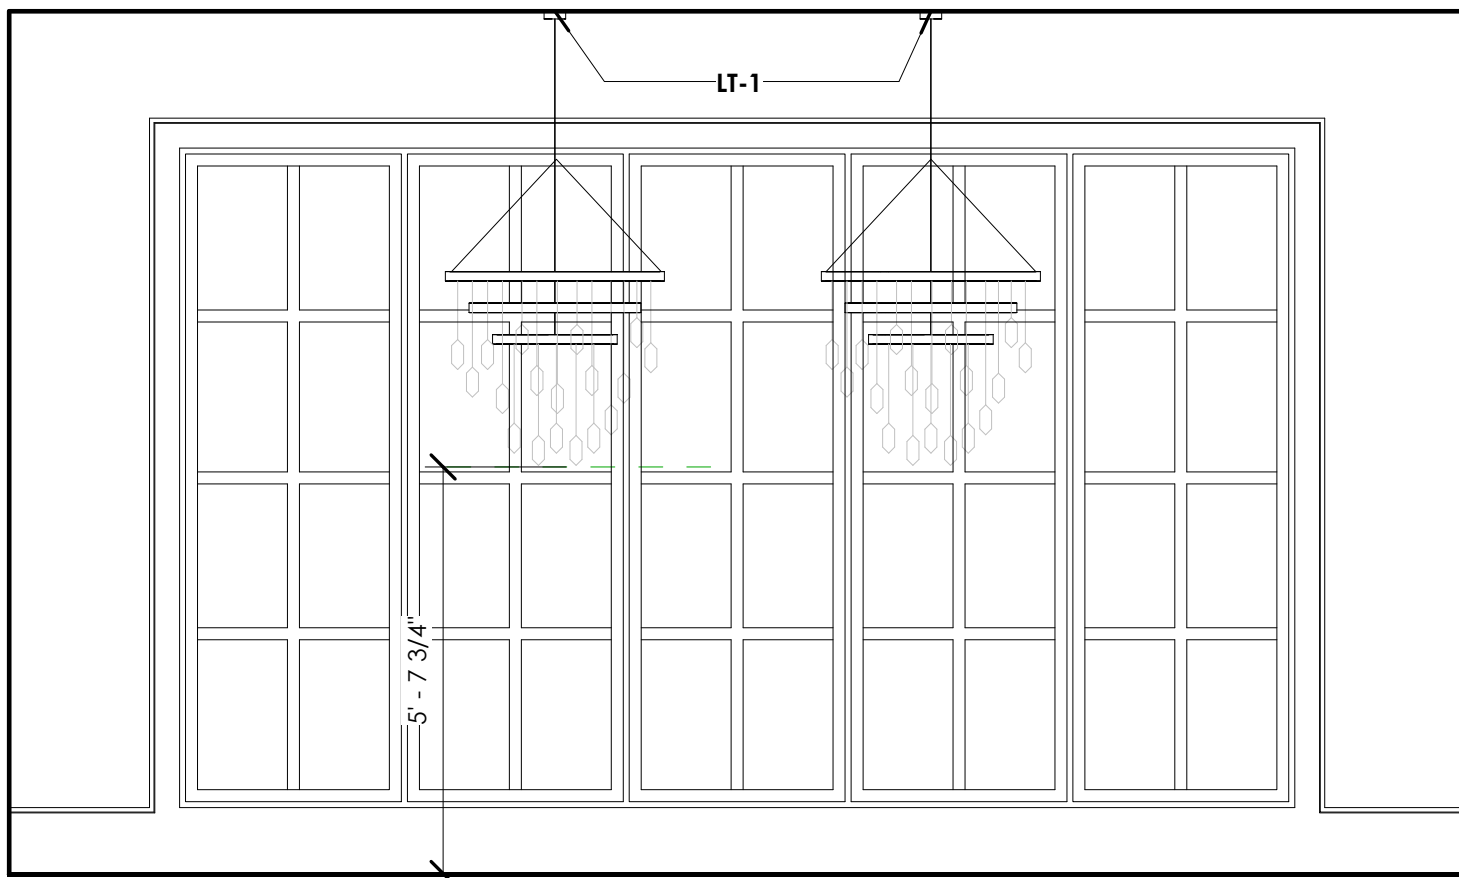


2 DINING ROOM B
3/8" = 1'-0"

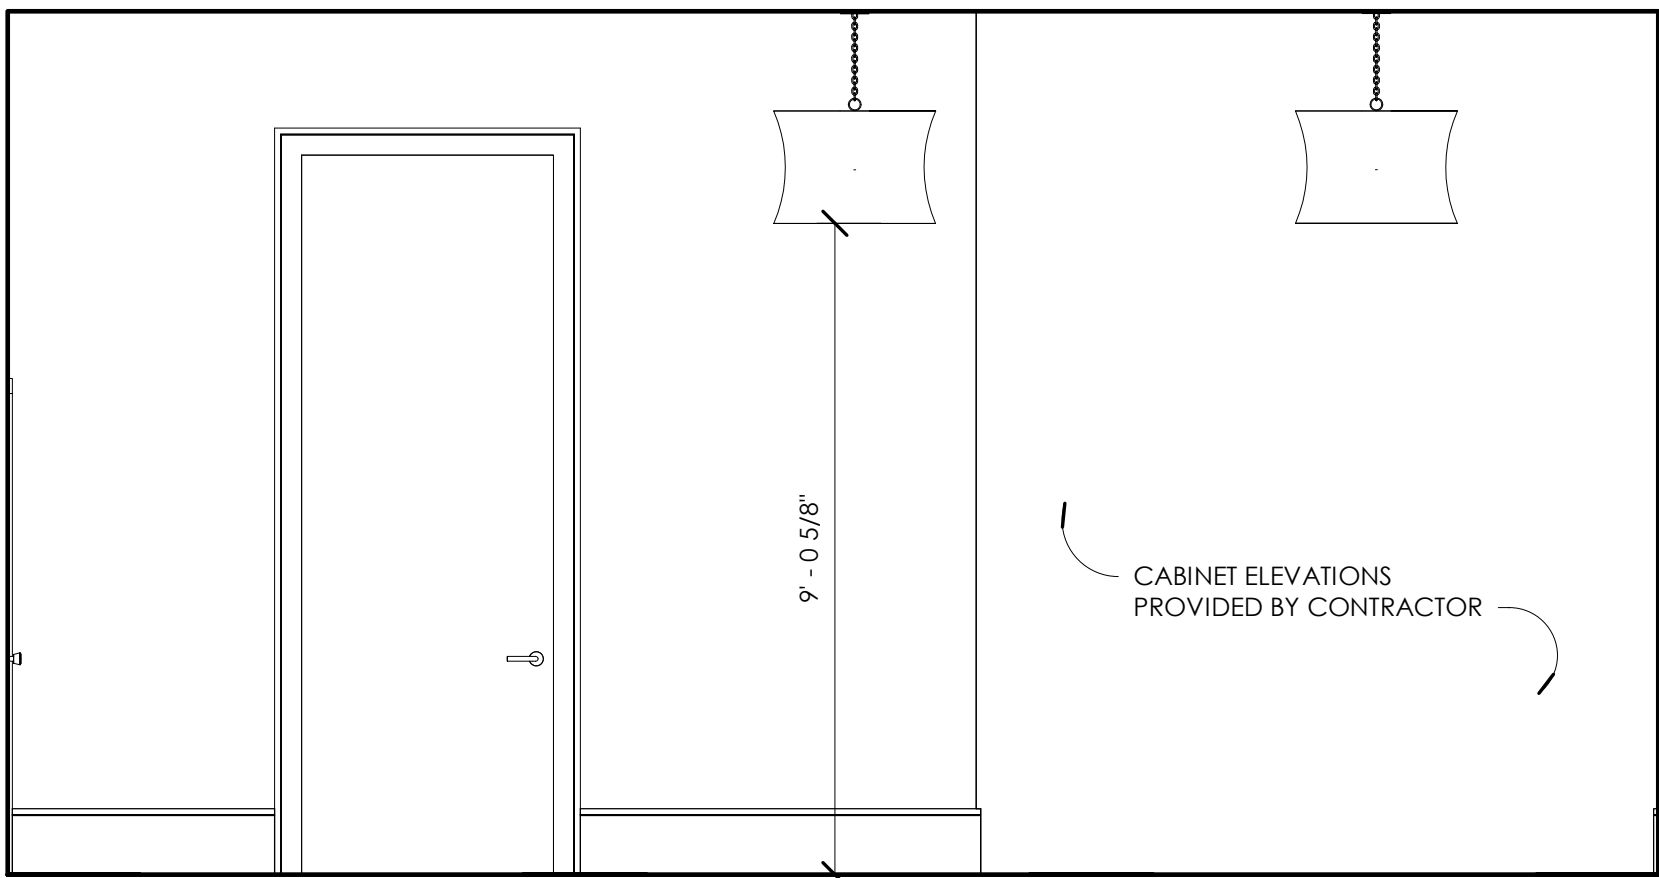


3 FRIEND'S ENTRY
3/8" = 1'-0"

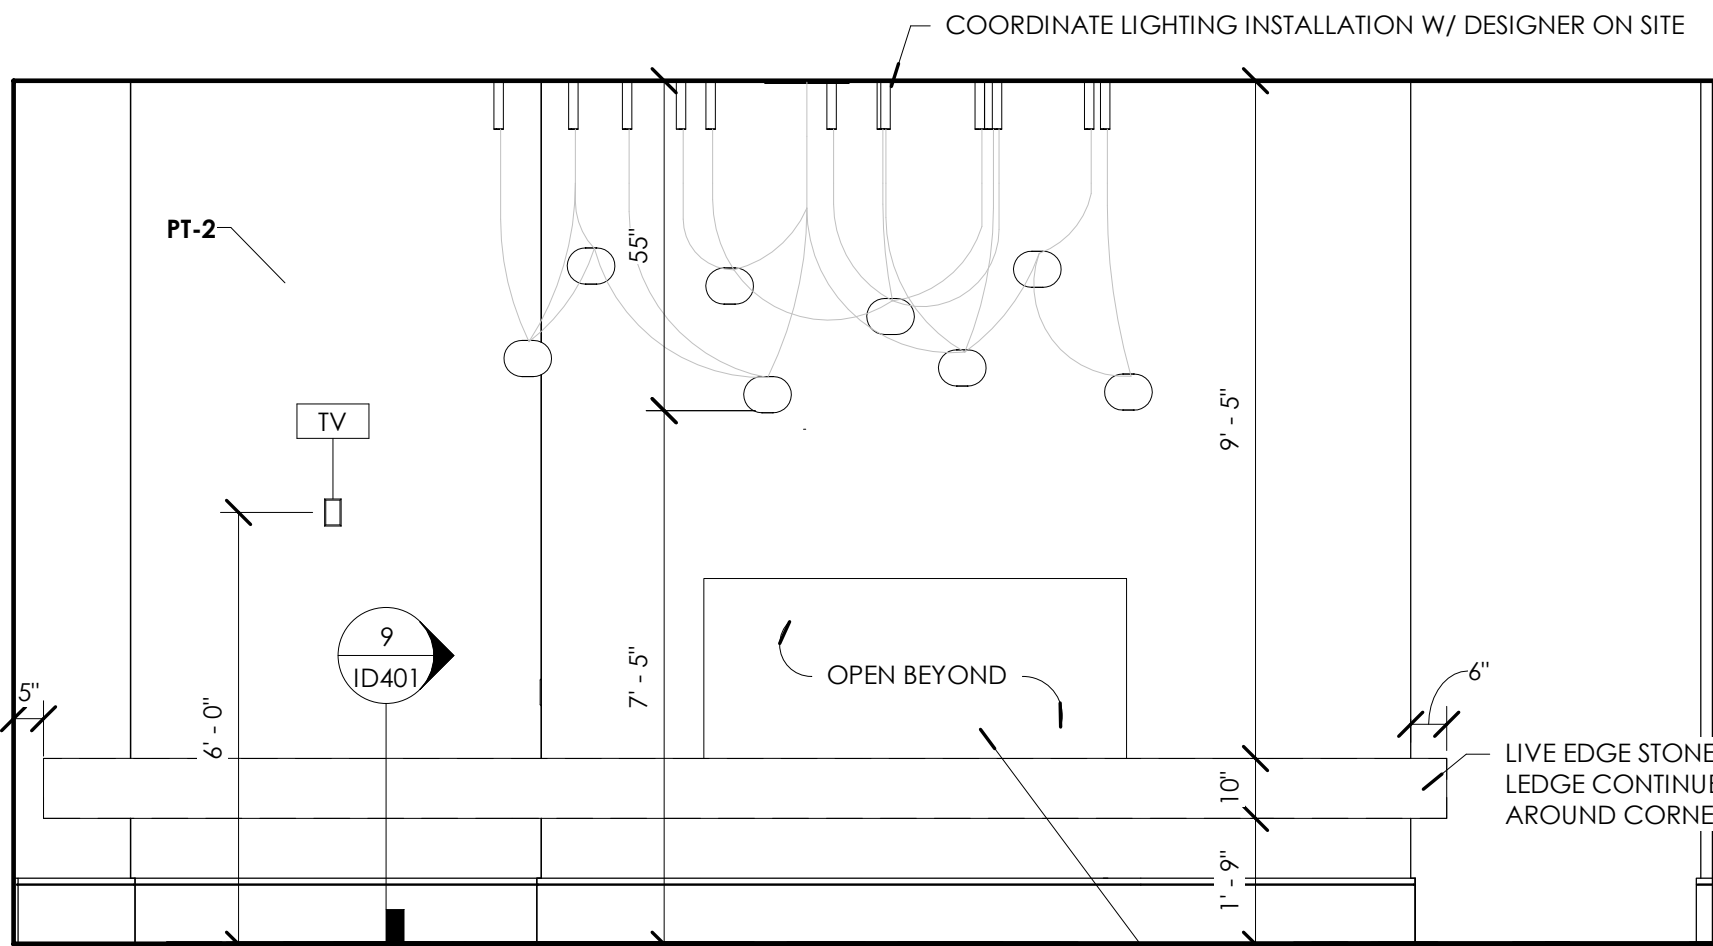


4 FIREPLACE B
3/8" = 1'-0"

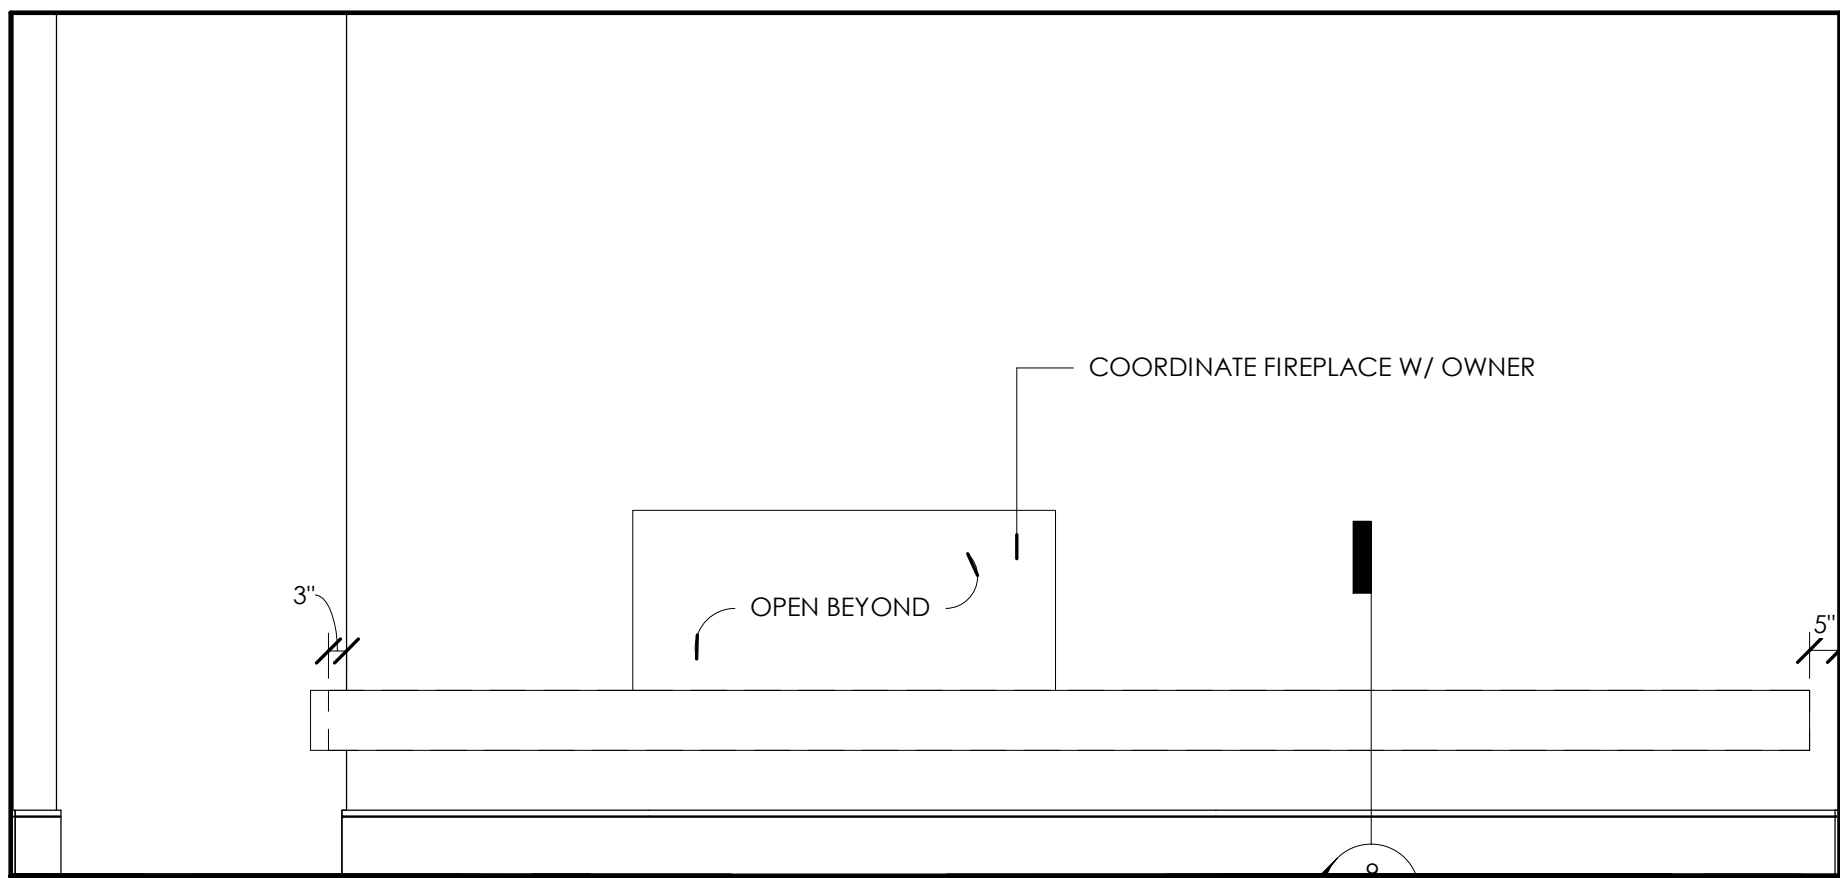


5 FIREPLACE A
3/8" = 1'-0"

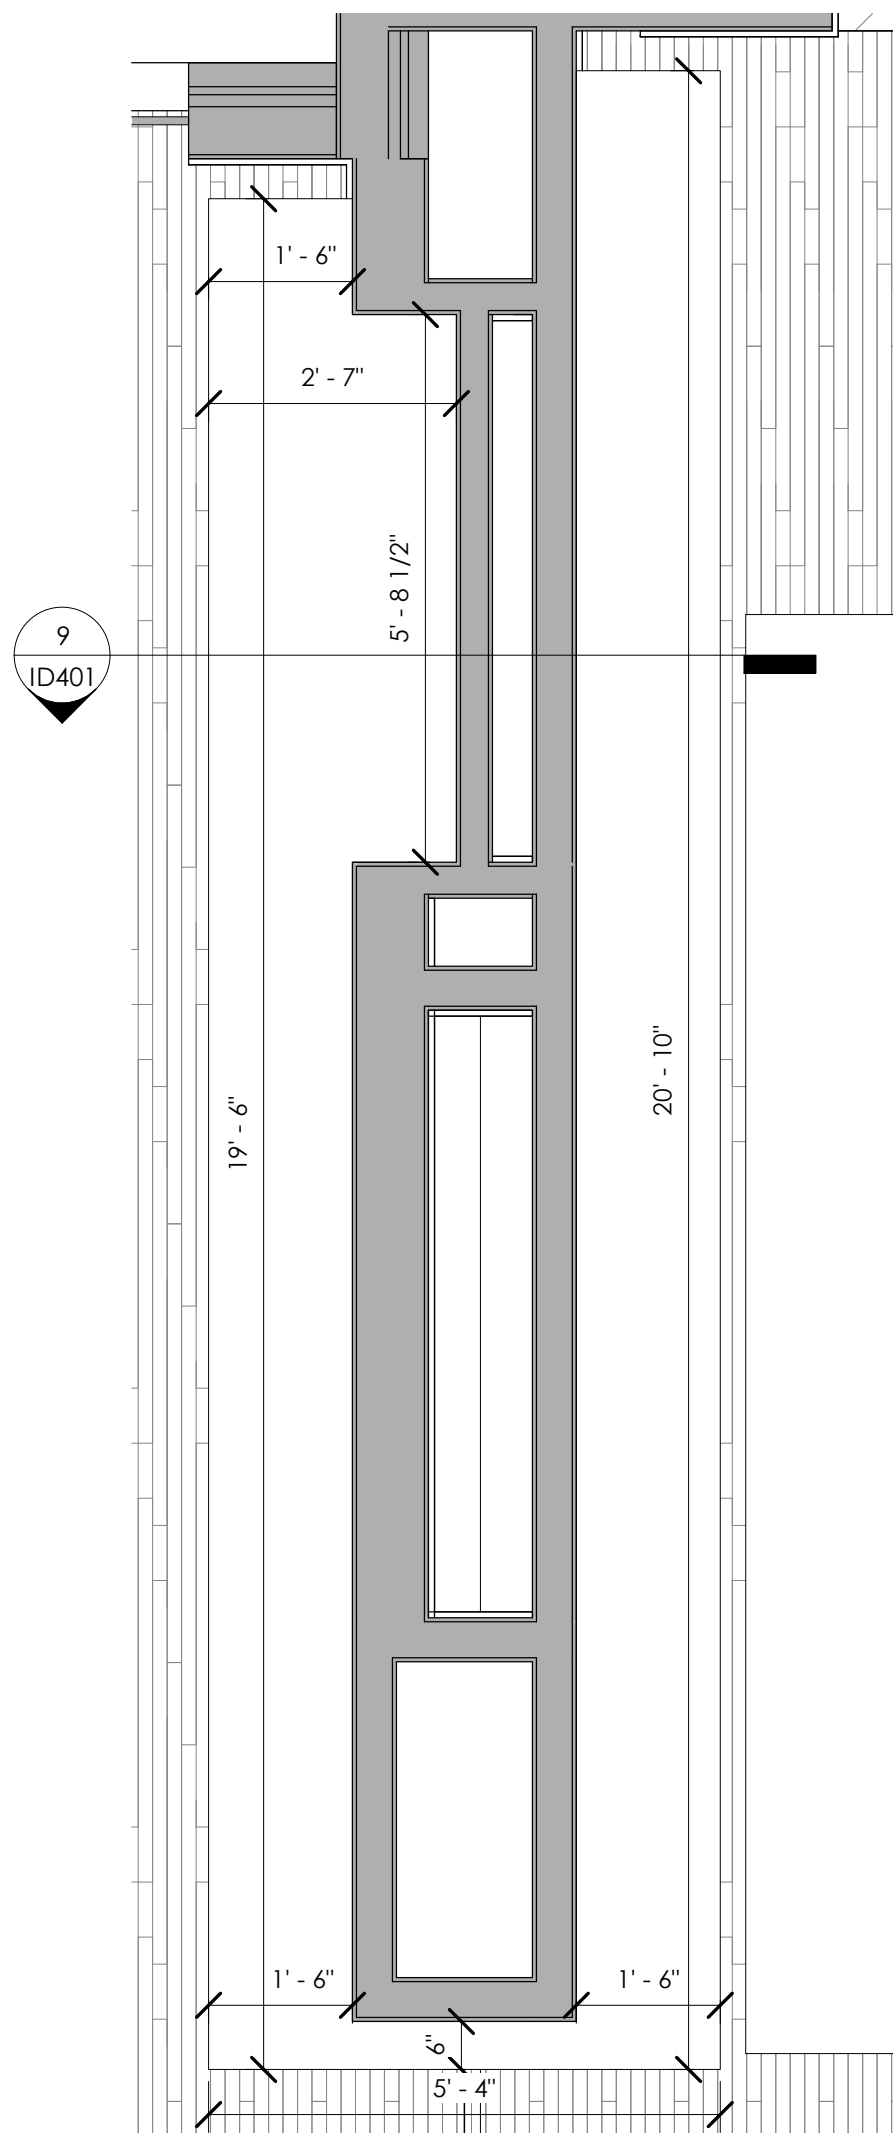

8 FIREPLACE LIVE EDGE
1/2" = 1'-0"

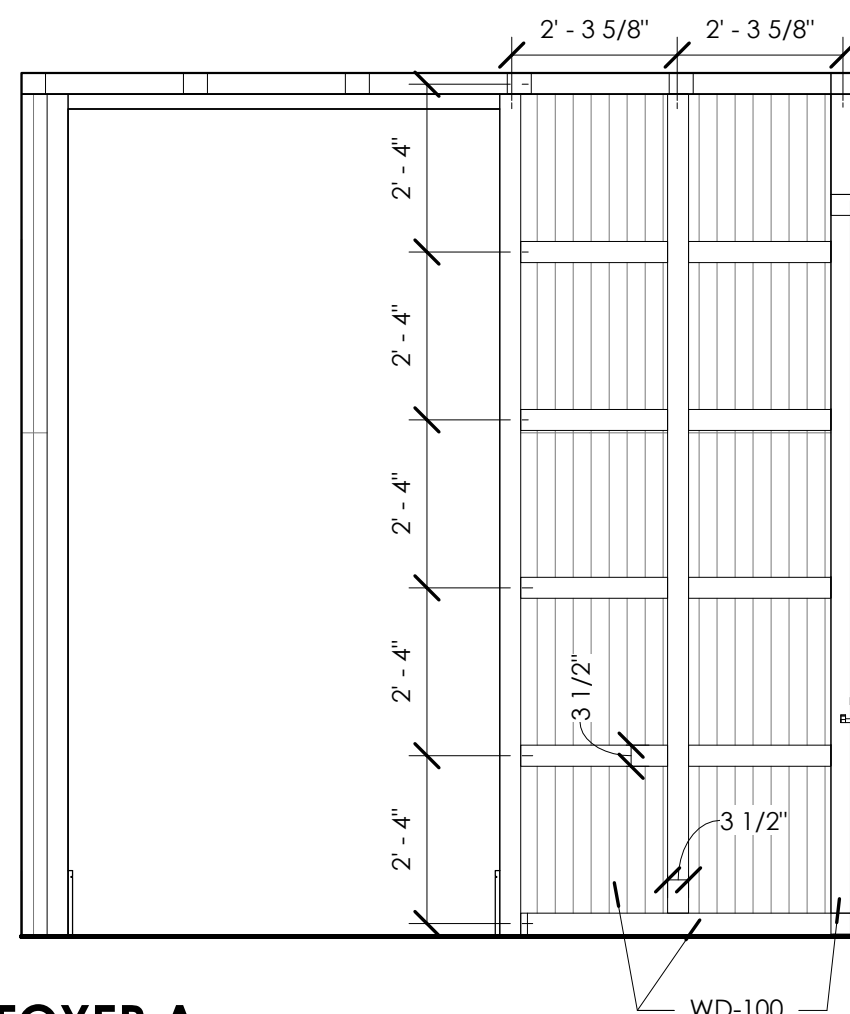


6 FOYER A
3/8" = 1'-0"

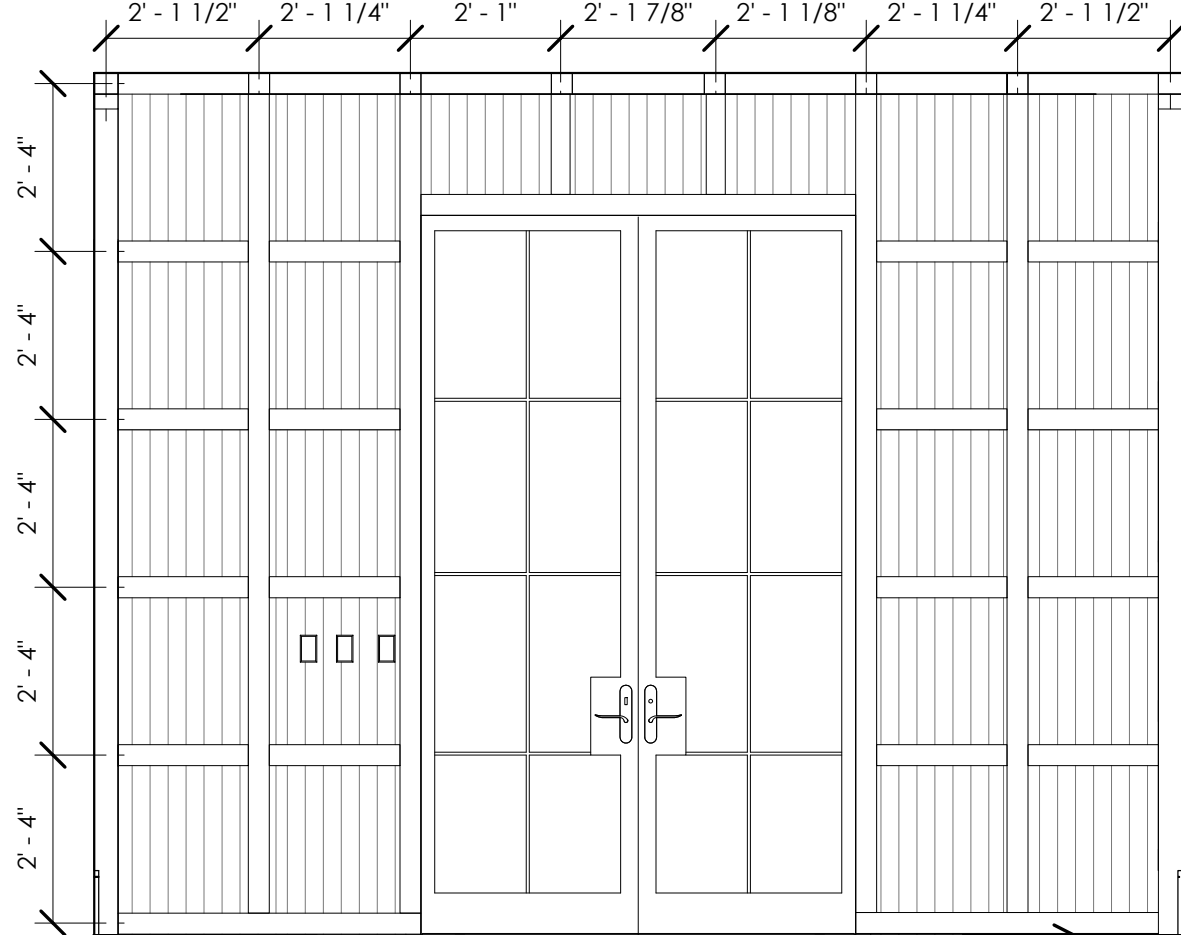

7 FOYER B
3/8" = 1'-0"



INSPIRATION IMAGE FOR FOYER DETAILED WALLS

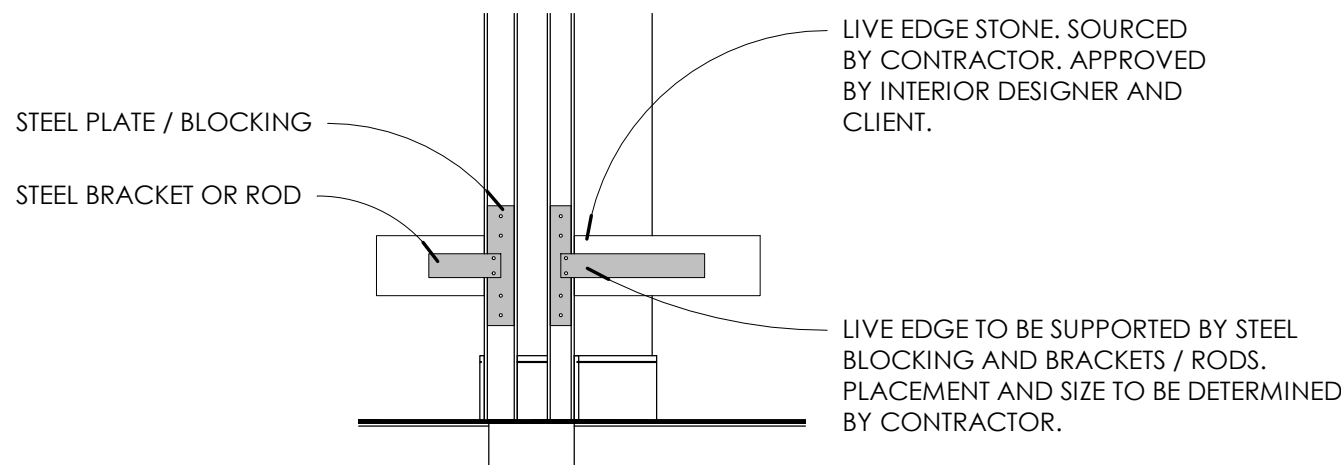

9 LIVE EDGE STONE LEDGE
3/8" = 1'-0"



500 Madison unit 107,
Nashville, Tennessee 37208
w: murphymaudeinteriors.com
p: (901) 848-6402
copyright 2021

CLIENT
MR. AND MRS. CLIENT

PROJECT LOCATION
94 CUMBERLAND,
MEMPHIS, TN


PROJECT NAME
PERSONAL RESIDENCE

DATE ISSUED
DRAWING SCALE
8/14/2023
As indicated


DRAWING TITLE
INTERIOR ELEVATIONS

REVISIONS:
NUMBER DATE DESCRIPTION


SUPPLEMENTAL INTERIOR DESIGN
DOCUMENT
ID401

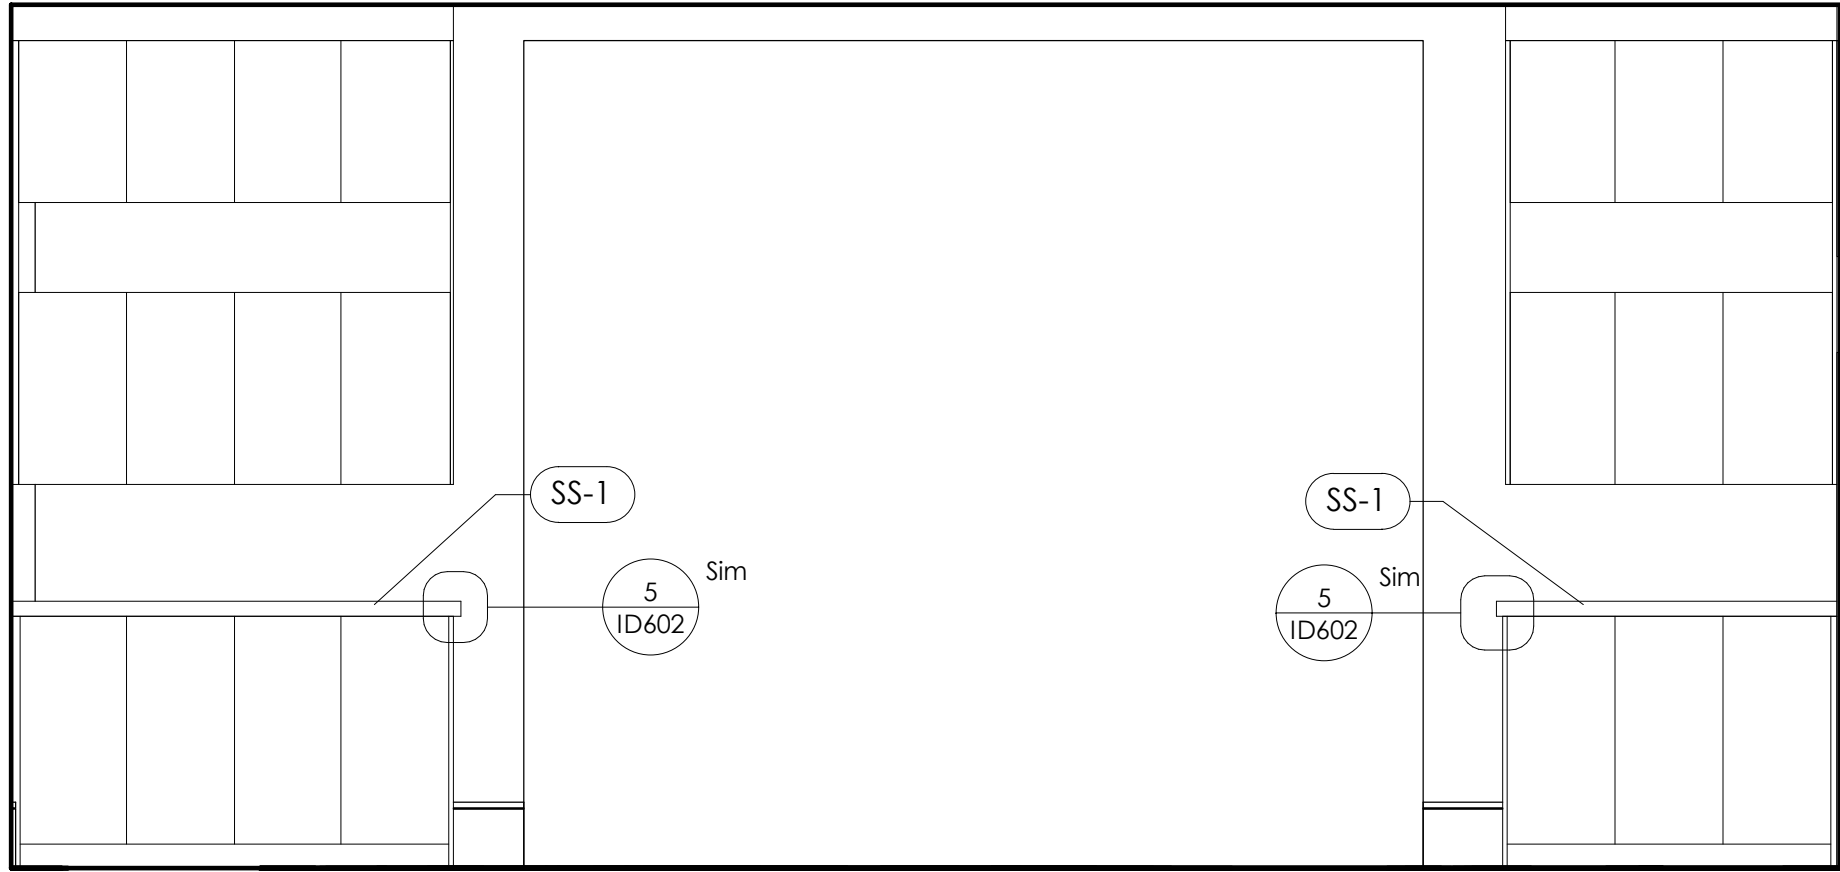


7 KITCHEN A
3/8" = 1'-0"

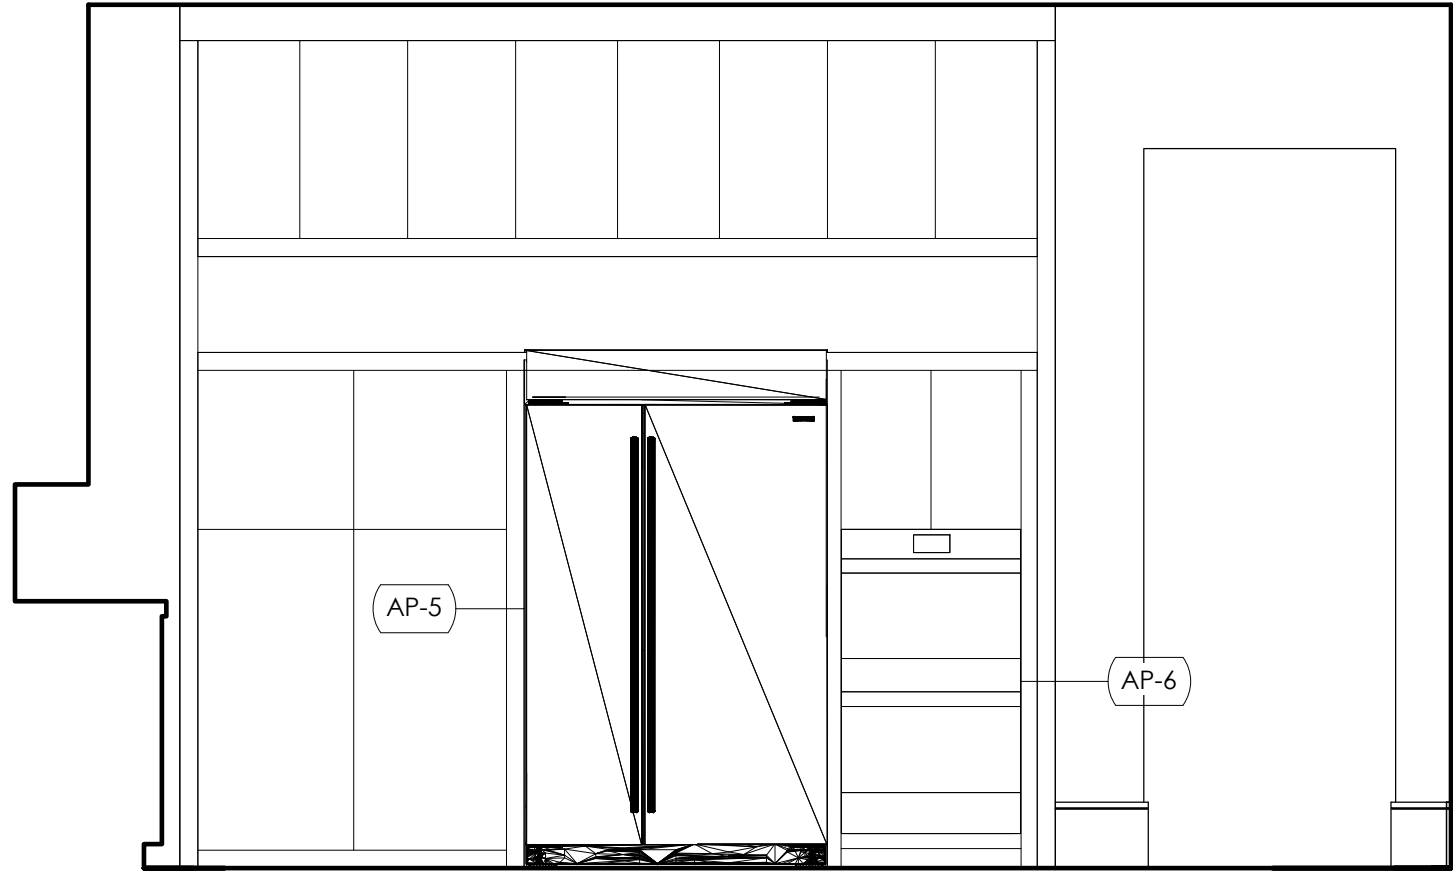


6 KITCHEN B
3/8" = 1'-0"

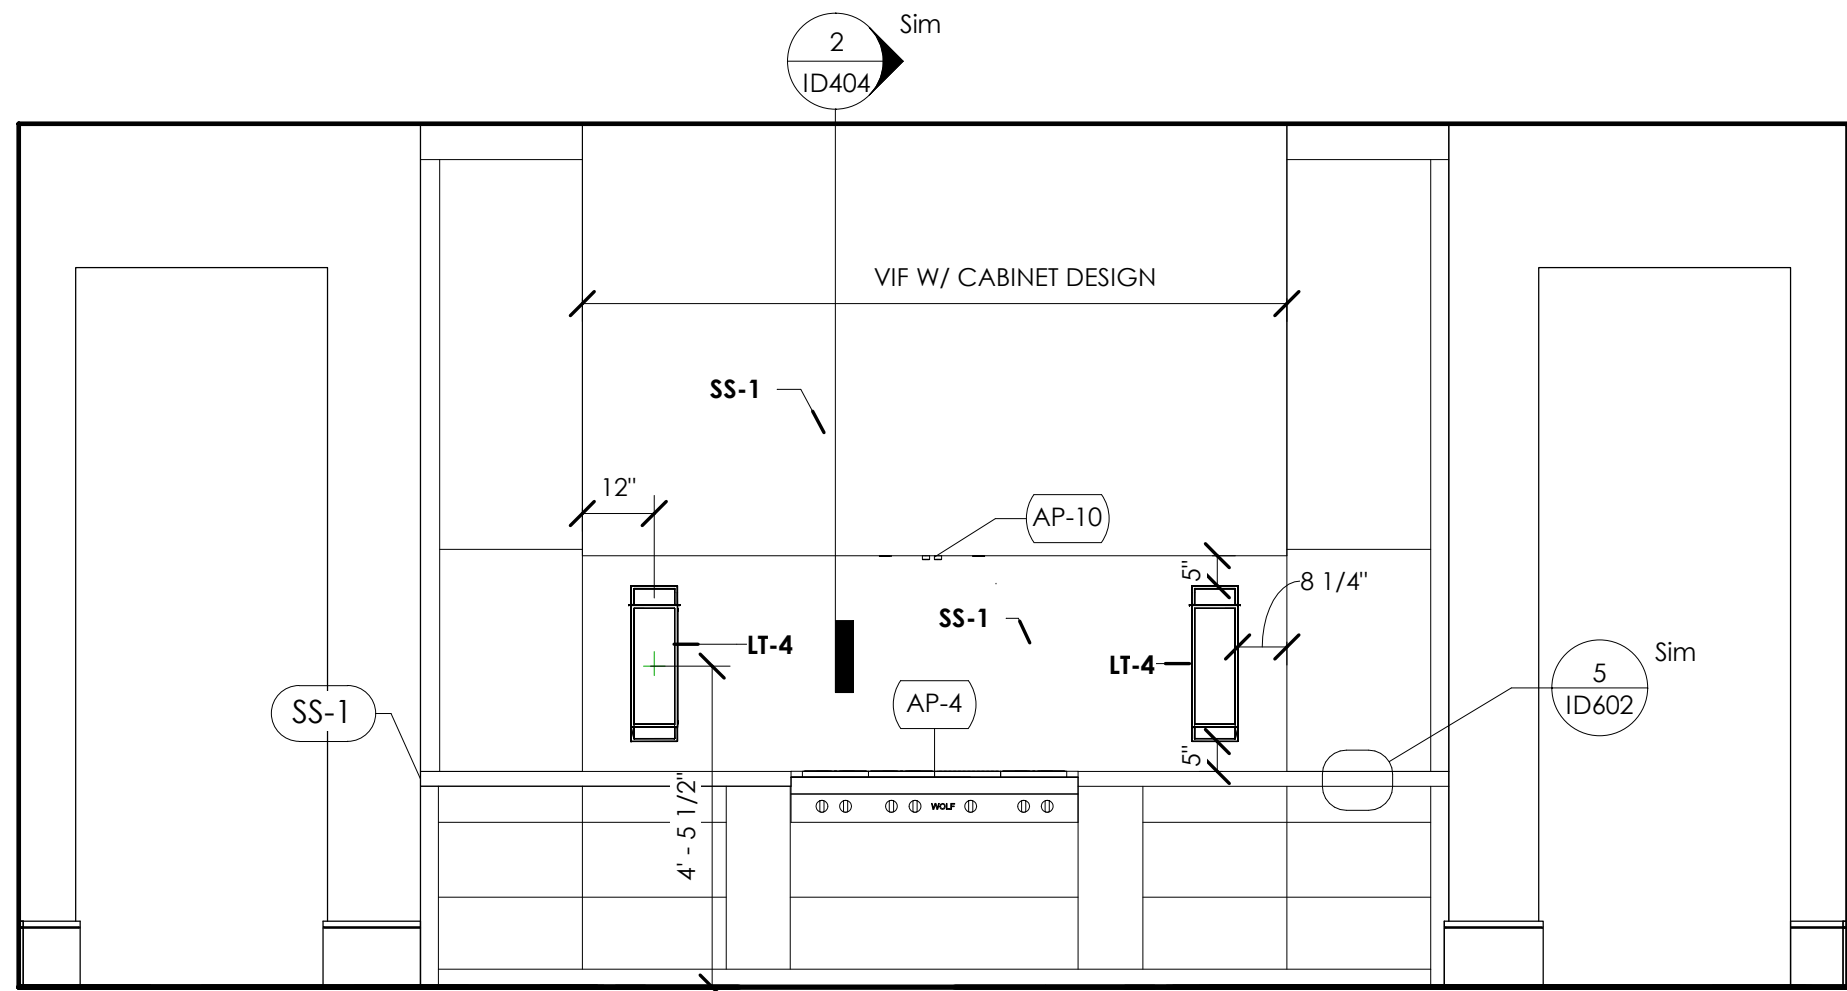

5 KITCHEN C
3/8" = 1'-0"

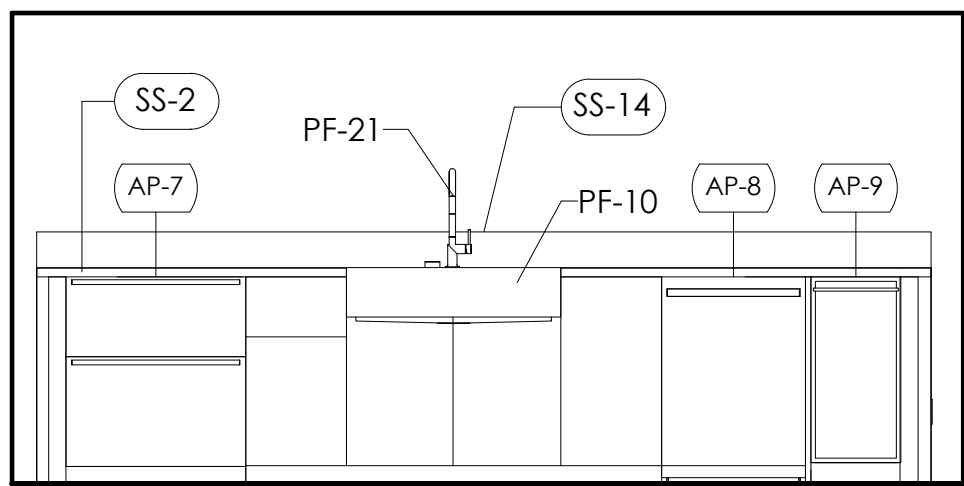

4 KITCHEN ISLAND A
3/8" = 1'-0"

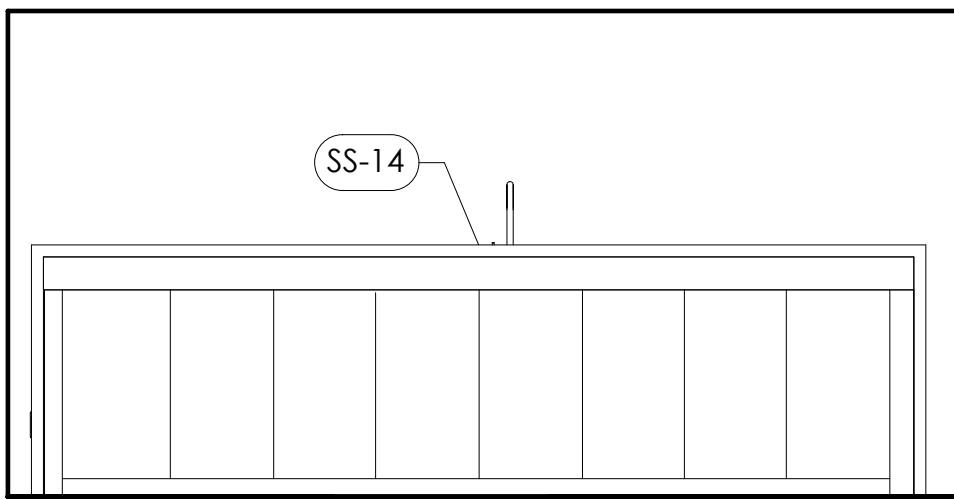

3 KITCHEN ISLAND B
3/8" = 1'-0"

PLUMBING SCHEDULE - KITCHEN


IMA GE	TAG	ROOM	QTY	MANUFACTURER	PRODUCT	MODEL #	DESCRIPTION
	PF-10	KITCHEN	1	Elkay	Elkay Quartz Luxe Single Bowl Farmhouse Sink	ELXUFF3620	35-7/8 inch X 20-15/16 inch X 9 inch with perfect drain, color Caviar
	PF-21	KITCHEN	1	House of Rohl	Eclissi Pull-Down Kitchen Faucet	EC55D1MB	Matte Black finish; C-Spout Less Handle
	PF-57	KITCHEN	1	TBD		TBD	Contact client for specifications
Grand total: 3			3				

APPLIANCE SCHEDULE


TAG	DESCRIPTION	MANUFACTURER	SKU	ROOM	LEVEL	COUNT
AP-1	36" Classic French Door	Subzero	CI3650UFD	SCULLERY	LEVEL 1	1
AP-2	24" Wolf Transitional E Series Stop Down	WOLF	MDD24TE-S-TH	SCULLERY	LEVEL 1	1
AP-3	30" Warming Drawer	Wolf	WWD30	SCULLERY	LEVEL 1	2
AP-4	48" 6 Burners, Charbroil	Wolf	SRT486C	KITCHEN	LEVEL 1	1
AP-5	48" Classic Side by side fridge/freezer, panel ready	Sub Zero	CL4850	KITCHEN	LEVEL 1	1
AP-6	Contemporary Series Stainless Steel Built in	Wolf	D030CMS	KITCHEN	LEVEL 1	1
AP-7	30" Designer refrigerator drawers, panel ready	Sub Zero	ID-30R	KITCHEN	LEVEL 1	1
AP-8	Built In, panel ready	Asko	DISHWASHER SKU HERE	SCULLERY	LEVEL 1	1
AP-9	15" Nugget ice maker	Scotsman	SCN60	KITCHEN	LEVEL 1	1
AP-10	48 x 19 stainless range hood insert, IB1200, 1200 cfm	FABER	INPL4819SSNB-B	KITCHEN	LEVEL 1	1

SOLID SURFACE SCHEDULE

TAG	ROOM	LOCATION	PRODUCT
SS-1	KITCHEN	Kitchen Perimeter	TO BE DETERMINED
SS-1	KITCHEN	Kitchen Perimeter	TO BE DETERMINED
SS-1	KITCHEN	Kitchen Perimeter	TO BE DETERMINED
SS-2	KITCHEN	Kitchen Island	TO BE DETERMINED
SS-3	SCULLERY	Countertop	TO BE DETERMINED
SS-4	BAR	Countertop	Cambria - Charlestown
SS-5	POWDER ROOM	Countertop	Natural Stone - Calacatta Viola
SS-6	POOL BATH	Countertop	Sapient Stone - Bright Onyx
SS-7	OUTDOOR KITCHEN	Countertop	TO BE DETERMINED
SS-8	HIS BATH	Countertop	Sapient Stone - Rovere Buckskin
SS-9	UTILITY	Countertop	SapientStone - PIASENTINA
SS-10	MASTER BATH	Countertop	Dekton - Morphous
SS-11	GUEST BATH 3	Countertop	Cambria - Deligate
SS-12	GUEST BATH 2	Countertop	SapientStone - Black Diamond
SS-13	GUEST BATH	Countertop	Cambria - Deligate
SS-14	KITCHEN	Kitchen Island Bar Height	TO BE DETERMINED

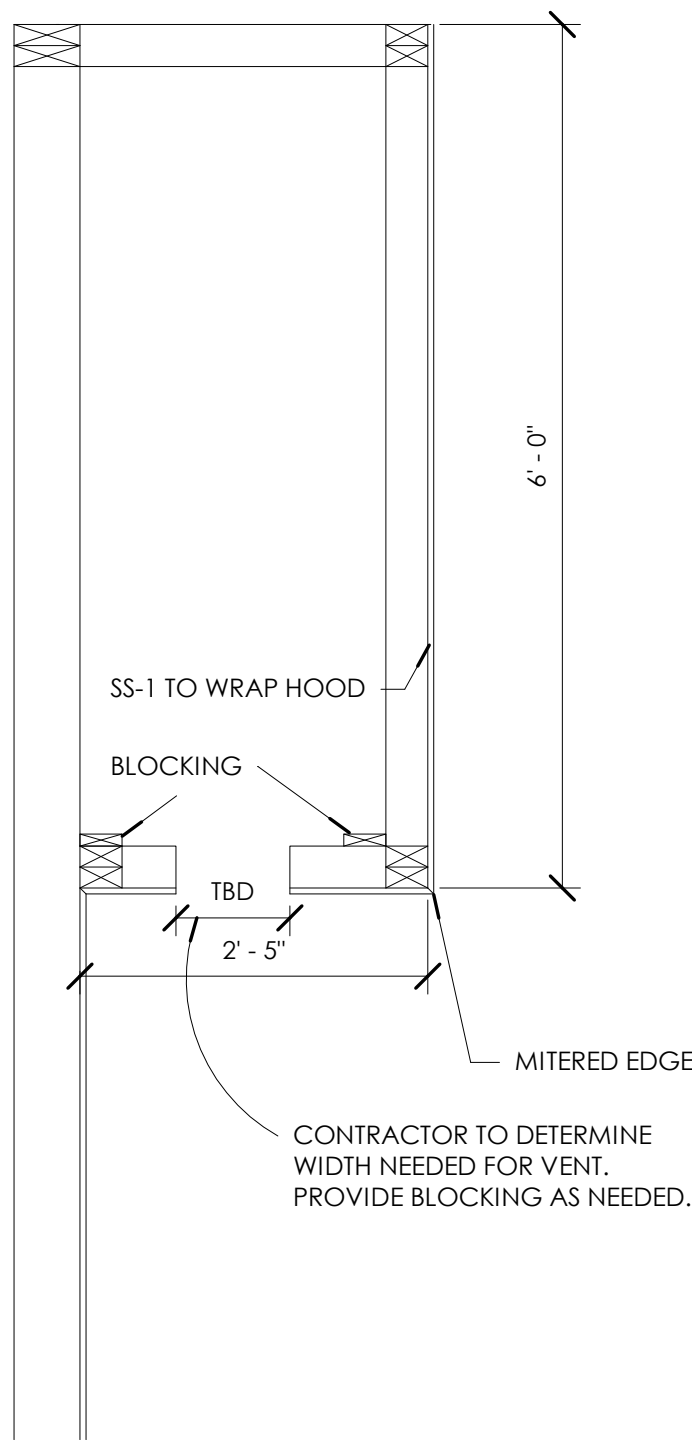

2 KITCHEN HOOD DETAIL
3/4" = 1'-0"

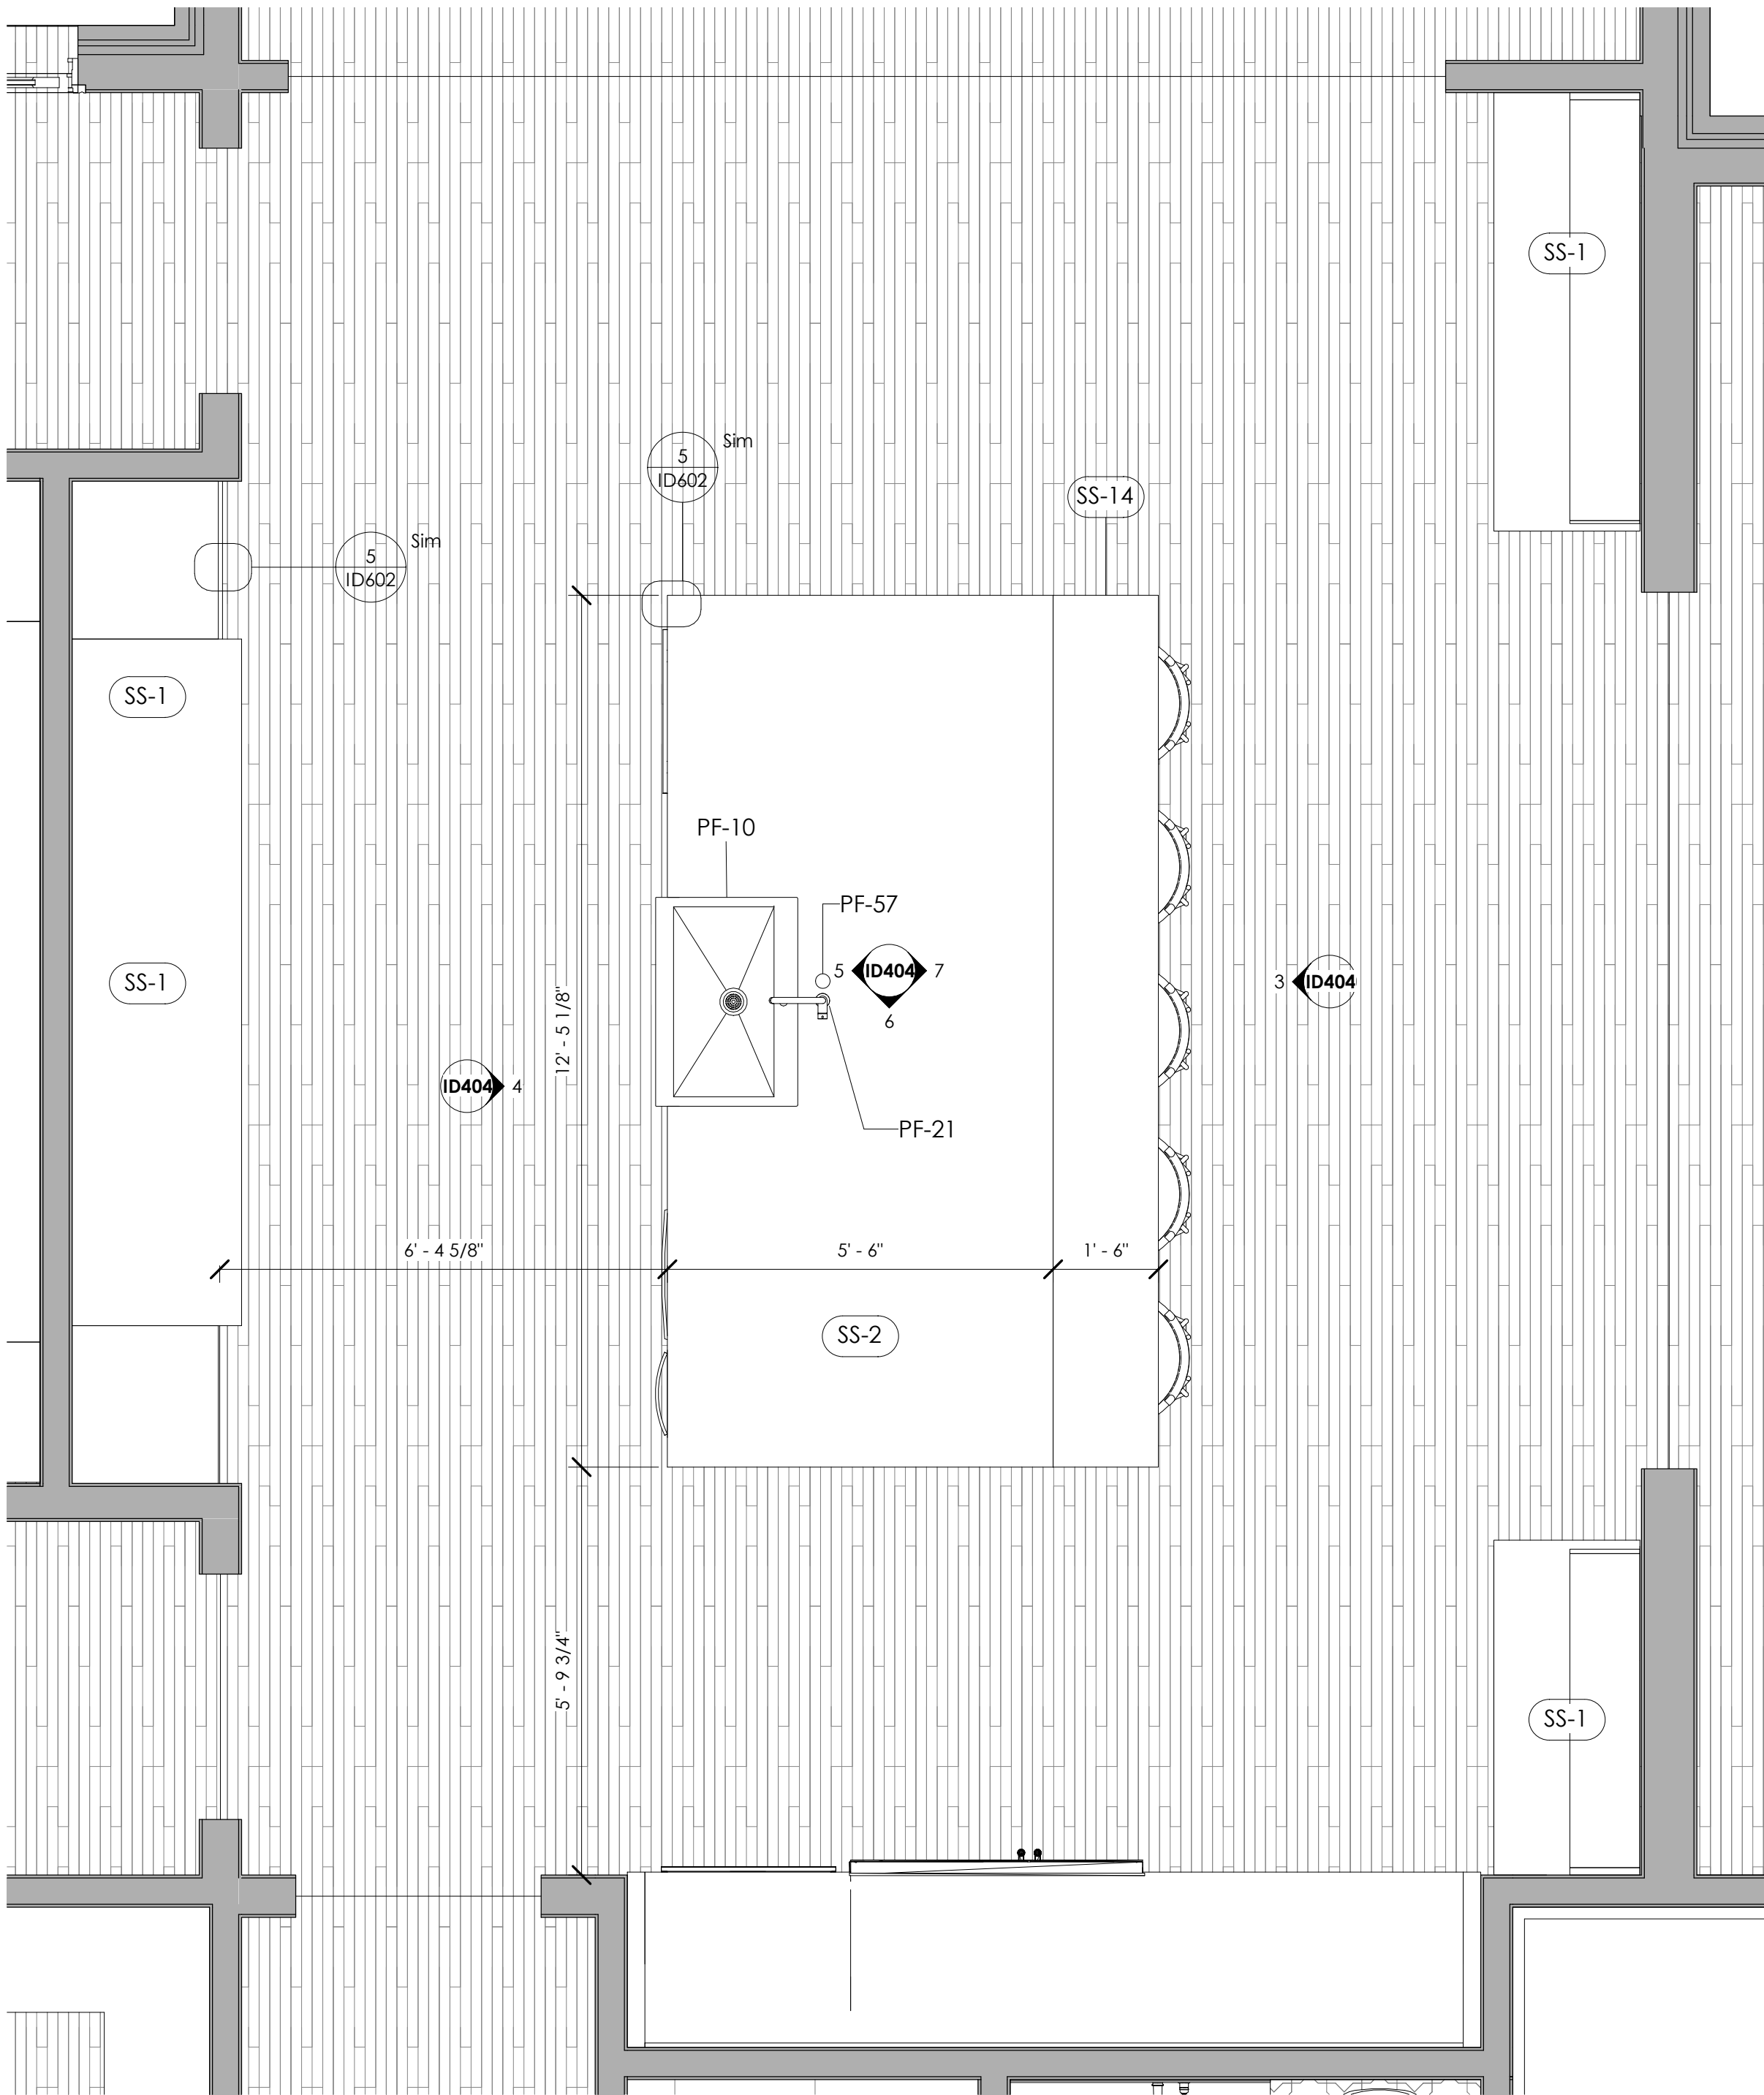

1 LEVEL 1 - KITCHEN
1/2" = 1'-0"

NOTE: REFERENCE CABINET SHOP DRAWINGS FOR ALL CABINETRY DIMENSIONS AND DETAILS



MURPHY MAUDE
INTERIORS
500 Madison unit 107,
Nashville, Tennessee 37208
w: murphymaudeinteriors.com
p: (901) 848-6402
copyright 2021

CLIENT
MR. AND MRS. CLIENT

PROJECT LOCATION
94 CUMBERLAND,
MEMPHIS, TN










PROJECT NAME
PERSONAL RESIDENCE







DATE ISSUED
DRAWING SCALE
8/14/2023
As indicated

DRAWING TITLE
ENLARGED PLAN -
KITCHEN

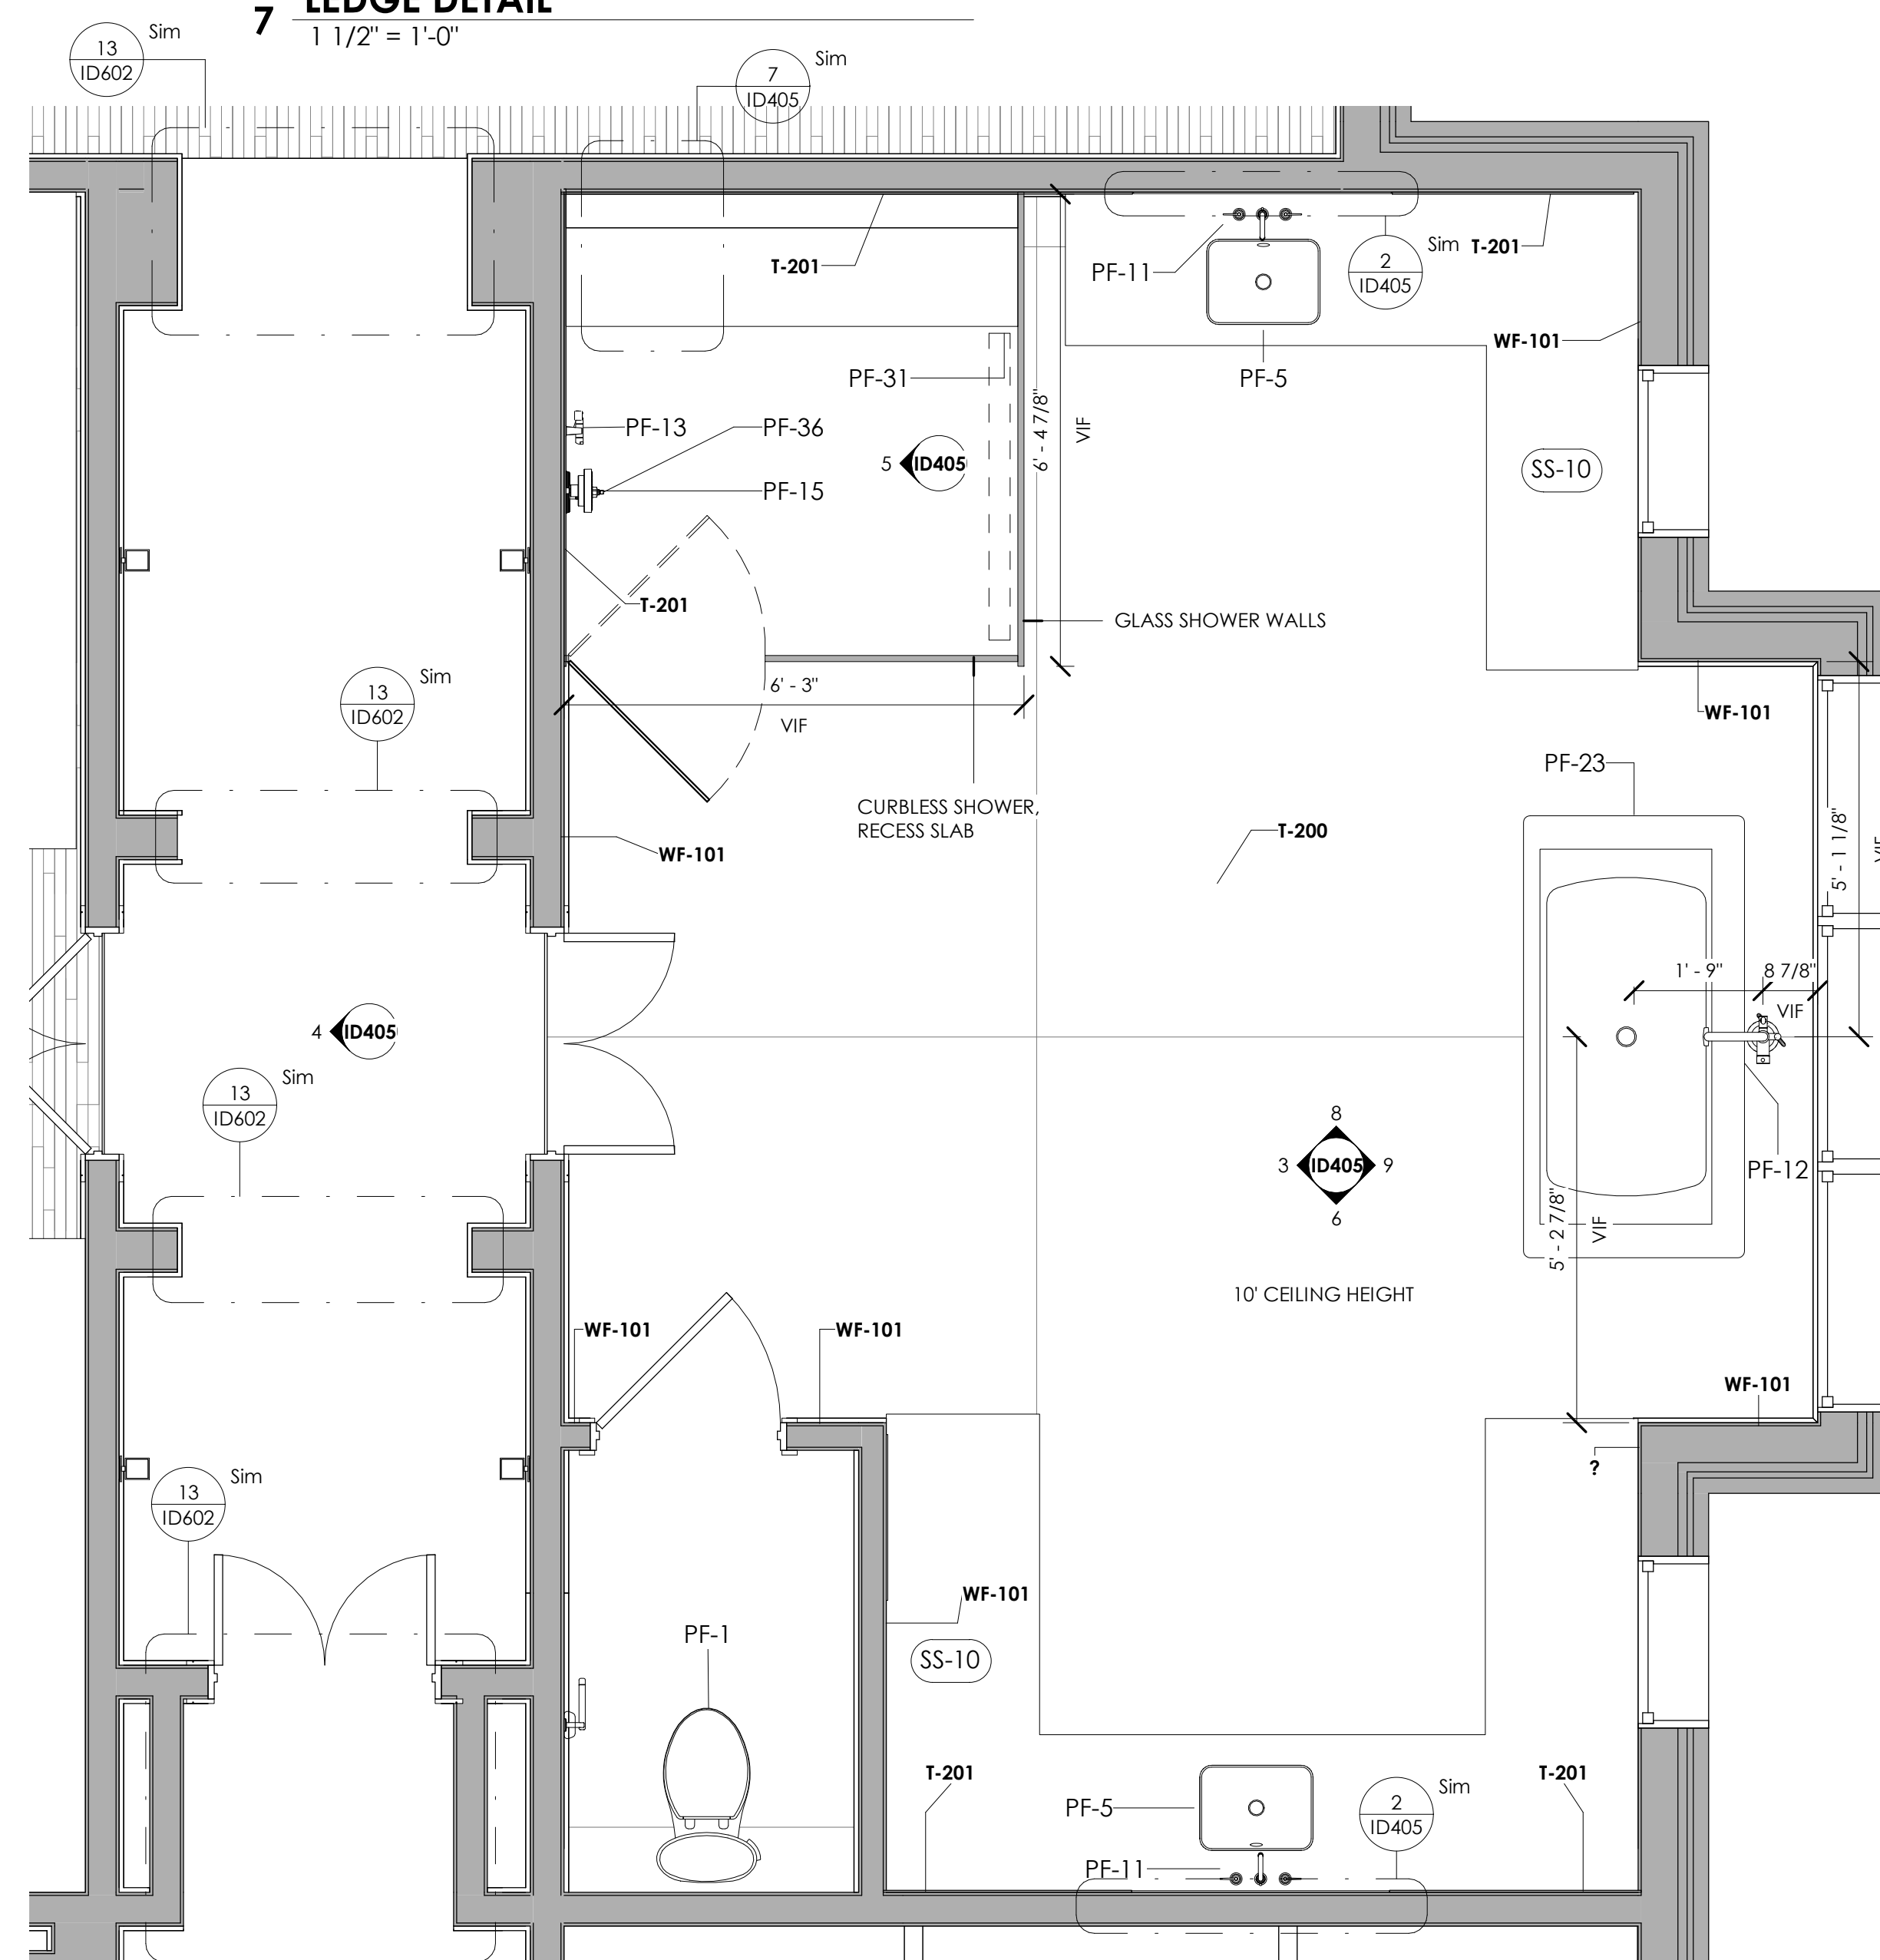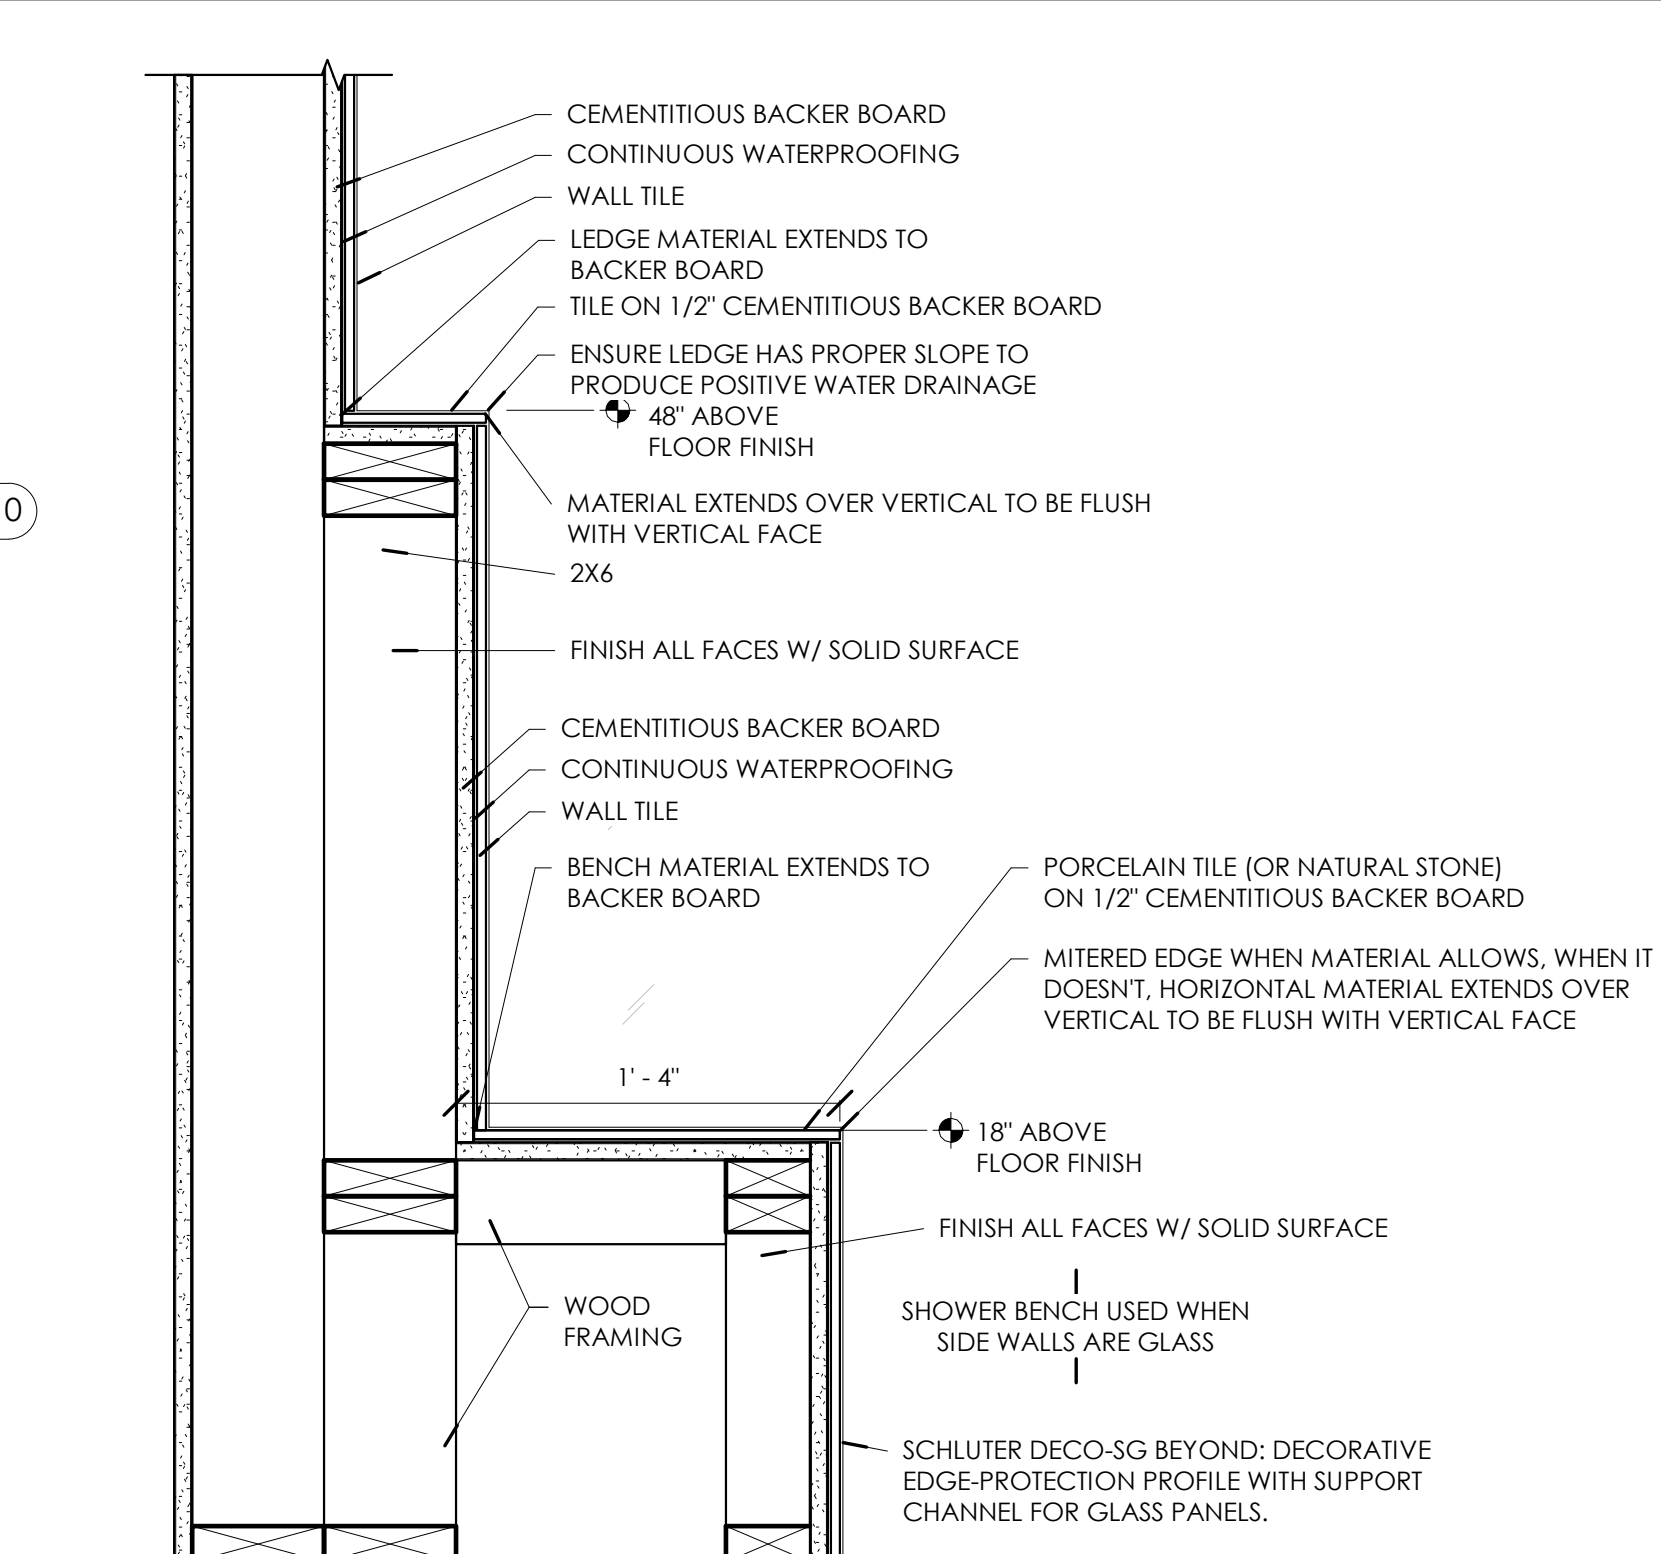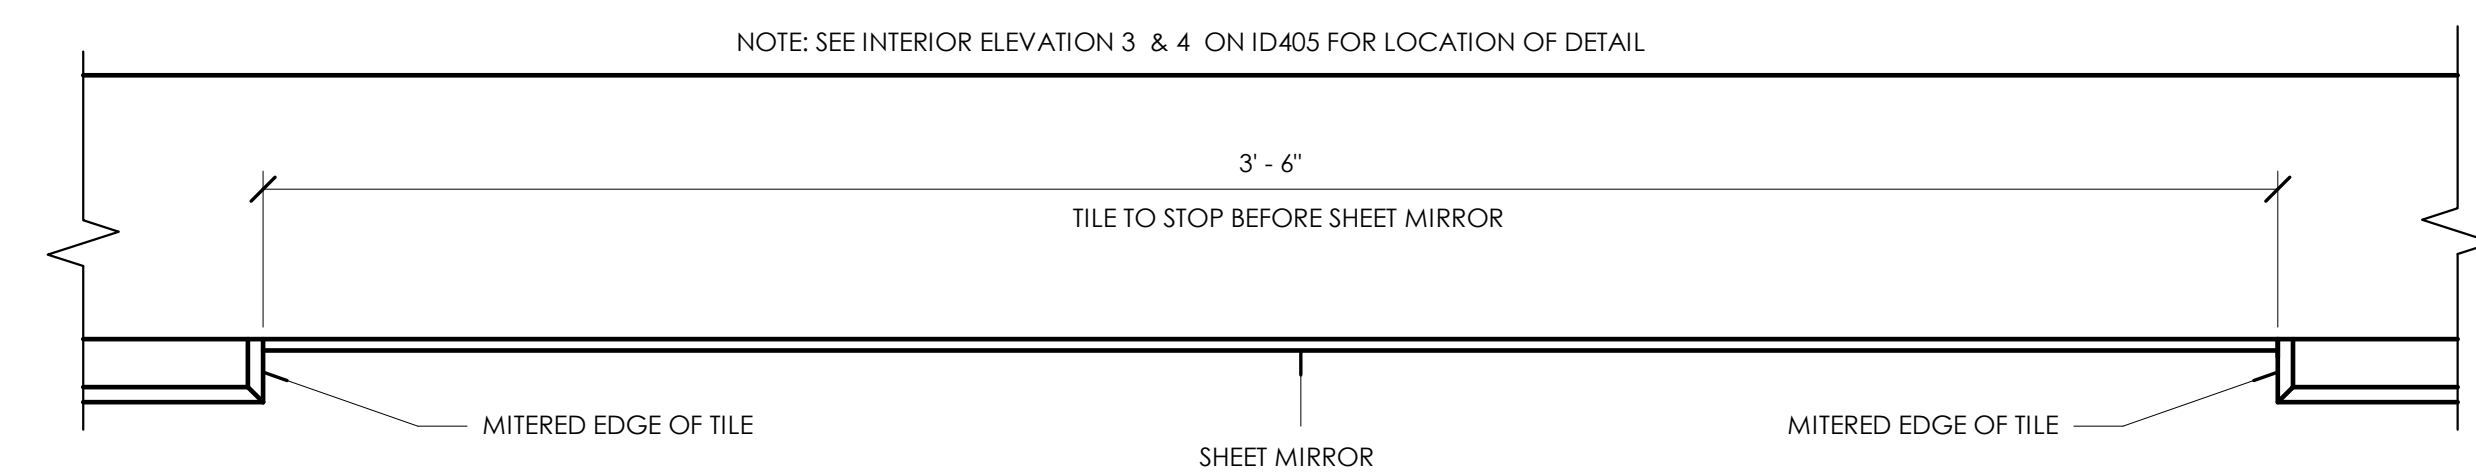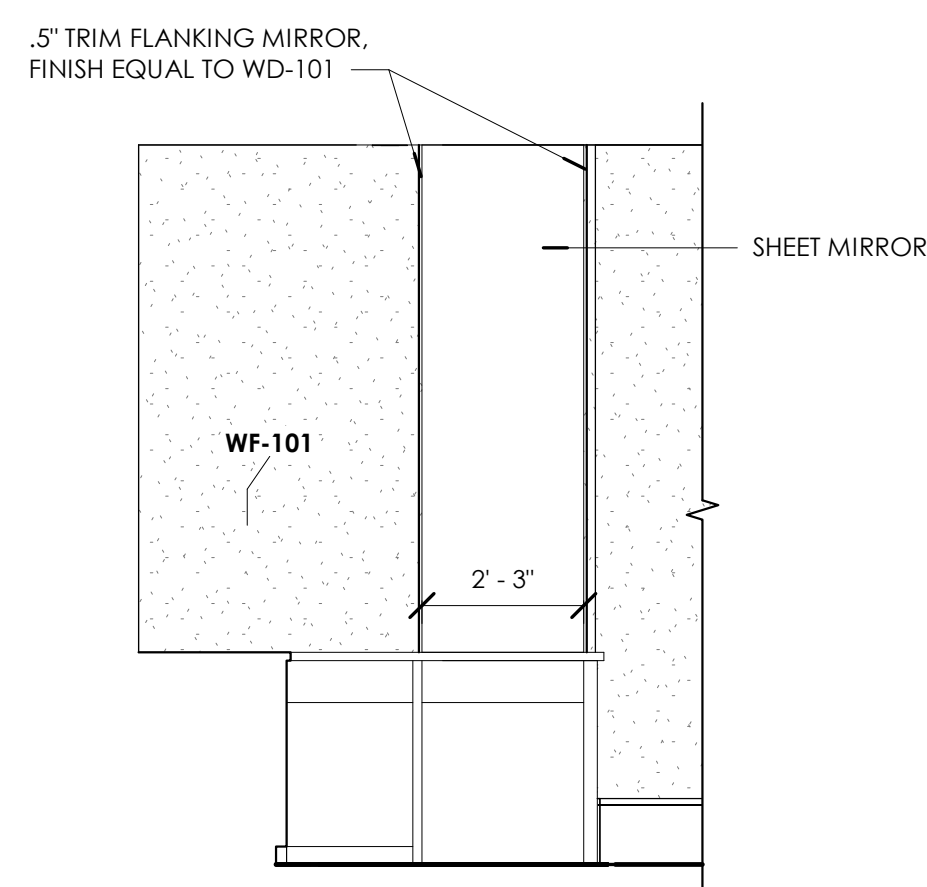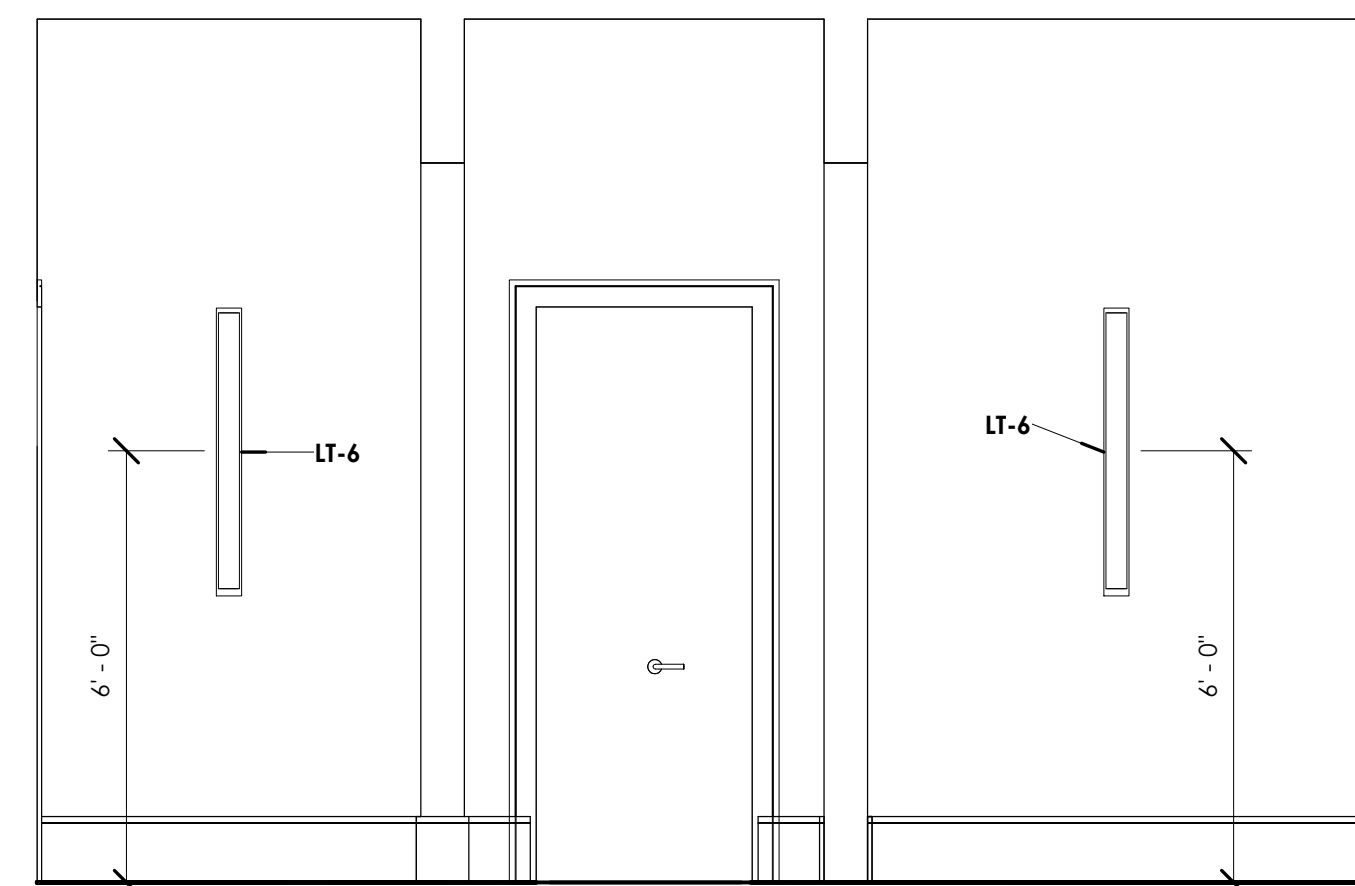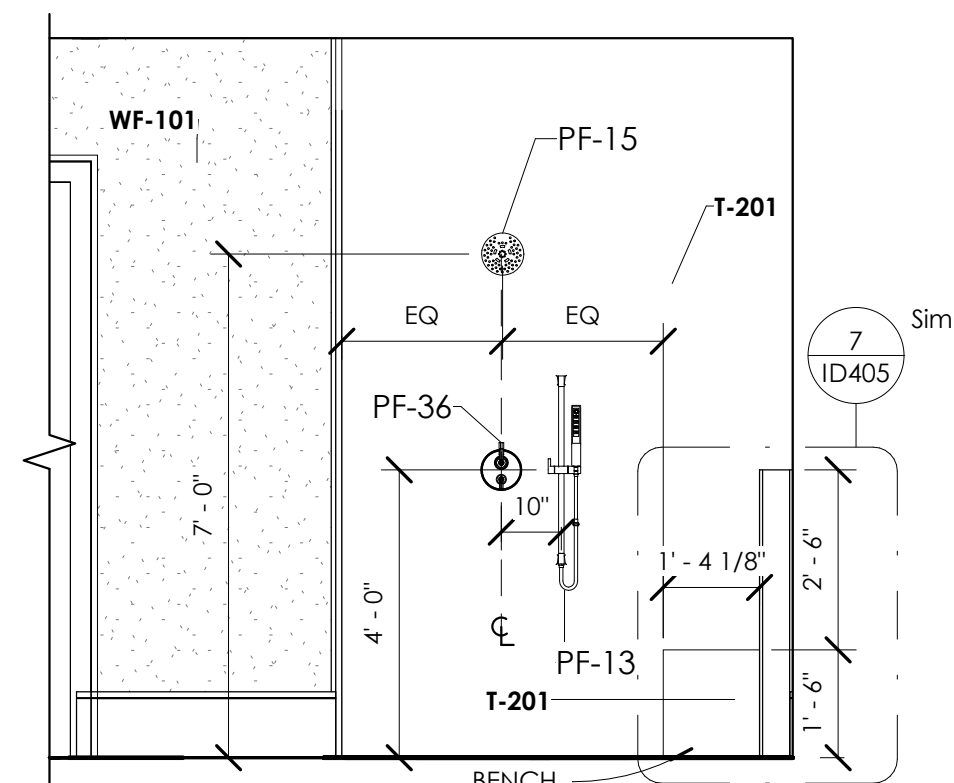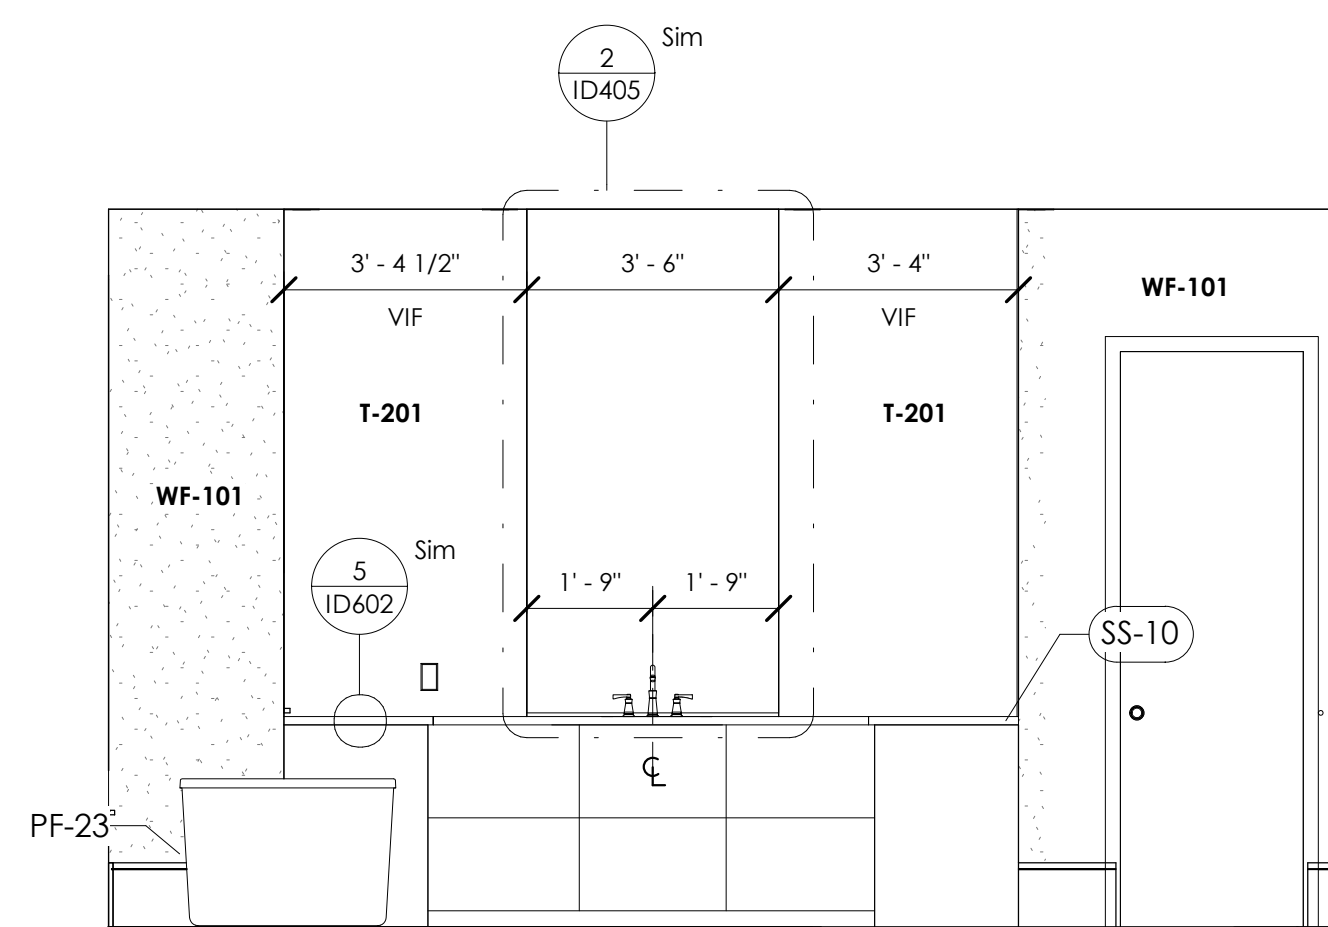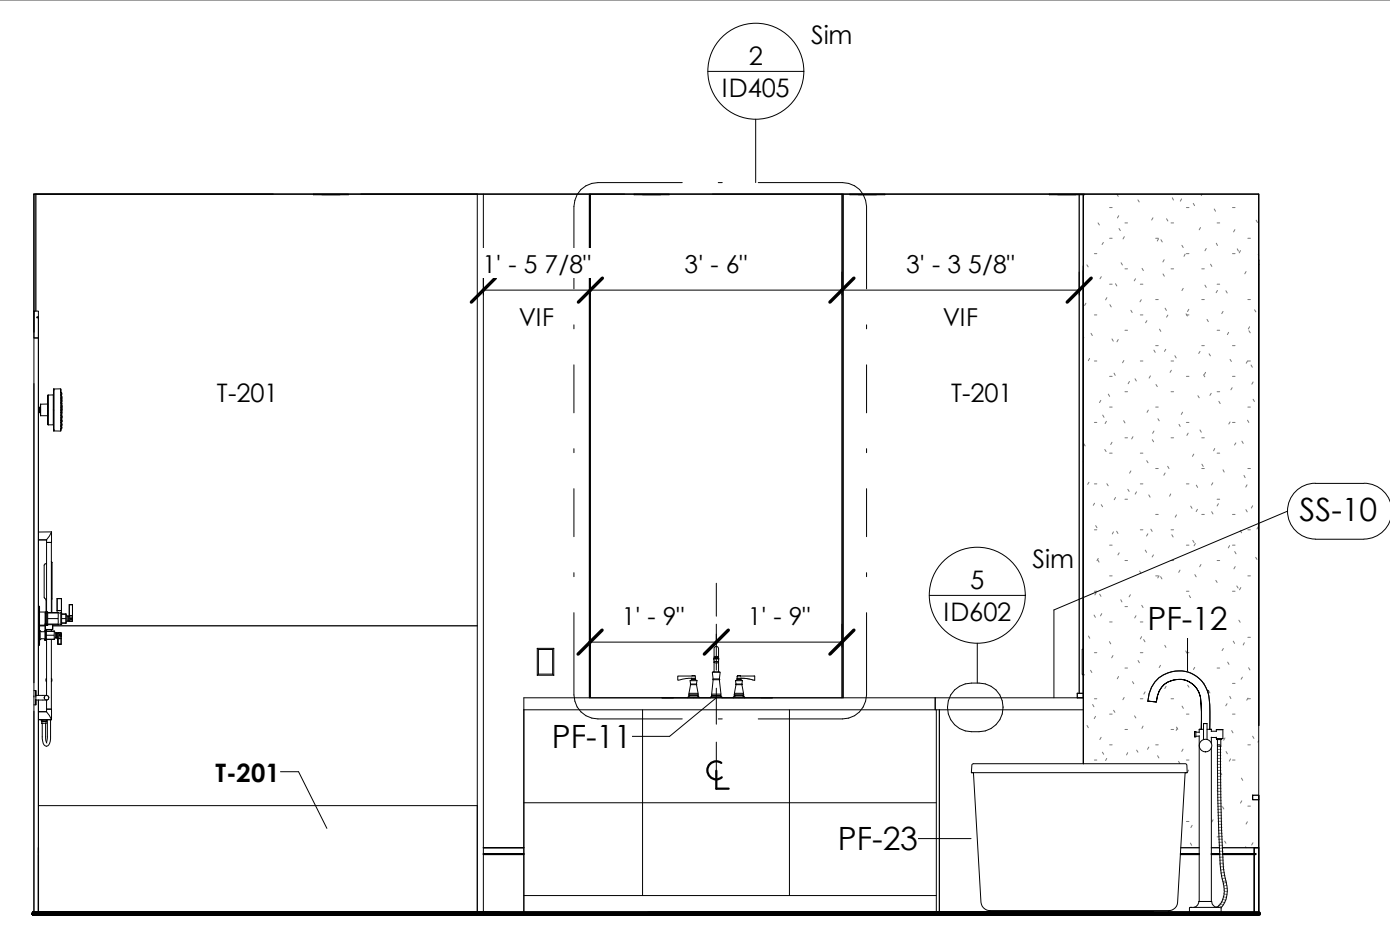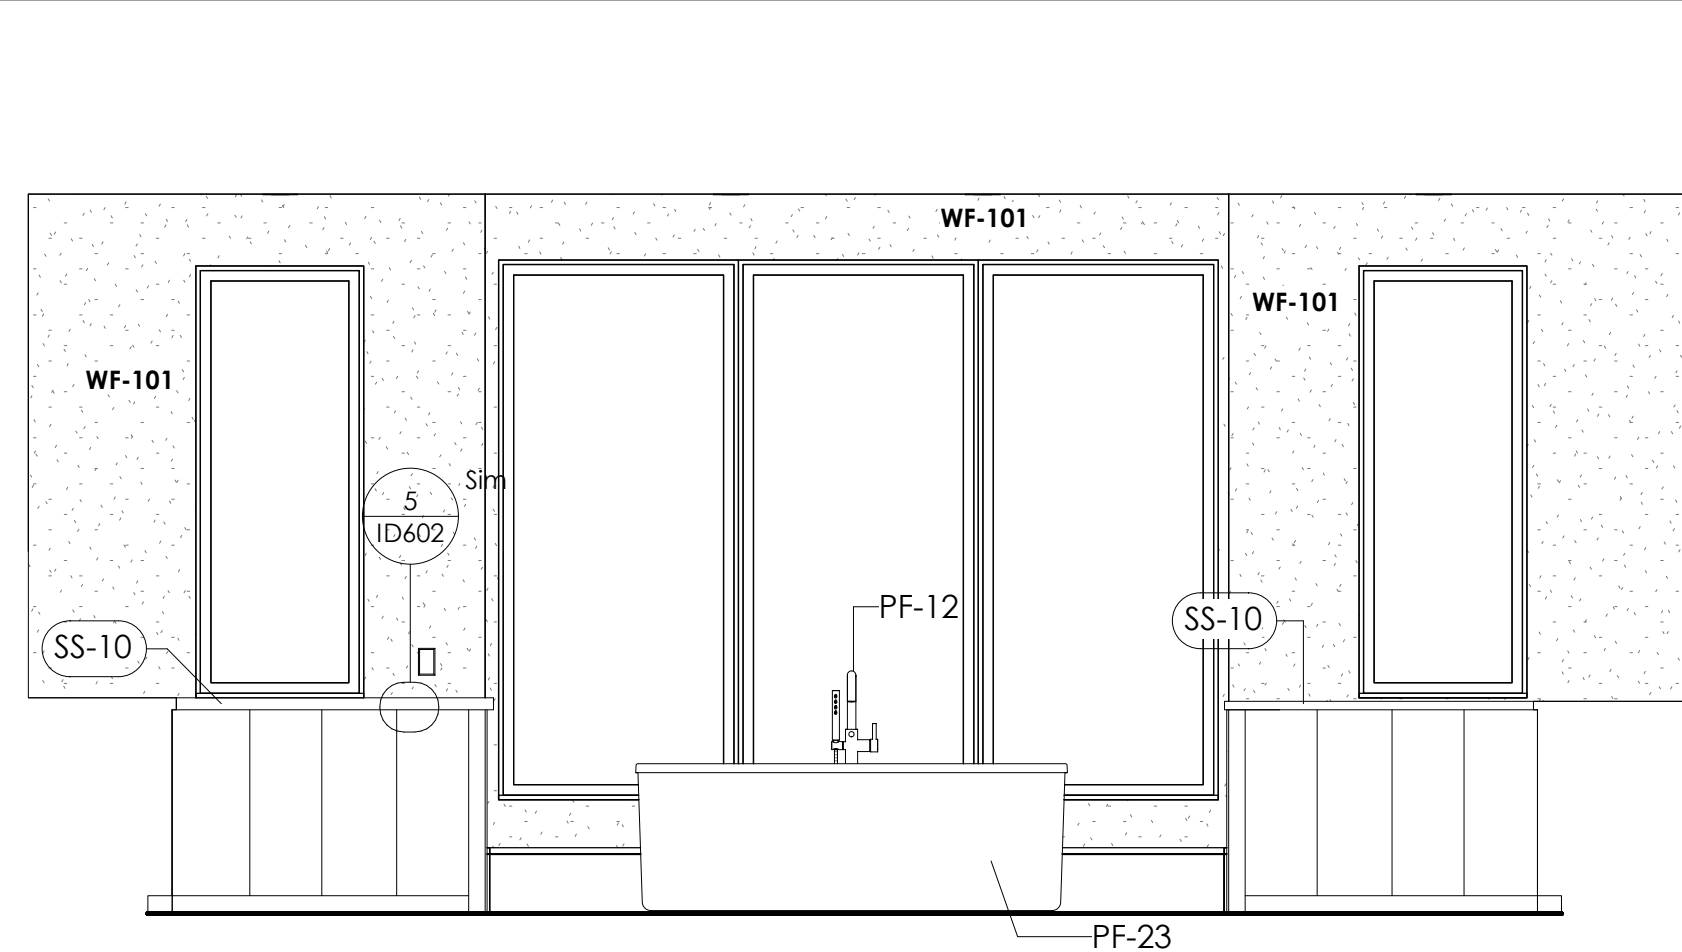REVISIONS:
NUMBER DATE DESCRIPTION

  SUPPLEMENTAL INTERIOR DESIGN
DOCUMENT
ID404



PLUMBING SCHEDULE - MASTER BATHROOM								
IMAGE	TAG	ROOM	QTY	MANUFACTURER	PRODUCT	MODEL #	DESCRIPTION	LEVEL
	PF-11	MASTER BATHROOM	2	HOUSE OF ROHL	Amahle Widespread Bathroom Faucet With C-Spout	AM08BD3IWPN	Polished Nickel	LEVEL 1
	PF-12	MASTER BATHROOM	1	HOUSE OF ROHL	Knurled Single Hole Floor Mount Tub Filler	TMB06HF1LMPN	Polished nickel finish	LEVEL 1
	PF-13	MASTER BATHROOM	1	BRIZO Kitchen and Bath Company	ESSENTIAL™ SHOWER SERIES Linear Square Multi-Function Hand Shower	74792-PN, 88099-PN	Polished nickel finish	LEVEL 1
	PF-15	MASTER BATHROOM	1	BRIZO Kitchen and Bath Company	ESSENTIAL™ SHOWER SERIES 7" Linear Round H2OKinetic® Multi-Function Wall Mount Showerhead	87492-PN-2.5, RF74448PN,	Linear Round Multi-Function Wall Mount Showerhead	LEVEL 1
	PF-23	MASTER BATHROOM	1	KOHLER Co.	Stargaze	K-1959-GHW-0	72inch x 36inch freestanding bath with straight shroud and center drain	LEVEL 1
	PF-31	MASTER BATHROOM	1	Kohler	Linear drain grate with tile-in panel	K-80651-BNK	1.25 x 48 drain in bright silver	LEVEL 1
Grand total: 7			7					

NOTE: GENERAL PLUMBING SHOWN. REFER TO PLUMBING SUBMITTALS FOR RECOMMENDED VALVES, TRIM, ETC.
ALL SCHLUTER TRIM TO MATCH PLUMBING PER LOCATION

**NOTE: REFERENCE CABINET SHOP DRAWINGS
FOR ALL CABINETRY DIMENSIONS AND DETAILS**



**500 Madison unit 107,
Nashville, Tennessee 37208**
w: murphymaudeinteriors.com
p: (901) 848-6402
copyright 2021

CLIENT
MR. AND MRS. CLIENT

PROJECT LOCATION
94 CUMBERLAND,
MEMPHIS, TN

PROJECT NAME
PERSONAL RESIDENCE

DATE ISSUED	8/14/2023
DRAWING SCALE	As indicated


DRAWING TITLE

**ENLARGED PLAN -
MASTER BATH**


REVISIONS:		
NUMBER	DATE	DESCRIPTION

**SUPPLEMENTAL INTERIOR DESIGN
DOCUMENT**


ID405

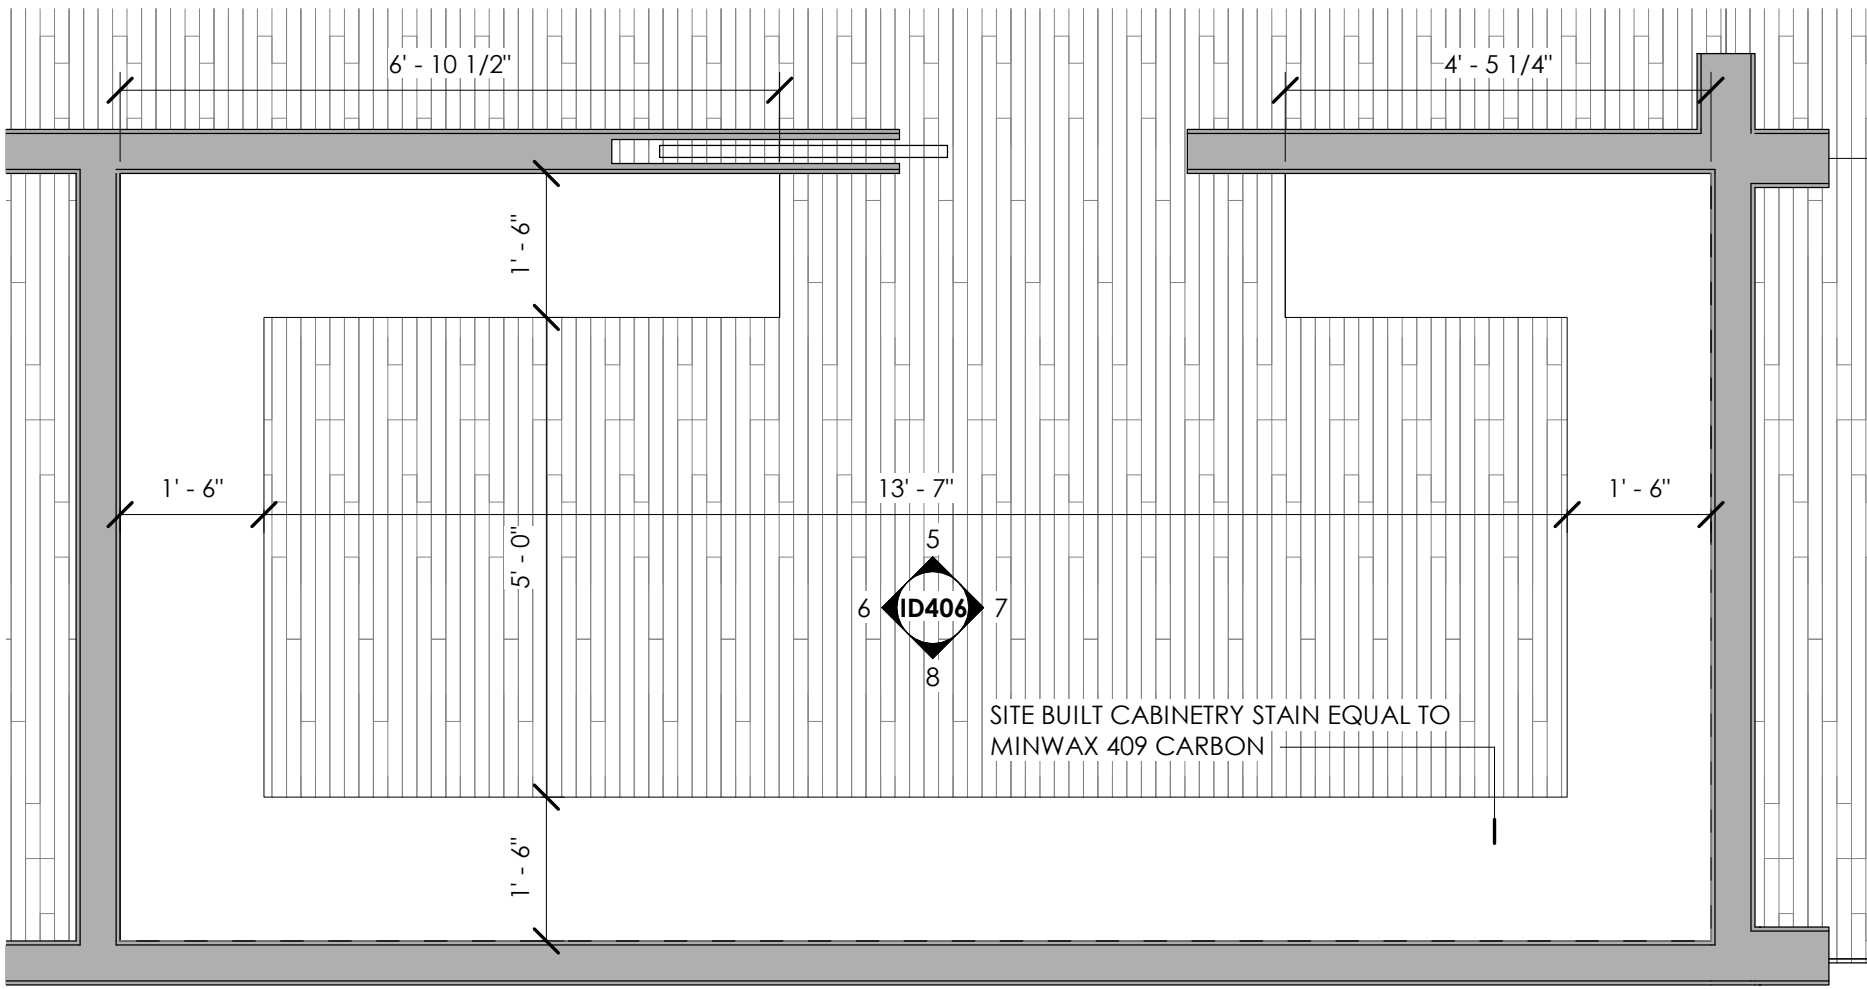


9 LEVEL 1 - PANTRY
1/2" = 1'-0"

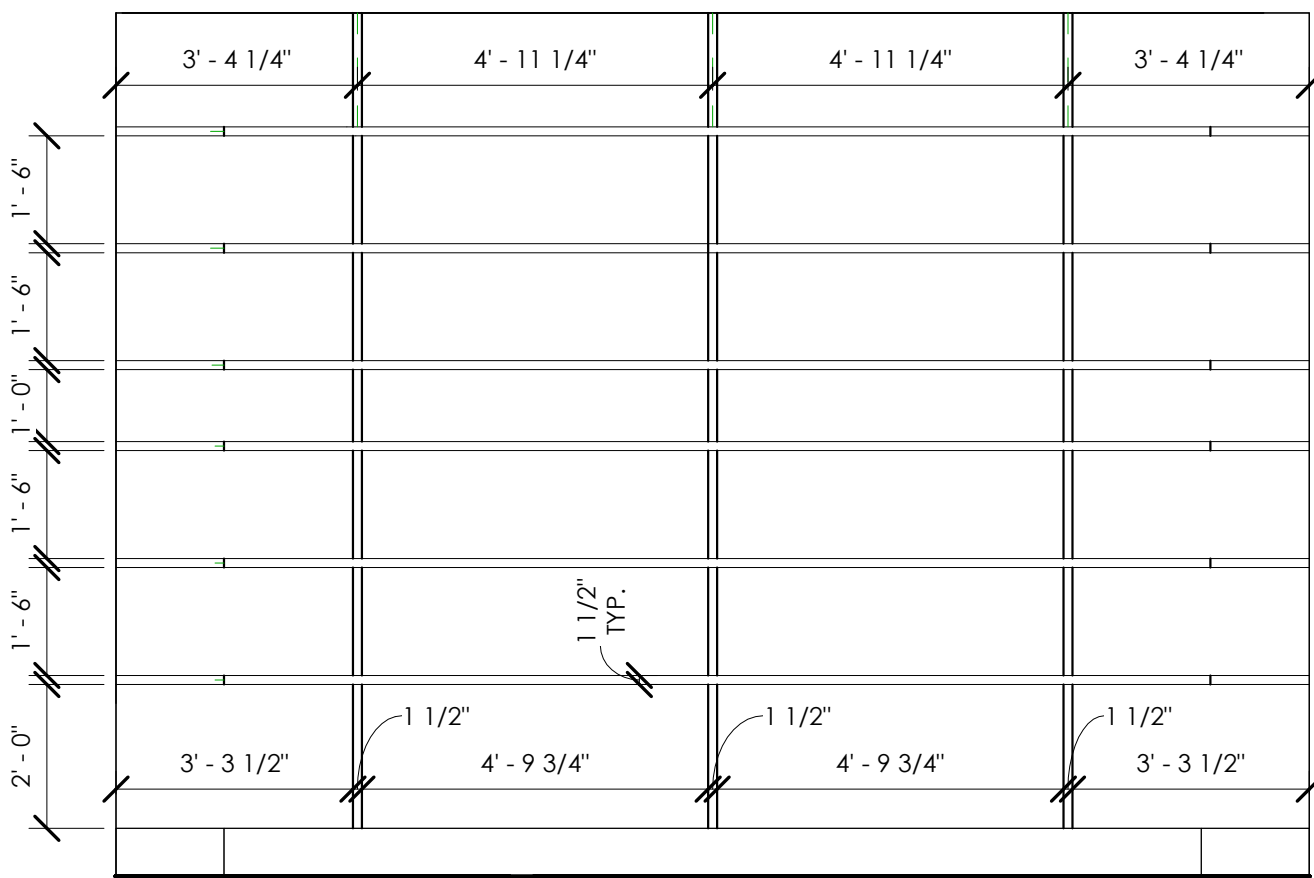


8 PANTRY A
3/8" = 1'-0"

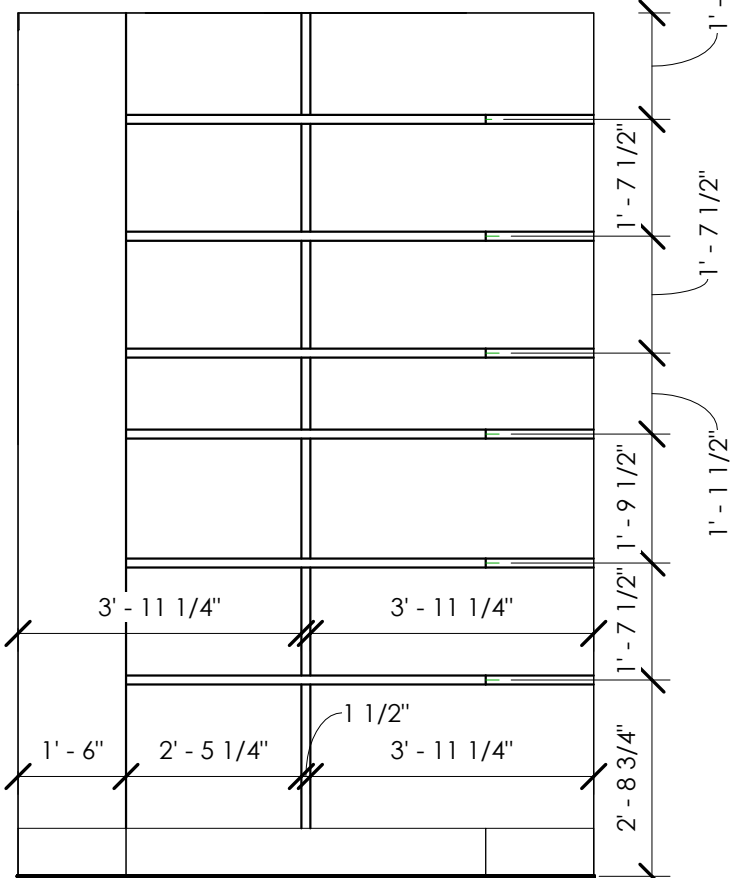

7 PANTRY B
3/8" = 1'-0"

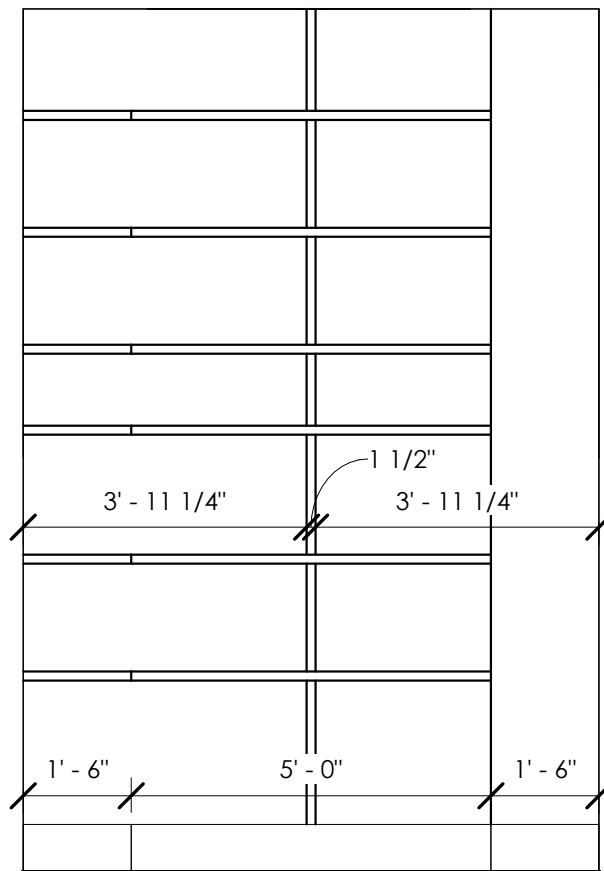


6 PANTRY C
3/8" = 1'-0"

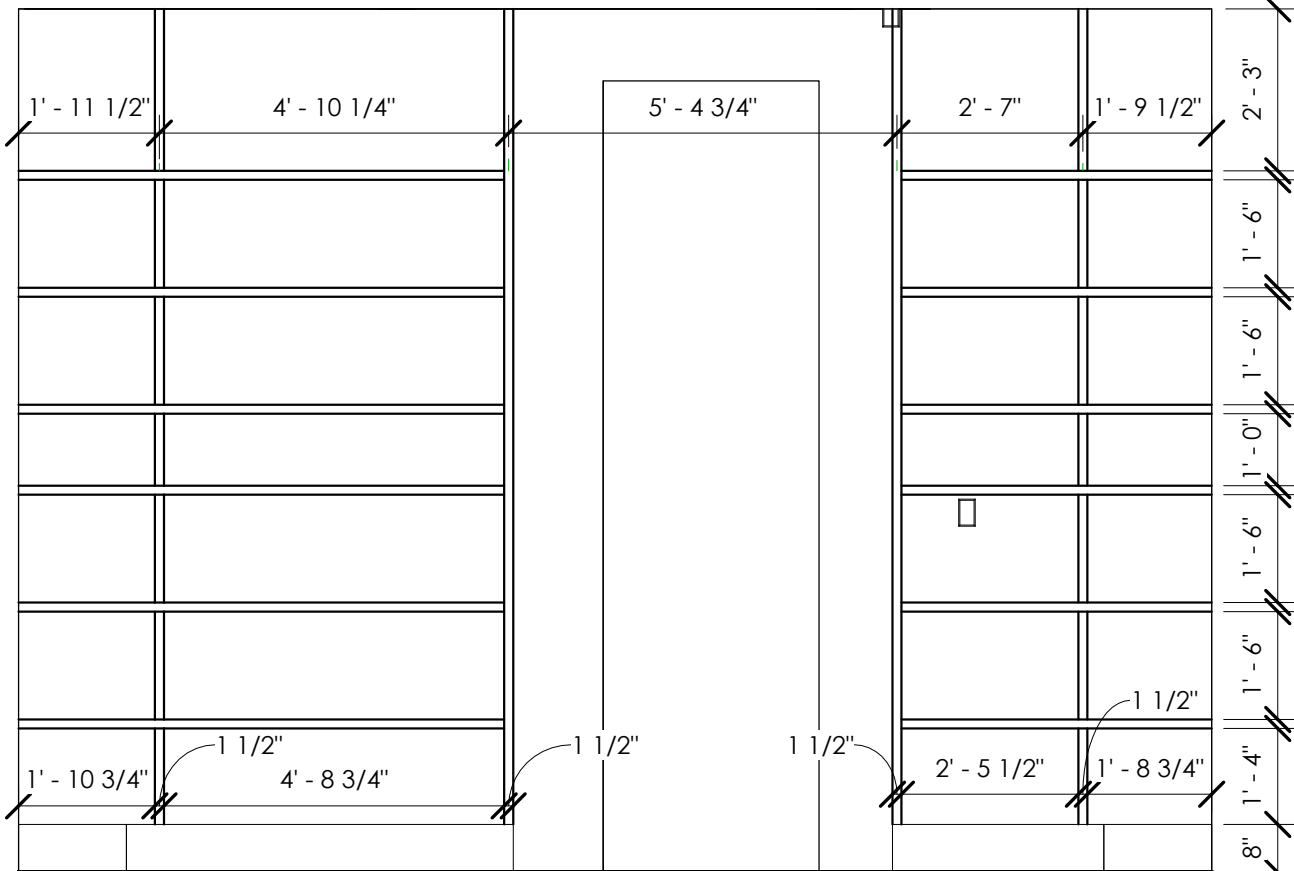

5 PANTRY D
3/8" = 1'-0"

PLUMBING SCHEDULE - OUTDOOR KITCHEN						
IMA GE	TAG	ROOM	QTY	MANUFACTURER	PRODUCT	DESCRIPTION
	PF-18	OUTDOOR KITCHEN	1	KOHLER Co.	Vault	33inch x 22inch x 9-5/16inch top-/under-mount large single-bowl kitchen sink with single faucet hole
	PF-32	OUTDOOR KITCHEN	1	KOHLER Co.	Purist	Semiprofessional kitchen sink faucet
	PF-55	OUTDOOR KITCHEN	1	TBD	TBD	Contact client for specifications
Grand total: 3			3			

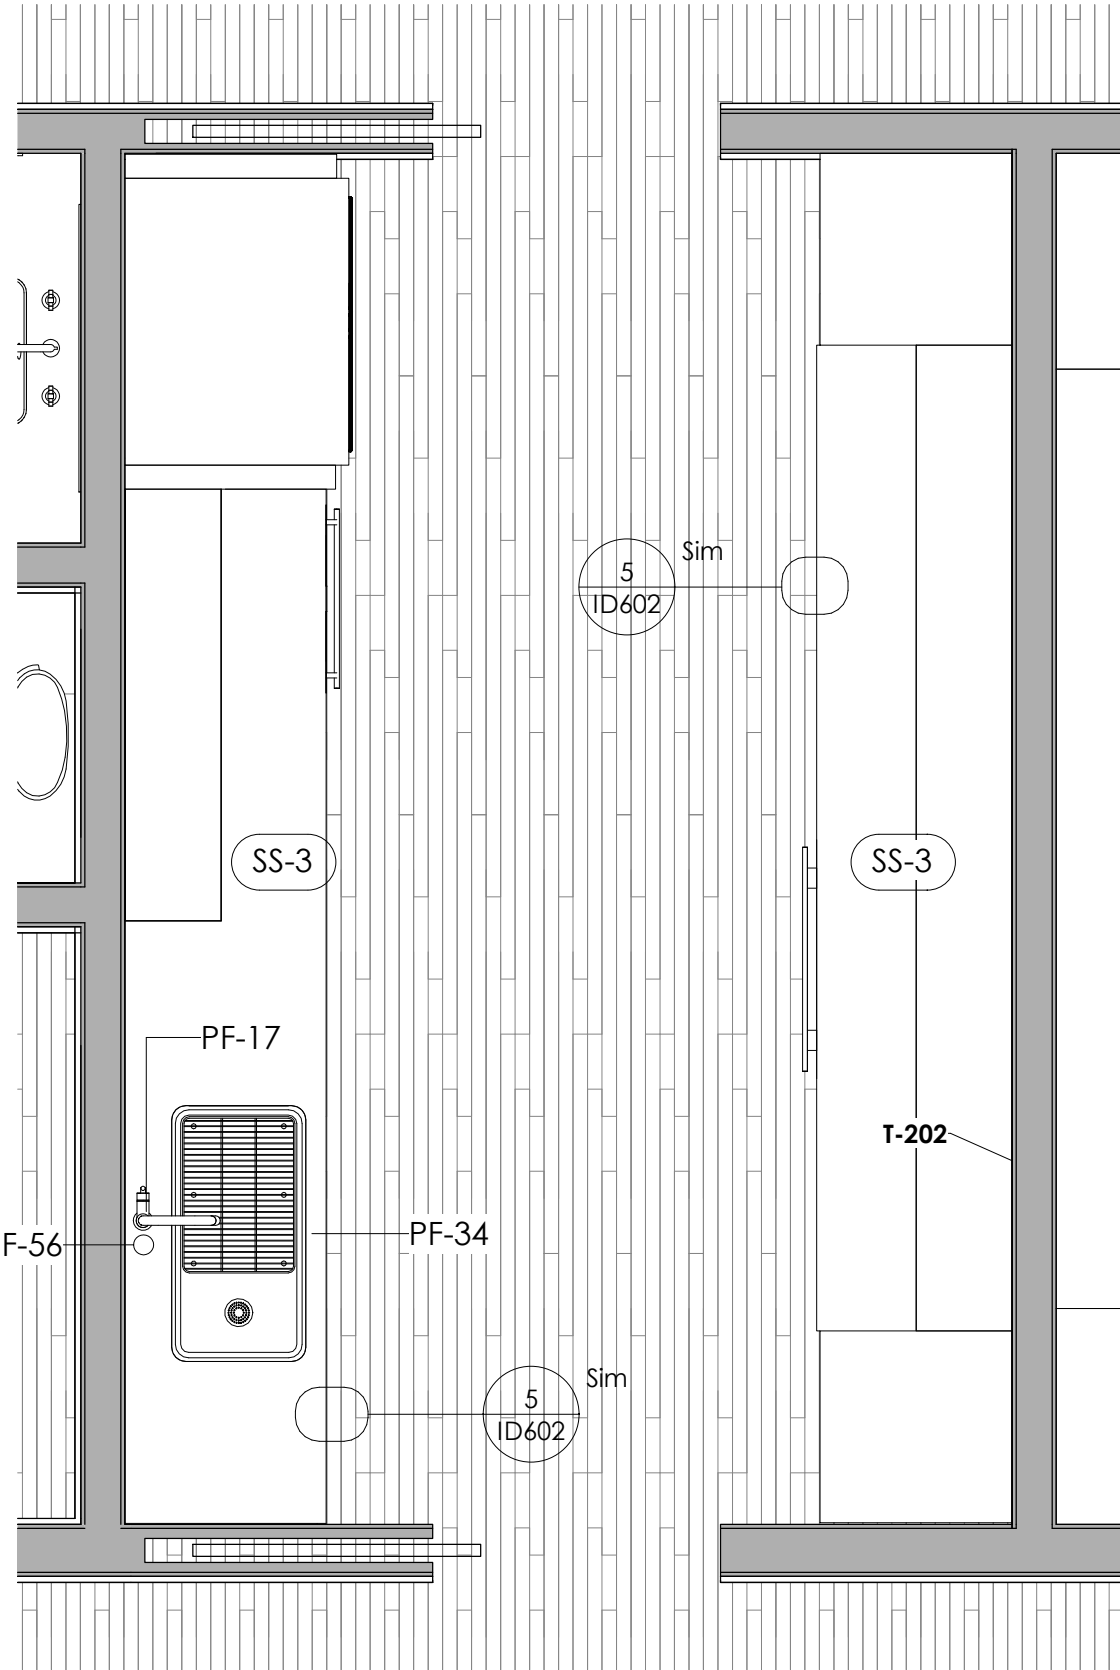


4 LEVEL 1 - SCULLERY
1/2" = 1'-0"

APPLIANCE SCHEDULE						
TAG	DESCRIPTION	MANUFACTURER	SKU	ROOM	LEVEL	COUNT
AP-1	36" Classic French Door	Subzero	C13650UFD	SCULLERY	LEVEL 1	1
AP-2	24" Wolf Transitional E Series Stop Down	WOLF	MDD24TE-S-TH	SCULLERY	LEVEL 1	1
AP-3	30" Warming Drawer	Wolf	WWD30	SCULLERY	LEVEL 1	2
AP-4	48" 6 Burners, Charbroil	Wolf	SRT486C	KITCHEN	LEVEL 1	1
AP-5	48" Classic Side by side fridge/freezer, panel ready	Sub Zero	CL4850	KITCHEN	LEVEL 1	1
AP-6	Contemporary Series Stainless Steel Built in	Wolf	D030CMS	KITCHEN	LEVEL 1	1
AP-7	30" Designer refrigerator drawers, panel ready	Sub Zero	ID-30R	KITCHEN	LEVEL 1	1
AP-8	Built In, panel ready	Asko	DISHWASHER SKU HERE	SCULLERY	LEVEL 1	1
AP-9	15" Nugget ice maker	Scotsman	SCN60	KITCHEN	LEVEL 1	1
AP-10	48 x 19 stainless range hood insert, IB1200, 1200 cfm	FABER	INPL4819SSNB-8	KITCHEN	LEVEL 1	1


PLUMBING SCHEDULE - SCULLERY						
IMA GE	TAG	ROOM	QTY	MANUFACTURER	PRODUCT	DESCRIPTION
	PF-17	SCULLERY	1	BRIZO Kitchen and Bath Company		Square Spout and Knurled Handle; Matte Black / Luxe Gold finish
	PF-34	SCULLERY	1	KOHLER Co.	Caim	Matte Graphite finish
	PF-56	SCULLERY	1	TBD	TBD	Contact client for specifications
Grand total: 3			3			



3 SCULLERY A
3/8" = 1'-0"

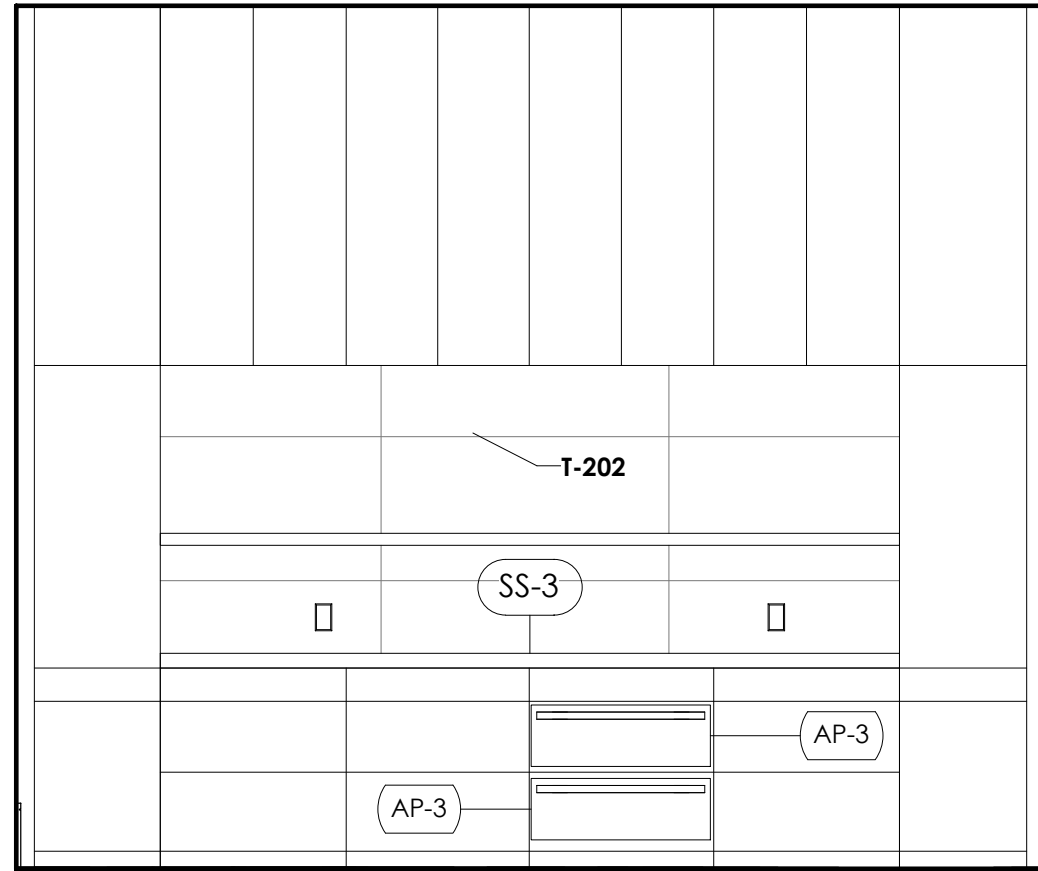

2 SCULLERY B
3/8" = 1'-0"

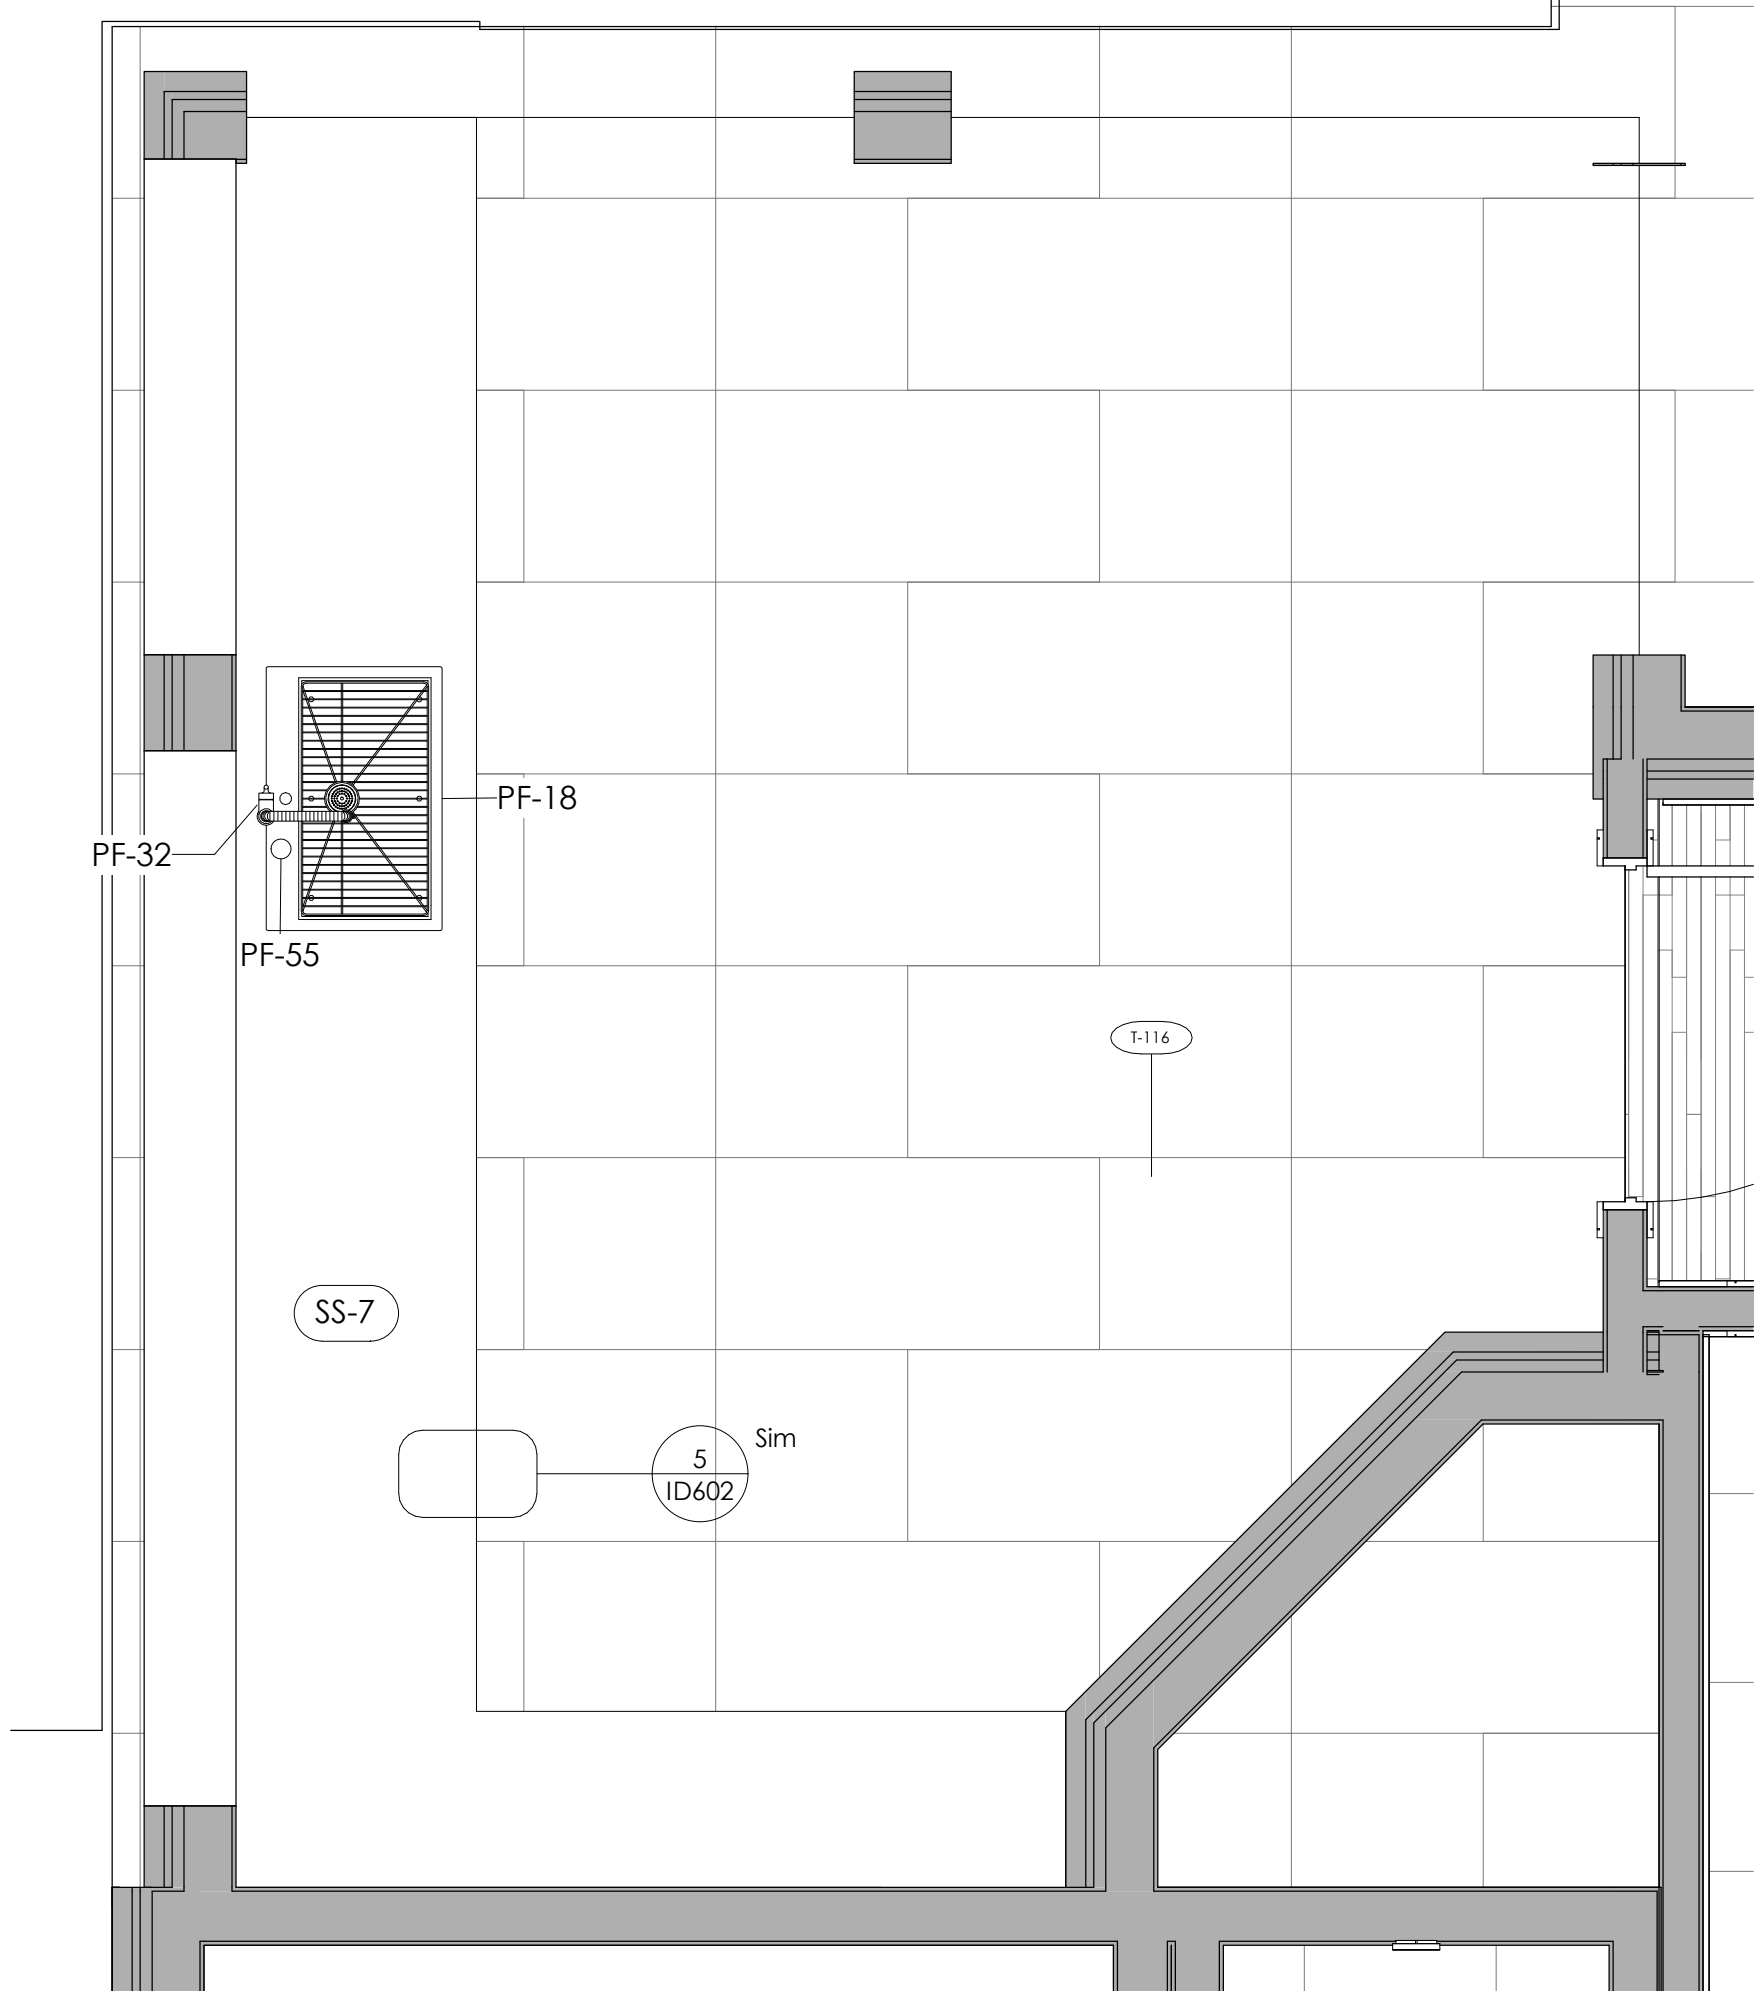

1 LEVEL 1 - OUTDOOR KITCHEN
1/2" = 1'-0"

NOTE: REFERENCE CABINET SHOP DRAWINGS FOR ALL CABINETRY DIMENSIONS AND DETAILS



500 Madison unit 107,
Nashville, Tennessee 37208
w: murphymaudeinteriors.com
p: (901) 848-6402
copyright 2021

CLIENT
MR. AND MRS. CLIENT

PROJECT LOCATION
94 CUMBERLAND,
MEMPHIS, TN

PROJECT NAME
PERSONAL RESIDENCE









DATE ISSUED
DRAWING SCALE
8/14/2023
As indicated

DRAWING TITLE
ENLARGED PLANS -
PANTRY, SCULLERY,
OUTDOOR KITCHEN


REVISIONS:
NUMBER DATE DESCRIPTION

SUPPLEMENTAL INTERIOR DESIGN
DOCUMENT
ID406


SOLID SURFACE SCHEDULE			
TAG	ROOM	LOCATION	PRODUCT
SS-1	KITCHEN	Kitchen Perimeter	TO BE DETERMINED
SS-1	KITCHEN	Kitchen Perimeter	TO BE DETERMINED
SS-1	KITCHEN	Kitchen Perimeter	TO BE DETERMINED
SS-2	KITCHEN	Kitchen Island	TO BE DETERMINED
SS-3	SCULLERY	Countertop	TO BE DETERMINED
SS-4	BAR	Countertop	Cambria - Charlestown
SS-5	POWDER ROOM	Countertop	Natural Stone - Calacatta Viola
SS-6	POOL BATH	Countertop	Saplen Stone - Bright Onyx
SS-7	OUTDOOR KITCHEN	Countertop	TO BE DETERMINED
SS-8	HIS BATH	Countertop	Saplen Stone - Rovere Buckskin
SS-9	UTILITY	Countertop	SaplenStone - PIASENTINA
SS-10	MASTER BATH	Countertop	Dekton - Morpheus
SS-11	GUEST BATH 3	Countertop	Cambria - Deligate
SS-12	GUEST BATH 2	Countertop	SaplenStone - Black Diamond
SS-13	GUEST BATH	Countertop	Cambria - Deligate
SS-14	KITCHEN	Kitchen Island Bar Height	TO BE DETERMINED

       TILE SCHEDULE - JASON'S OFFICE, POOL BATH, POWDER ROOM, AND UTILITY									
TYPE MARK	ROOM	LOCATION	MANUFACTURER	NAME	FINISH / SIZE	GROUT	IMAGE	LEVEL	
T-101	Pool Bath	FLOOR	Emil Ceramica	Piase	Spazzolata, 60 x 120 cm	G-103		LEVEL 1	
T-105	His Office	FLOOR	MIR Mosaics	JUMANJI	JUMANJI BLACK 12X25	G-100		LEVEL 1	
T-106	His Office	SHOWER FLOOR	MIR Mosaics	JUMANJI	BLACK MOSAIC	G-100		LEVEL 1	
T-107	His Office	SHOWER WALLS	MIR Mosaics	JUMANJI	BLACK 24X48	G-100		LEVEL 1	
T-108	His Office	ACCENT SHOWER WALLS	MIR Mosaics	JUMANJI	BLACK TEXTURES DECO	G-100		LEVEL 1	
T-117	First Floor	FLOOR	Contact Client for Specifications	Main First Floor Tile	Main First Floor Tile	G-100		LEVEL 1	
T-119	Powder Room	FLOOR	Zia Tile	Stars and Cross	Ash	G-102		LEVEL 1	
T-202	Scullery	BACKSPLASH	Emil Group	Ergon, Stone Talk, Martellata	Sand Martellata, 60 x 120 cm, 9.5 mm	G-101		LEVEL 1	


PLUMBING SCHEDULE - JASON'S OFFICE, POOL BATH, POWDER ROOM, AND UTILITY								
IMAG E	TAG	ROOM	QTY	MANUFACTURER	PRODUCT	MODEL #	DESCRIPTION	LEVEL
	PF-6	HIS OFFICE	1	HOUSE OF ROHL	Amahle Single Handle Tall Bathroom Faucet	AM02D11WM8	Matte black finish	LEVEL 1
	PF-7	HIS OFFICE	1	KOHLER Co.	Caxton Rectangle	K-20000-7	Black-Under-mount Bathroom Sink	LEVEL 1
	PF-4	HIS OFFICE + SECOND VALVE FOR HANDHELD	1	BRIZO Kitchen and Bath Company	KINTSU TempAssure Thermostatic Shower	T60206-BNXLHP, HL6006-BNX, R60000-UNBX	Brilliance Black Onyx finish, lever handle	LEVEL 1
	PF-9	HIS OFFICE + SECOND VALVE FOR HANDHELD	1	BRIZO Kitchen and Bath Company	ALLARIA™ Wall Mount Handshower	88867-BNX	Brilliance Black Onyx finish	LEVEL 1
	PF-1	MASTER BATHROOM, POOL BATH, POWDER ROOM, JASON'S OFFICE	4	Contact client for specifications	Toilet	Contact client for specifications	Contact client for specifications	LEVEL 1
	PF-22	POOL BATH	1	BRIZO Kitchen and Bath Company	ALLARIA™ Widespread Lavatory Faucet with Square Spout	65332LF-NKLHP, HL5333-NK-NM	Luxe nickel finish; T-Lever Handle	LEVEL 1
	PF-5	POOL BATH, MASTER BATHROOM, POWDER ROOM	4	KOHLER Co.	Caxton Rectangle	K-20000-0	White- Under-mount Bathroom Sink with Overflow and Clamp Assembly	LEVEL 1
	PF-16	POWDER ROOM	1	BRIZO Kitchen and Bath Company	INVARI™ Single-Handle Wall-Mount Lavatory Faucet - Less Handle 1.2 GPM	T65776LF-GLLHP-ECO, HX5876-GL	Wall Mount Lavatory Cross Handle Kit; Luxe GoldFinish	LEVEL 1
	PF-19	UTILITY	1	BRIZO Kitchen and Bath Company	ODIN® Semi-Professional Kitchen Faucet - Less Handle	63375LF-BLLHP, HLK175-BL	Matte black finish, with Pull-Down Faucet Metal Lever Handle Kit	LEVEL 1
	PF-35	UTILITY	1	KOHLER Co.	Cairn	K-8206-CM4	Matte Grey finish	LEVEL 1
Grand total: 16			16					

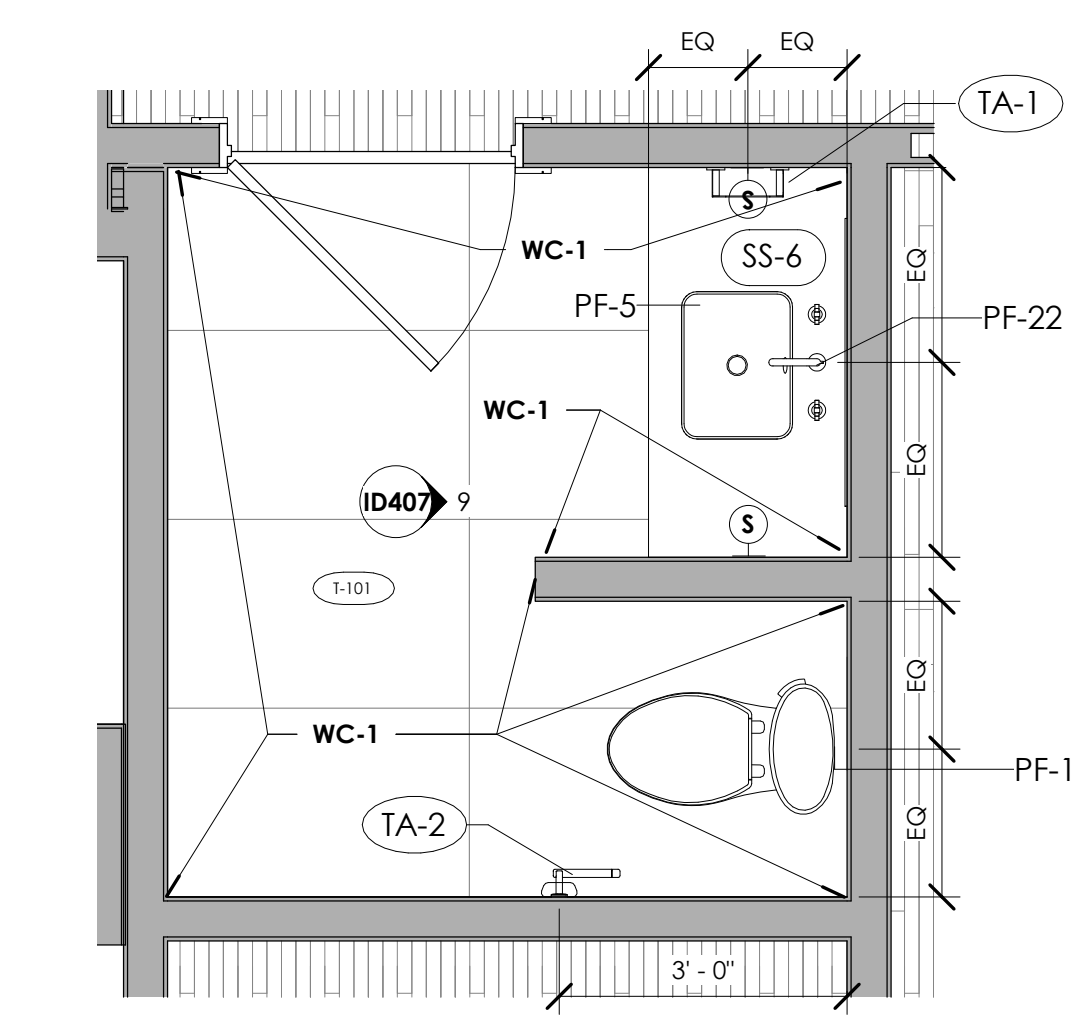


10 LEVEL 1 - POOL BATH
1/2" = 1'-0"

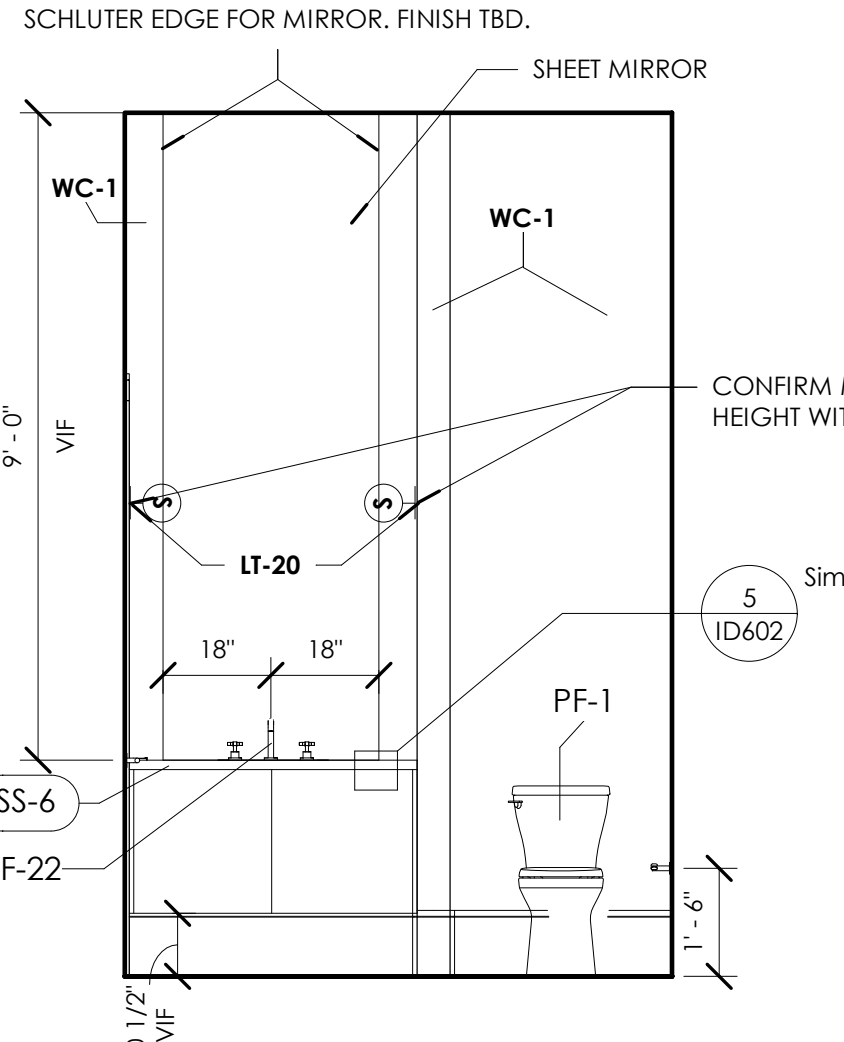


9 POOL BATH
3/8" = 1'-0"

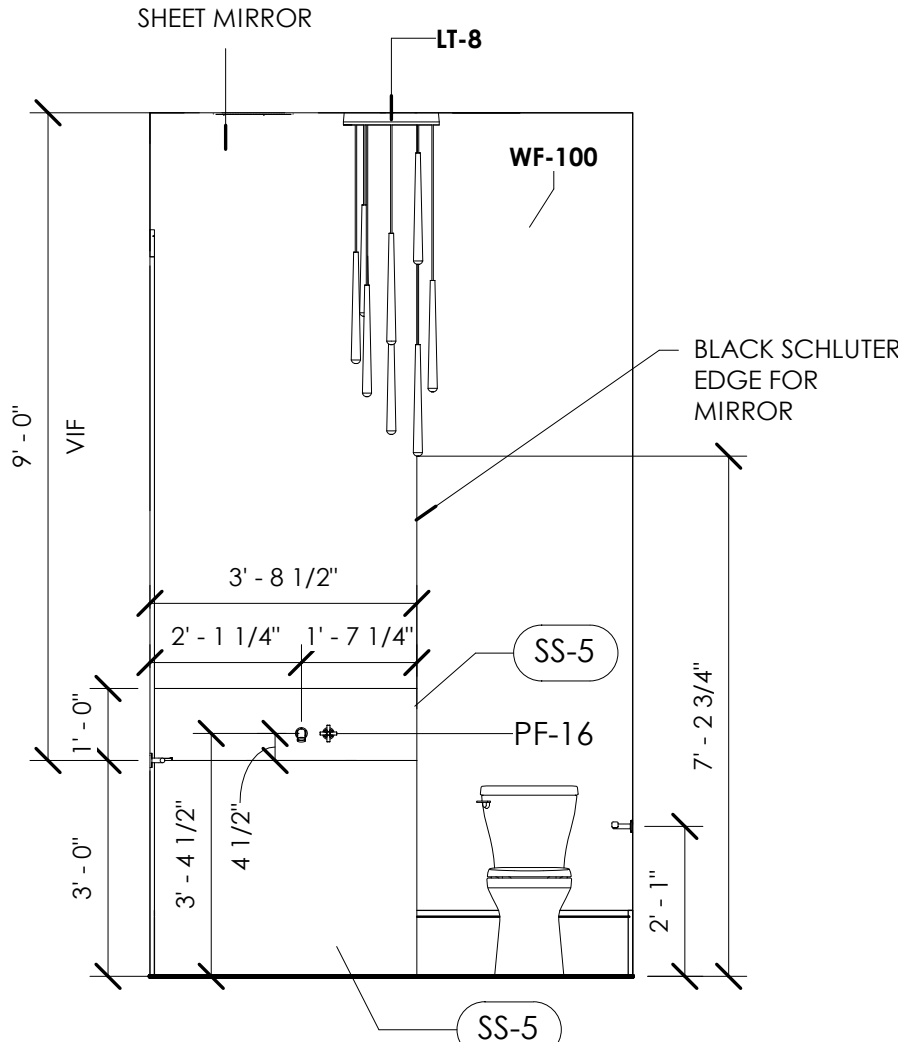


8 POWDER ROOM
3/8" = 1'-0"

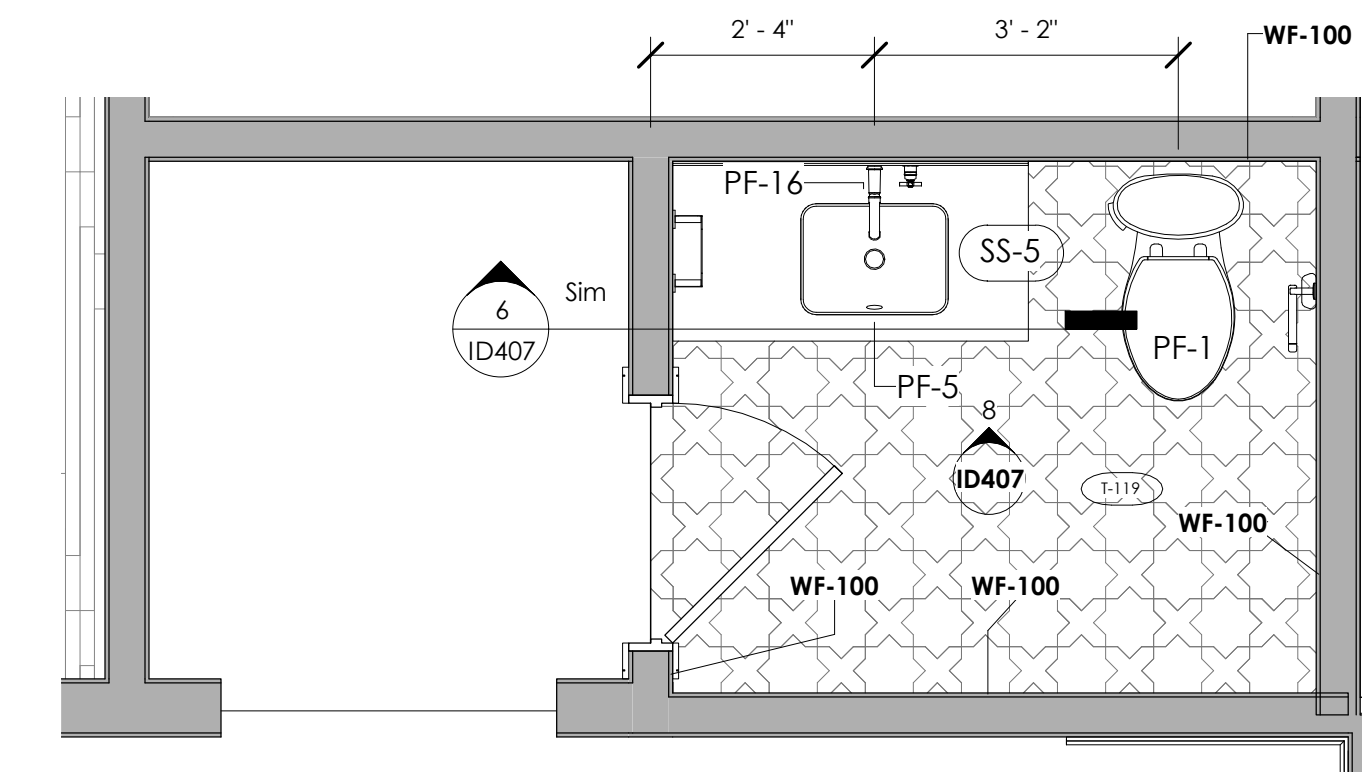


5 LEVEL 1 - POWDER BATH
1/2" = 1'-0"

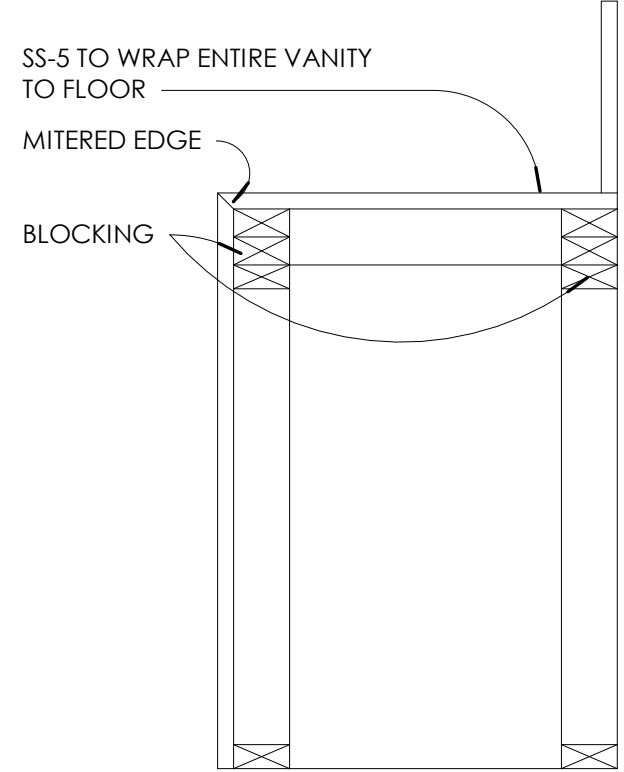


7 POWDER BATH VANITY
DETAIL A
1" = 1'-0"

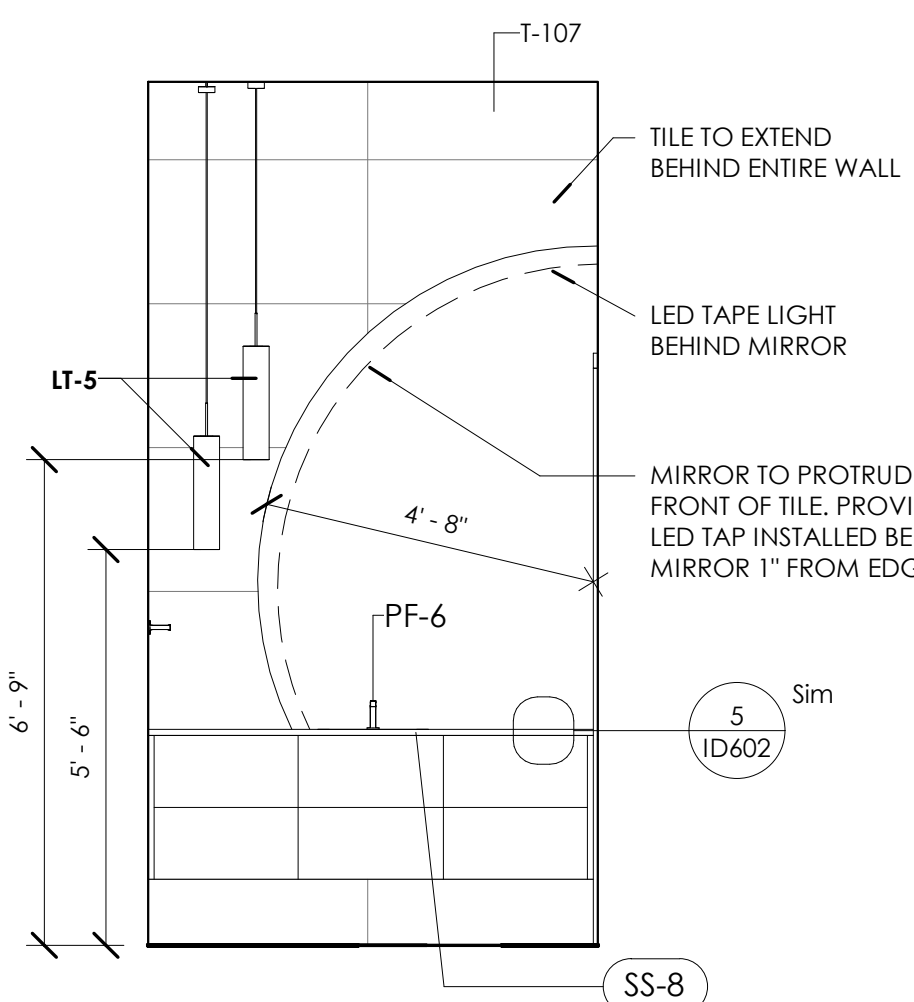


4 HIS BATH A
3/8" = 1'-0"

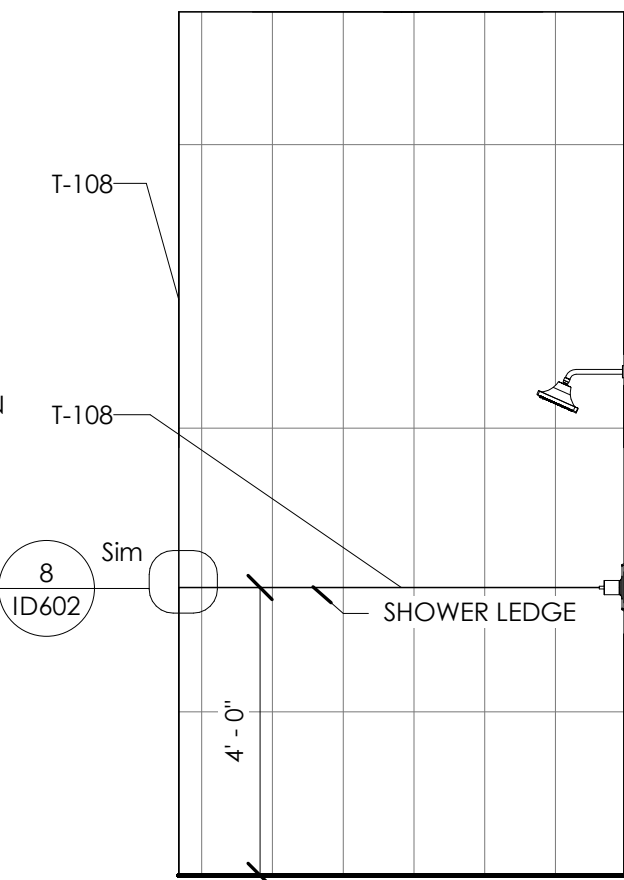


3 HIS BATH B
3/8" = 1'-0"

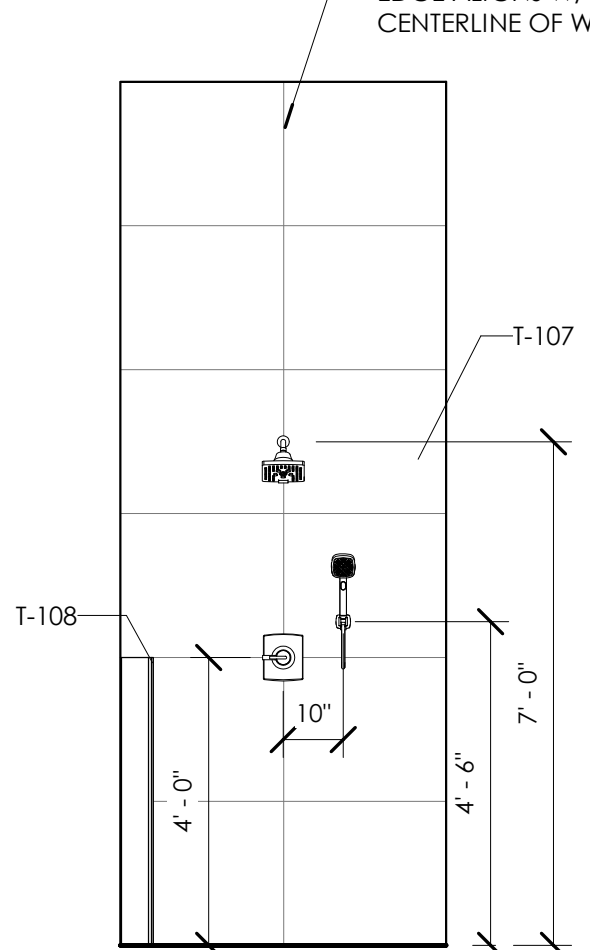

2 HIS BATH C
3/8" = 1'-0"

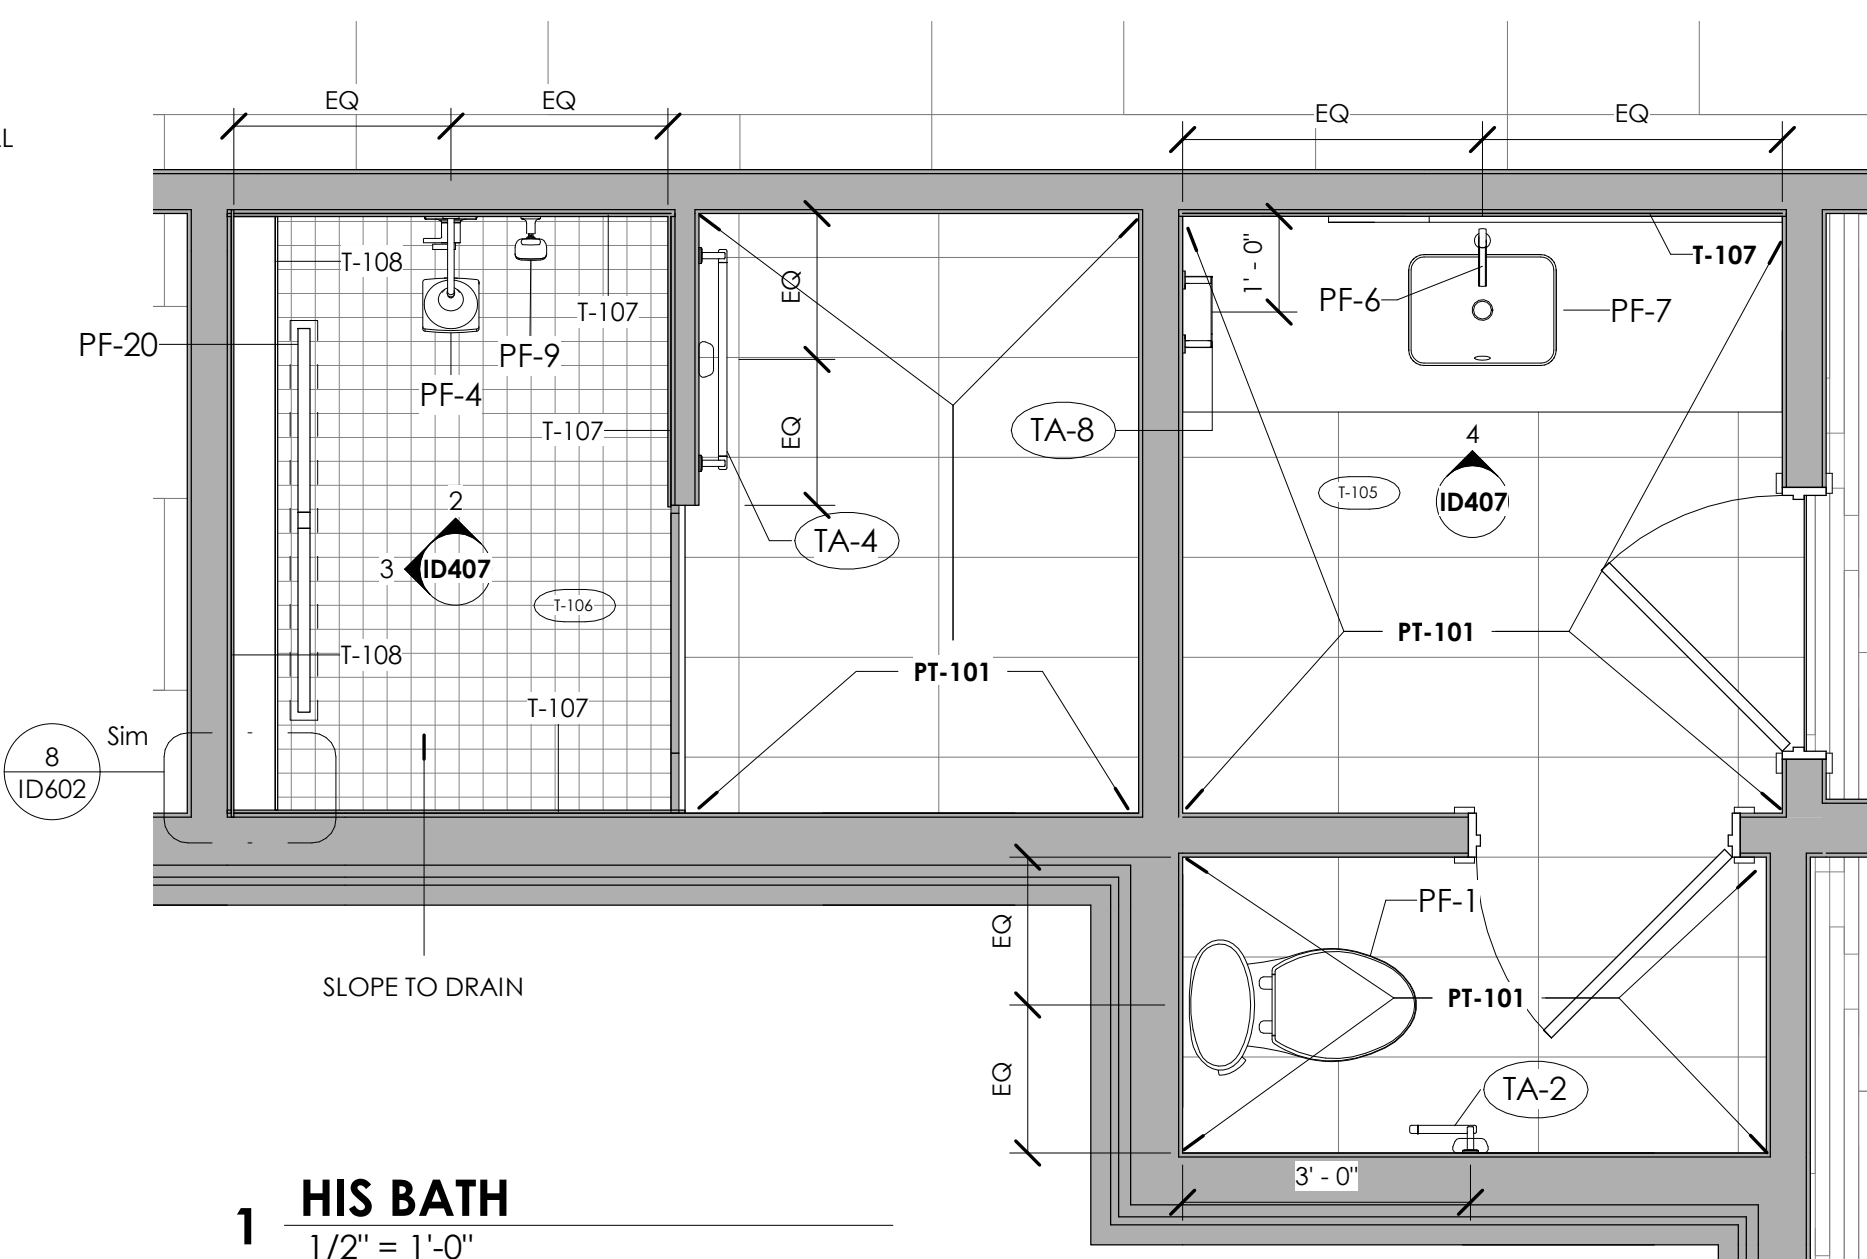

1 HIS BATH
1/2" = 1'-0"

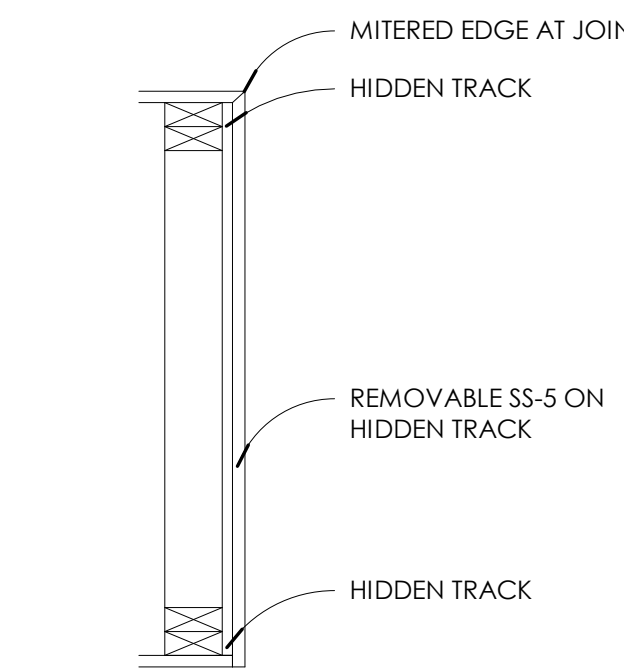

6 POWDER BATH VANITY
DETAIL B
1" = 1'-0"



MURPHY MAUDE
INTERIORS
500 Madison unit 107,
Nashville, Tennessee 37208
w: murphymaudeinteriors.com
p: (901) 848-6402
copyright 2021

CLIENT
MR. AND MRS. CLIENT
PROJECT LOCATION
94 CUMBERLAND,
MEMPHIS, TN


PROJECT NAME
PERSONAL RESIDENCE

DATE ISSUED
DRAWING SCALE
8/14/2023
As Indicated


DRAWING TITLE
ENLARGED PLANS - FIRST
FLOOR BATHROOMS

REVISIONS:
NUMBER DATE DESCRIPTION


SUPPLEMENTAL INTERIOR DESIGN
DOCUMENT
ID407

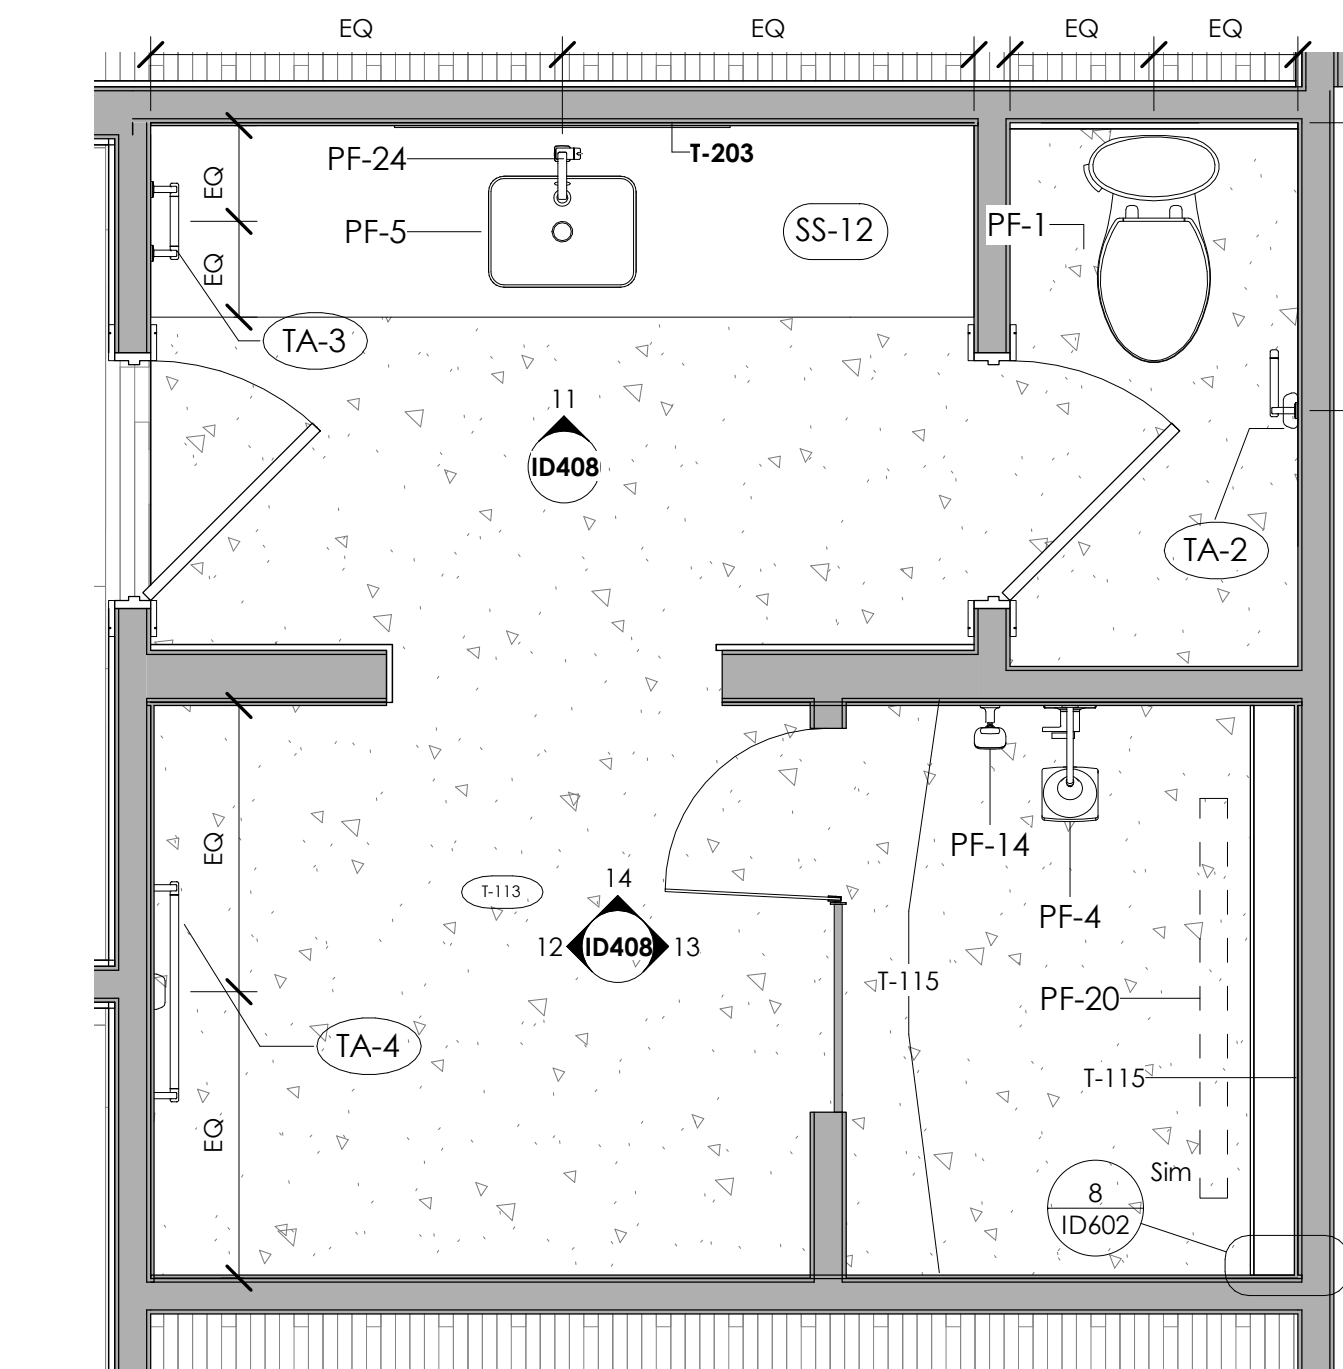


10 LEVEL 2 - GUEST BATH 2
1/2" = 1'-0"

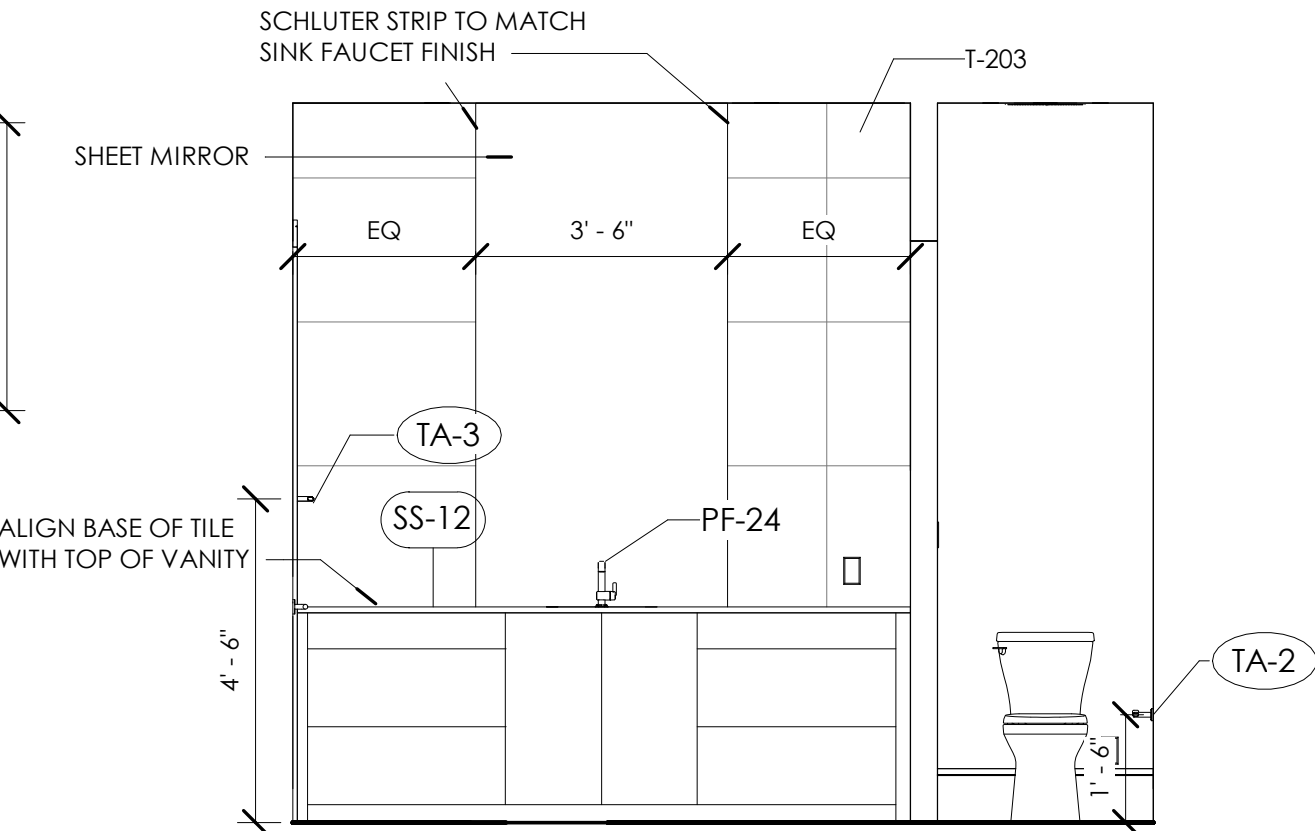


11 GUEST BATH 2 A
3/8" = 1'-0"

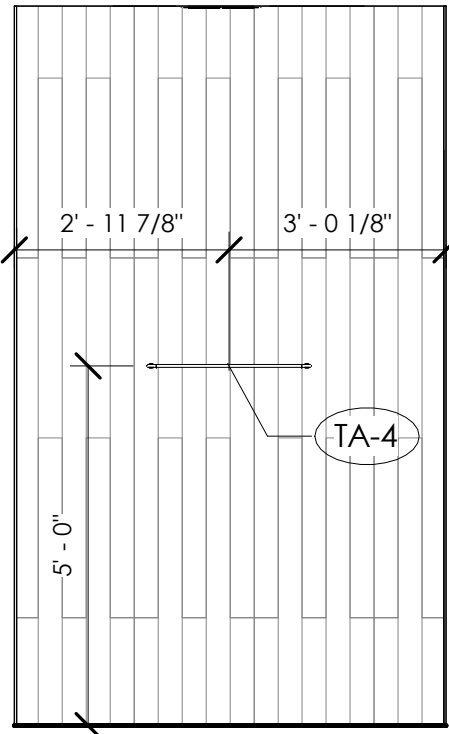


12 GUEST BATH 2 D
3/8" = 1'-0"

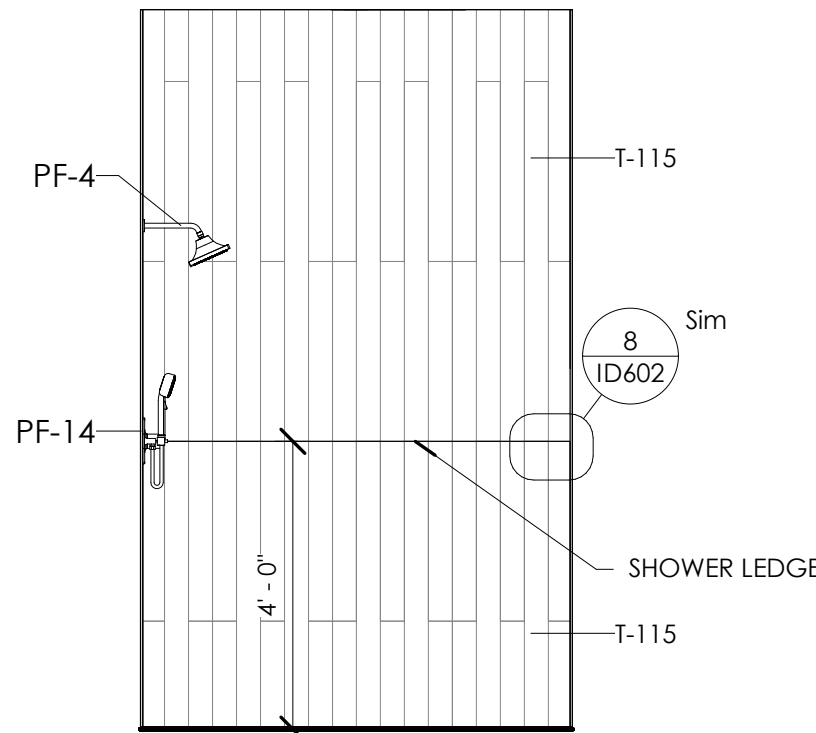


13 GUEST BATH 2 C
3/8" = 1'-0"

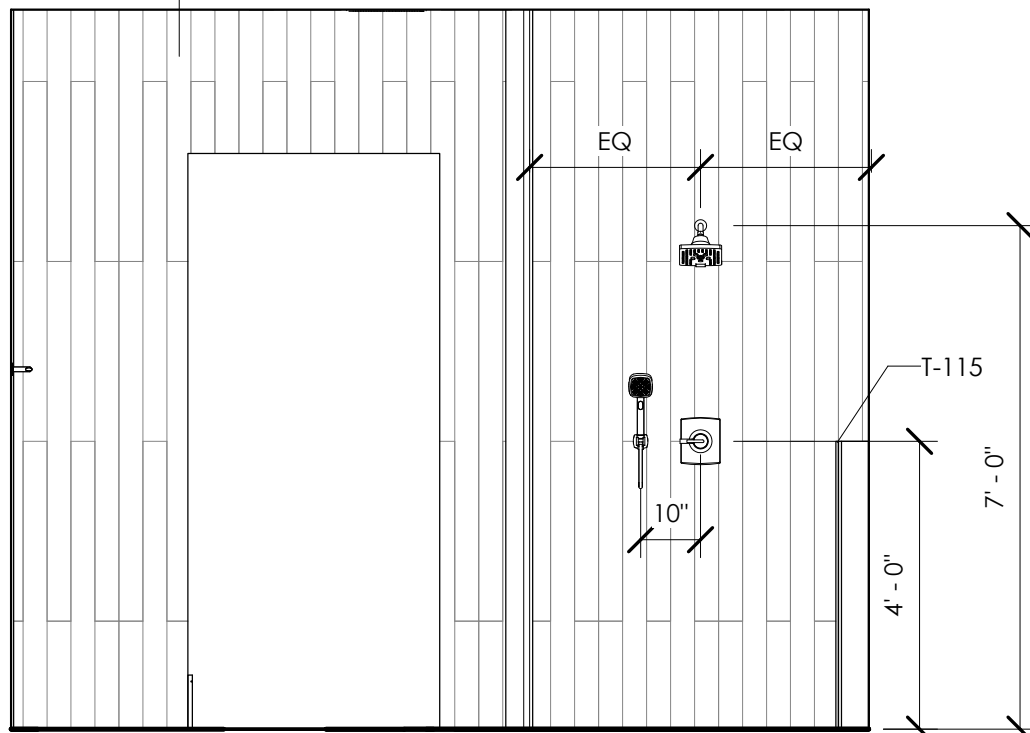


14 GUEST BATH 2 B
3/8" = 1'-0"

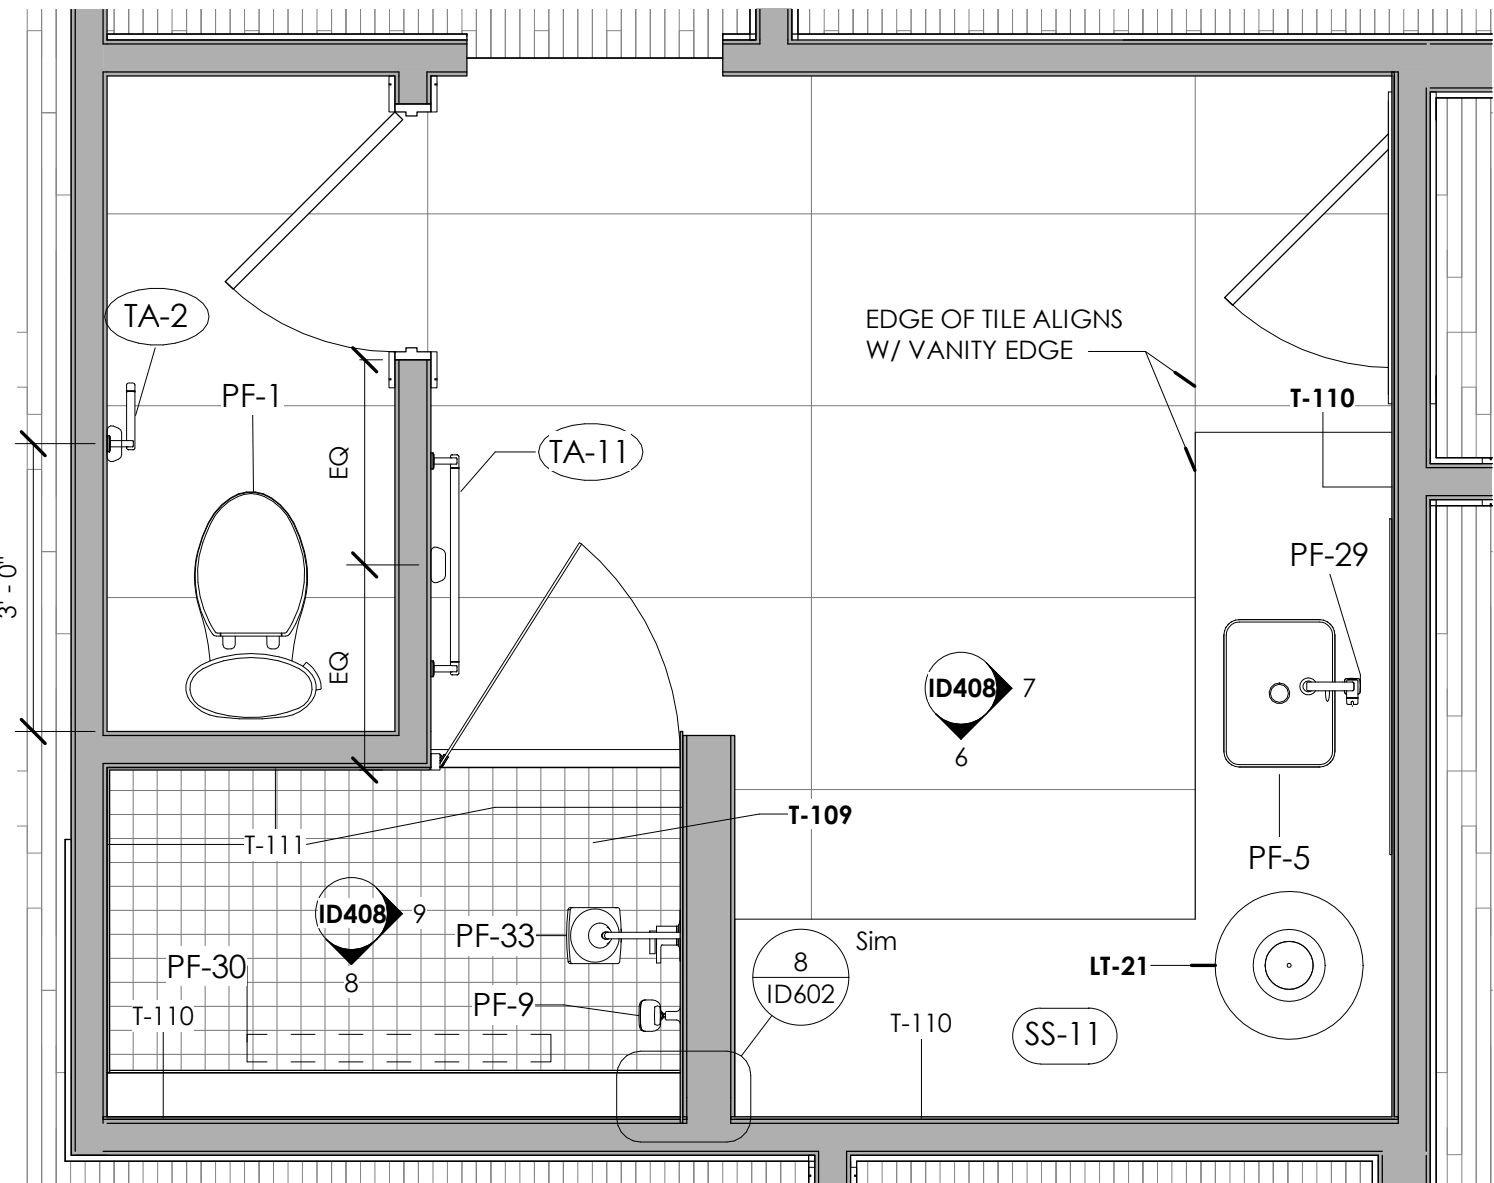


5 LEVEL 2 - GUEST BATH 3
1/2" = 1'-0"

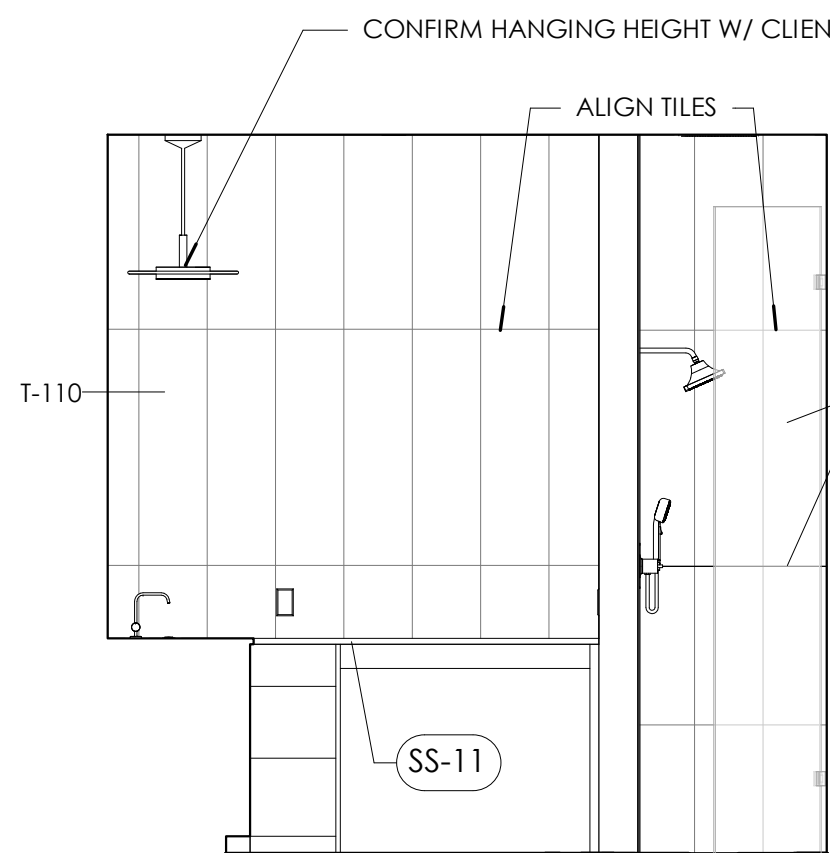


6 GUEST BATH 3 E
3/8" = 1'-0"

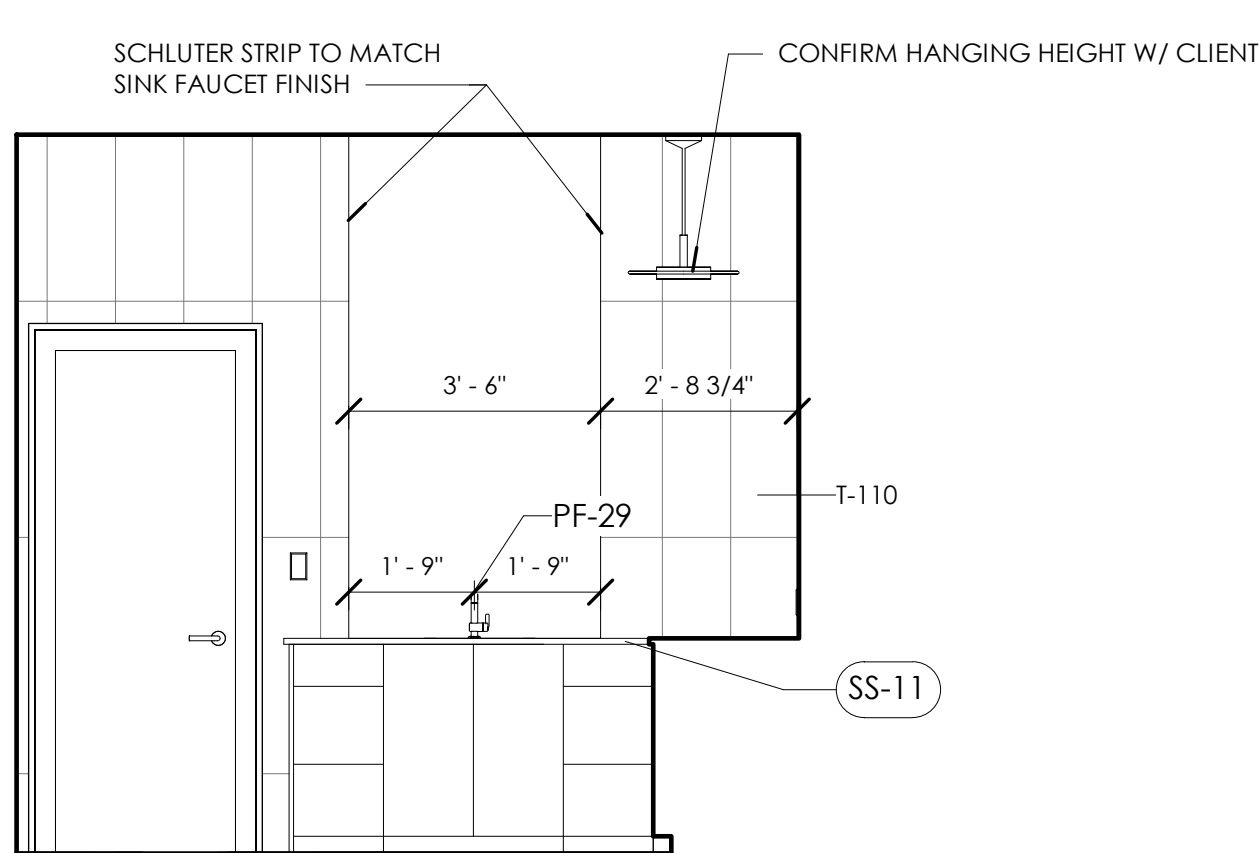


7 GUEST BATH 3 D
3/8" = 1'-0"

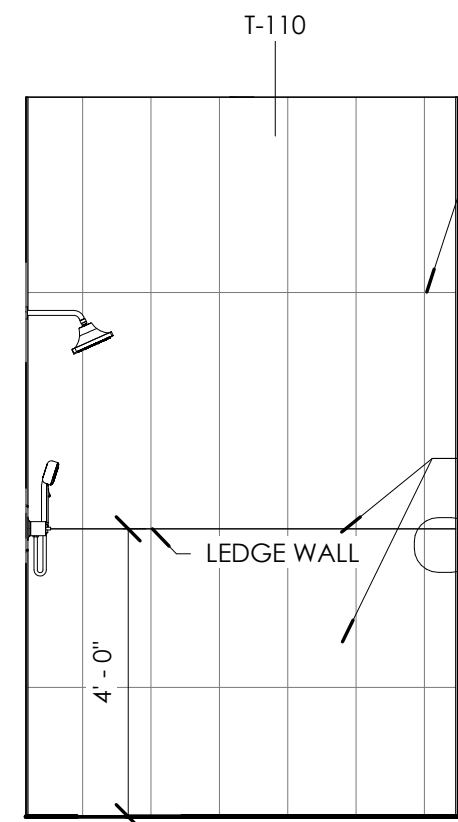


8 GUEST BATH 3 A
3/8" = 1'-0"

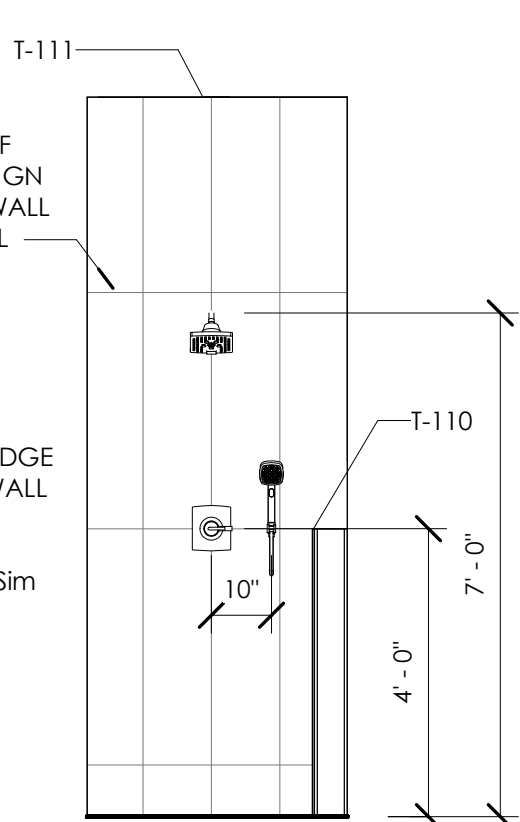

9 GUEST BATH 3 B
3/8" = 1'-0"

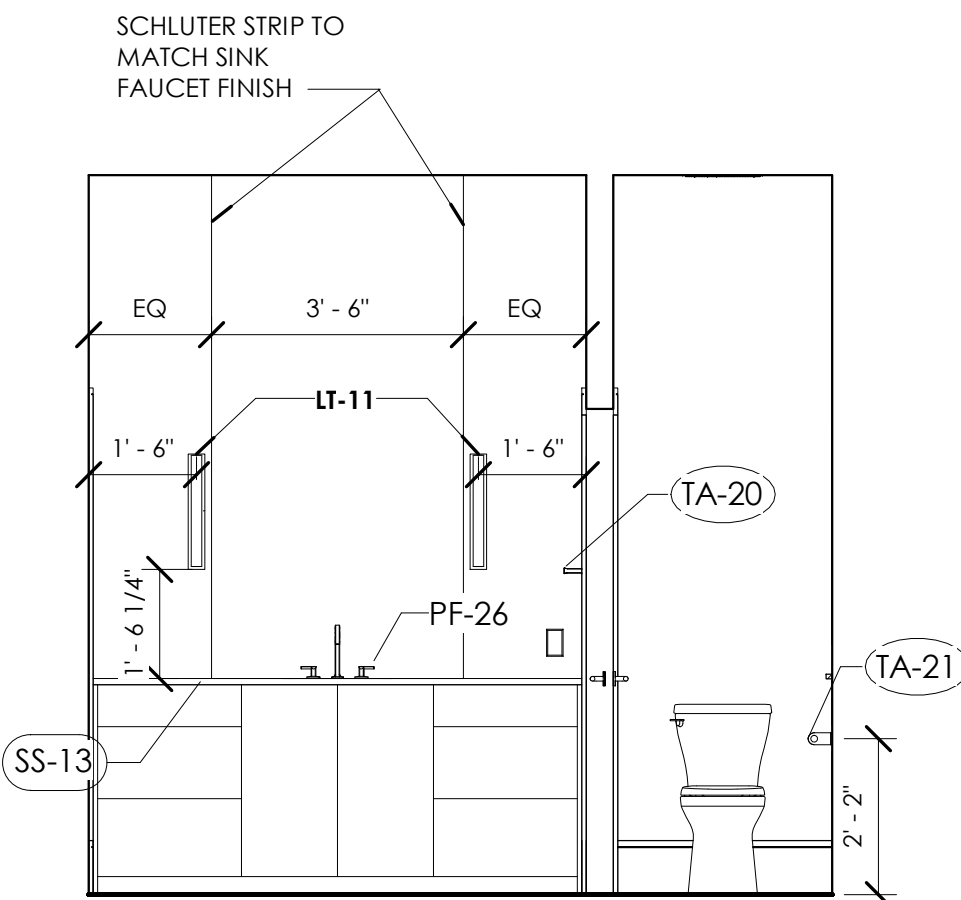

4 GUEST BATH A
3/8" = 1'-0"

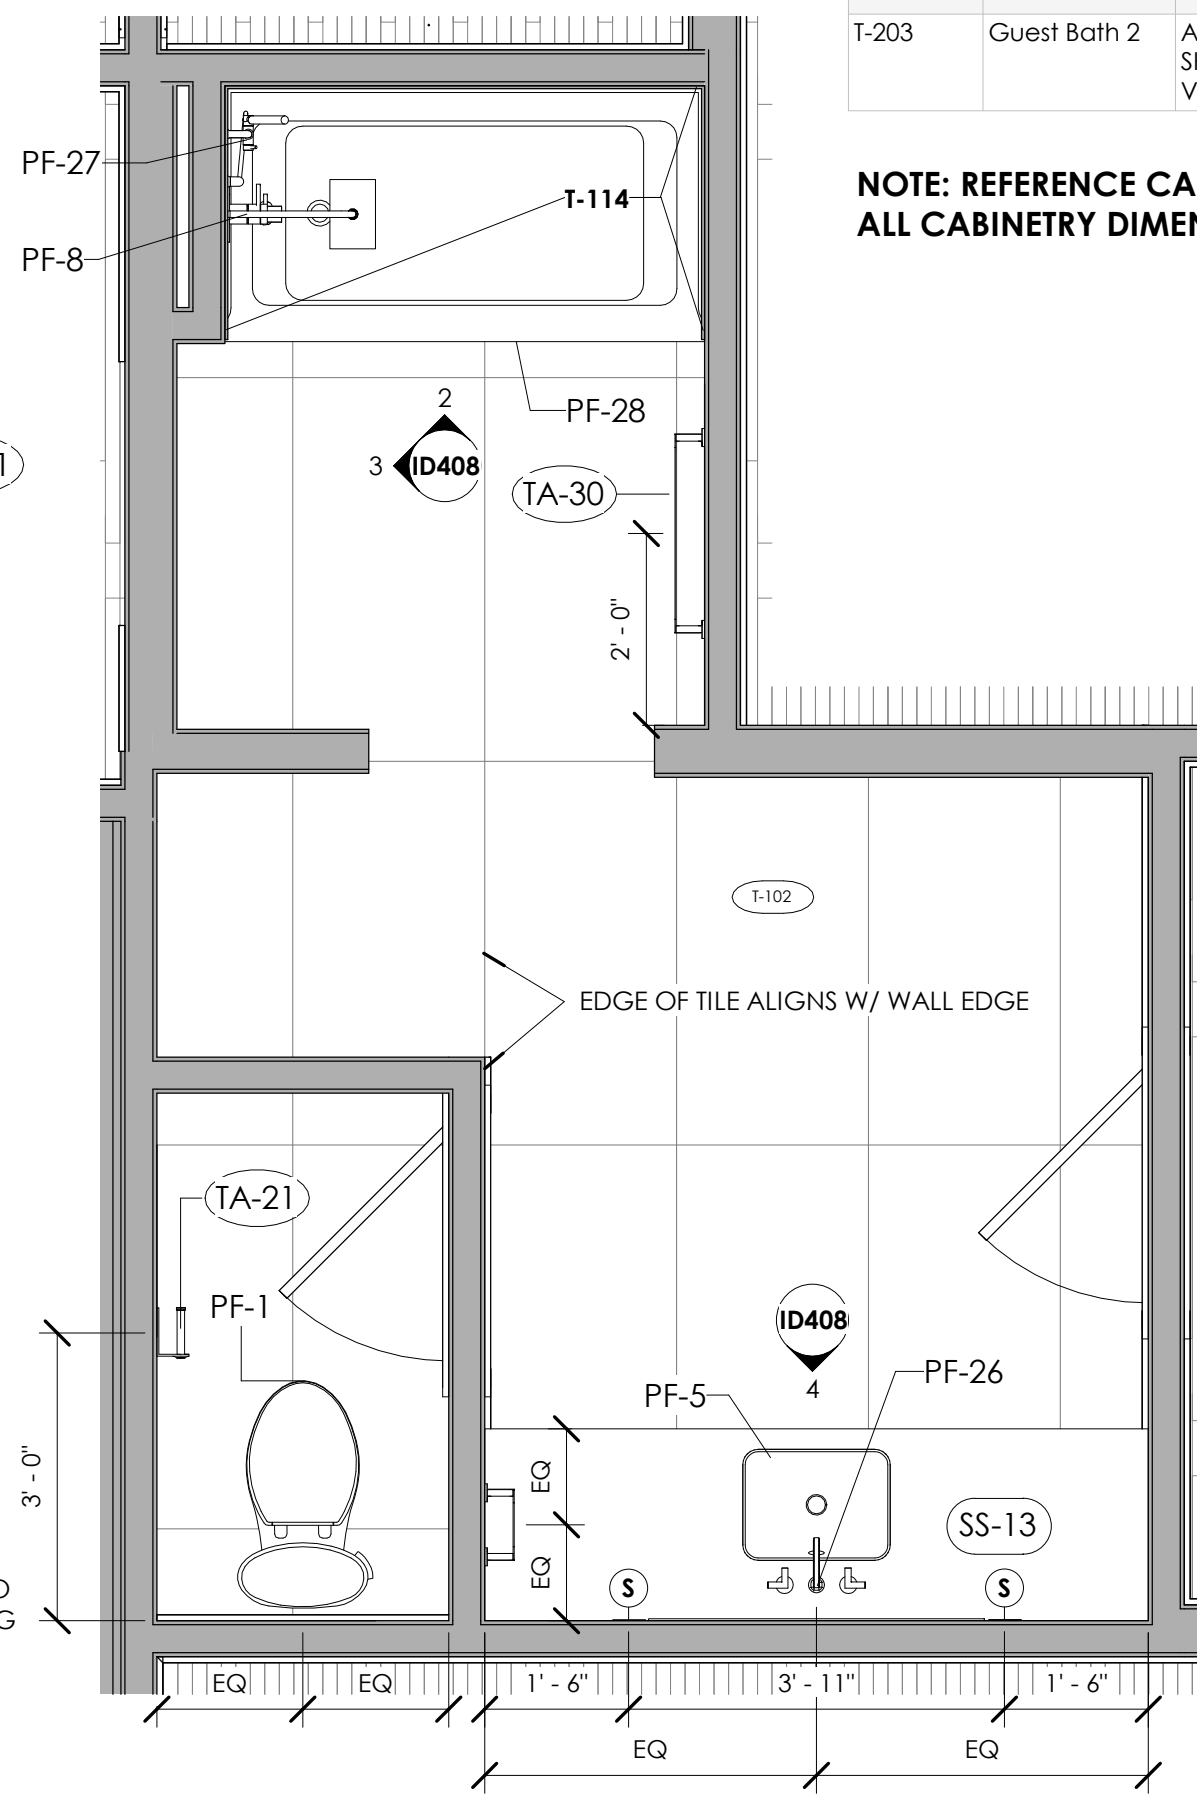

1 LEVEL 2 - GUEST BATH
1/2" = 1'-0"

PLUMBING FIXTURES SCHEDULE LEVEL 02								
IMA GE	TAG	ROOM	QTY	MANUFACTURER	PRODUCT	MODEL #	DESCRIPTION	LEVEL
	PF-1	ALL GUEST BATHS	3	Contact client for specifications	Toilet	Contact client for specifications	Contact client for specifications	LEVEL 2
	PF-5	ALL GUEST BATHS	3	KOHLER Co.	Cafox Rectangle	K-20000-0	White undermount bathroom sink with overflow and clamp assembly	LEVEL 2
	PF-8	GUEST BATH	1	BRIZO	SIDERNA® TempAssure® Thermostatic Tub/Shower Trim	T60480-BN-2.5, R60000-UNBX	Brushed nickel finish	LEVEL 2
	PF-26	GUEST BATH	1	BRIZO	Widespread Lavatory Faucet With Arc Spout - Less Handles 1.2 GPM	65306LF-NKLHP-ECO, HX5306-NK	Luxe nickel finish, widespread lavatory cross handle	LEVEL 2
	PF-27	GUEST BATH	1	BRIZO Kitchen and Bath Company	SIDERNA Single-Function Wall Mount Hand Shower	88775-BN	Brushed nickel finish	LEVEL 2
	PF-28	GUEST BATH	1	KOHLER Co.	Bellwether	K-875-0	60in x 32in alcove bath with integral apron and left-hand drain	LEVEL 2
	PF-4	GUEST BATH 2	1	BRIZO Kitchen and Bath Company	KINTSU TempAssure Thermostatic Shower	T60206-BNXLHP, HL6006-BNX, R60000-UNBX	Brilliance Black Onyx finish, lever handle	LEVEL 2
	PF-20	GUEST BATH 2	1	Kohler	Linear drain grate with perforated pattern	K-80660-BL	2.5 x 48 drain in matte black	LEVEL 2
	PF-24	GUEST BATH 2	1	BRIZO Kitchen and Bath Company	ALLARIA Single-Handle Lavatory Faucet	65067LF-BNX-ECO	Brilliance Black Onyx finish	LEVEL 2
	PF-9	GUEST BATH 2 + SECOND VALVE FOR HANDHELD	1	BRIZO Kitchen and Bath Company	ALLARIA™ Wall Mount Handshower	88867-NK	Luxe nickel finish	LEVEL 2
	PF-29	GUEST BATH 3	1	BRIZO Kitchen and Bath Company	ALLARIA Single-Handle Lavatory Faucet	65067LF-NK-ECO	Luxe nickel finish	LEVEL 2
	PF-30	GUEST BATH 3	1	Kohler	Linear drain grate with perforated pattern	K-80662-SH	1.25 x 36 linear drain grate drain in bright silver	LEVEL 2
	PF-33	GUEST BATH 3	1	BRIZO Kitchen and Bath Company	KINTSU TempAssure Thermostatic Shower	T60206-NKLHP, HL6006-NK, R60000-UNBX	Luxe nickel finish, lever handle	LEVEL 2
	PF-14	GUEST BATH 3 + SECOND VALVE FOR HANDHELD	1	BRIZO Kitchen and Bath Company	ALLARIA™ Wall Mount Handshower	88867-BNX	Brilliance Black Onyx finish	LEVEL 2
Grand total: 18			18					

TILE SCHEDULE LEVEL 02								
TYPE MARK	ROOM	LOCATION	MANUFACTOR	NAME	FINISH / SIZE	GROUT	IMAG E	LEVEL
T-102	Guest Bath	FLOOR	Emil Group	Grain Stone, Ergon	Rough Grain - White, 60 x 120 cm	G-104		LEVEL 2
T-109	Guest Bath 3	SHOWER FLOOR	Emil Group	Grain Stone, Ergon	SAND MOSAICO 3X3	G-104		LEVEL 2
T-110	Guest Bath 3	ACCENT SHOWER WALL, VANITY WALLS	MIR Mosaics	ATLANTIS	WHITE DECO	G-106		LEVEL 2
T-111	Guest Bath 3	SHOWER WALLS	MIR Mosaics	ATLANTIS	WHITE 12x40	G-105		LEVEL 2
T-113	Guest Bath 2	FLOOR	Tile Bar	Cobblestone	Obsidian Black Pebble Polished	G-100		LEVEL 2
T-114	Guest Bath	SHOWER WALLS	Emil Group	Soft Stone by Provenza	Grey Ash Naturale, 60 x 120 cm	G-104		LEVEL 2
T-115	Guest Bath 2	SHOWER WALLS	Atlas Concorde	Entice	Ash Oak Elegant, Matte, 18.5 cm x 150 cm	G-107		LEVEL 2
T-203	Guest Bath 2	ACCENT SHOWER WALL, VANITY WALLS	Tile Bar	Kenridge	Ribbon Black 24x48	G-100		LEVEL 2

NOTE: REFERENCE CABINET SHOP DRAWINGS FOR ALL CABINETRY DIMENSIONS AND DETAILS



500 Madison unit 107,
Nashville, Tennessee 37208
w: murphymaudeinteriors.com
p: (901) 848-6402
copyright 2021

CLIENT
MR. AND MRS. CLIENT

PROJECT LOCATION
94 CUMBERLAND,
MEMPHIS, TN


















 






PROJECT NAME
PERSONAL RESIDENCE



DATE ISSUED
DRAWING SCALE
8/14/2023
As indicated

 
 

 
 

 


 


 

 
 


DRAWING TITLE
ENLARGED PLANS -
SECOND FLOOR
BATHROOMS

REVISIONS:
NUMBER DATE DESCRIPTION

SUPPLEMENTAL INTERIOR DESIGN
DOCUMENT
ID408

PLUMBING FIXTURE SCHEDULE LEVEL 01								
IMAGE	TAG	ROOM	QTY	MANUFACTURER	PRODUCT	MODEL #	DESCRIPTION	LEVEL
	PF-6	HIS OFFICE	1	HOUSE OF ROHL	Amahle Single Handle Tall Bathroom Faucet	AM02D11WMB	Matte black finish	LEVEL 1
	PF-7	HIS OFFICE	1	KOHLER Co.	Caxton Rectangle	K-20000-7	Black-Under-mount Bathroom Sink	LEVEL 1
	PF-4	HIS OFFICE + SECOND VALVE FOR HANDHELD	1	BRIZO Kitchen and Bath Company	KINTSU TempAssure Thermostatic Shower	T60206-BNXLHP, HL6006-BNX, R60000-UNBX	Brilliance Black Onyx finish, lever handle	LEVEL 1
	PF-9	HIS OFFICE + SECOND VALVE FOR HANDHELD	1	BRIZO Kitchen and Bath Company	ALLARIA™ Wall Mount Handshower	88867-BNX	Brilliance Black Onyx finish	LEVEL 1
	PF-10	KITCHEN	1	Elkay	Elkay Quartz Luxe Single Bowl Farmhouse Sink	ELXUFP3620	35-7/8 inch X 20-15/16 inch X 9 inch with perfect drain, color Caviar	LEVEL 1
	PF-21	KITCHEN	1	House of Rohl	Eclissi Pull-Down Kitchen Faucet	EC55D1MB	Matte Black finish; C-Spout Less Handle	LEVEL 1
	PF-11	MASTER BATHROOM	2	HOUSE OF ROHL	Amahle Widespread Bathroom Faucet With C-Spout	AM08D31WPN	Polished Nickel	LEVEL 1
	PF-12	MASTER BATHROOM	1	HOUSE OF ROHL	Knurled Single Hole Floor Mount Tub Filler	TMB06HF1LMPN	Polished nickel finish	LEVEL 1
	PF-13	MASTER BATHROOM	1	BRIZO Kitchen and Bath Company	ESSENTIAL™ SHOWER SERIES Linear Square Multi-Function Hand Shower	74792-PN, 88099-PN	Polished nickel finish	LEVEL 1
	PF-15	MASTER BATHROOM	1	BRIZO Kitchen and Bath Company	ESSENTIAL™ SHOWER SERIES 7" Linear Round H2Okinctic® Multi-Function Wall Mount Showerhead	87492-PN-2.5, RP74448PN,	Linear Round Multi-Function Wall Mount Showerhead	LEVEL 1
	PF-23	MASTER BATHROOM	1	KOHLER Co.	Stargaze	K-1959-GHW-0	72inch x 36inch freestanding bath with straight shroud and center drain	LEVEL 1
	PF-31	MASTER BATHROOM	1	Kohler	Linear drain grate with tile-in panel	K-80651-BNK	1.25 x 48 drain in bright silver	LEVEL 1
	PF-1	MASTER BATHROOM, POOL BATH, POWDER ROOM, JASONS OFFICE	4	Contact client for specifications	Toilet	Contact client for specifications	Contact client for specifications	LEVEL 1
	PF-18	OUTDOOR KITCHEN	1	KOHLER Co.	Vault	K-3821-1-NA	33inch x 22inch x 9-5/16inch top-/under-mount large single-bowl kitchen sink with single faucet hole	LEVEL 1
	PF-32	OUTDOOR KITCHEN	1	KOHLER Co.	Purist	K-24982-CP	Semiprofessional kitchen sink faucet	LEVEL 1
	PF-22	POOL BATH	1	BRIZO Kitchen and Bath Company	ALLARIA™ Widespread Lavatory Faucet with Square Spout Widespread Lavatory Faucet with Square Spout	65332LF-NKLHP, HL5333-NK-NM	Luxe nickel finish; T-Lever Handle	LEVEL 1
	PF-5	POOL BATH, MASTER BATHROOM, POWDER ROOM	4	KOHLER Co.	Catox Rectangle	K-20000-0	White- Under-mount Bathroom Sink with Overflow and Clamp Assembly	LEVEL 1
	PF-16	POWDER ROOM	1	BRIZO Kitchen and Bath Company	INVARI™ Single-Handle Wall-Mount Lavatory Faucet - Less Handle 1.2 GPM	T65776LF-GLLHP-ECO, HX5876-GL	Wall Mount Lavatory Cross Handle Kit; Luxe GoldFinish	LEVEL 1
	PF-17	SCULLERY	1	BRIZO Kitchen and Bath Company		64053LF-BLGL	Square Spout and Knurled Handle; Matte Black / Luxe Gold finish	LEVEL 1
	PF-34	SCULLERY	1	KOHLER Co.	Caim	K-8206-CM7	Matte Graphite finish	LEVEL 1
	PF-19	UTILITY	1	BRIZO Kitchen and Bath Company	ODIN® Semi-Professional Kitchen Faucet - Less Handle	63375LF-BLLHP, HLK175-BL	Matte black finish, with Pull-Down Faucet Metal Lever Handle Kit	LEVEL 1
	PF-35	UTILITY	1	KOHLER Co.	Caim	K-8206-CM4	Matte Grey finish	LEVEL 1
	PF-2	WET BAR	1	HOUSE OF ROHL	Campo Deck Mount Bridge Faucet	A3358ILWSMB-2	Matte Black finish, U-Spout 3 Leg Bridge Faucet With Sidespray - Industrial Metal Lever Handle	LEVEL 1
	PF-3	WET BAR	1	KOHLER Co.	Riverby	K-5479-SU-7	Black - 25in undermount single-bowl kitchen sink	LEVEL 1
Grand total: 31			31					

PLUMBING FIXTURES SCHEDULE LEVEL 02								
IMAGE	TAG	ROOM	QTY	MANUFACTURER	PRODUCT	MODEL #	DESCRIPTION	LEVEL
	PF-1	ALL GUEST BATHS	3	Contact client for specifications	Toilet	Contact client for specifications	Contact client for specifications	LEVEL 2
	PF-5	ALL GUEST BATHS	3	KOHLER Co.	Catox Rectangle	K-20000-0	White undermount bathroom sink with overflow and clamp assembly	LEVEL 2
	PF-8	GUEST BATH	1	BRIZO	SIDERNA® TempAssure® Thermostatic Tub/Shower Trim	T60480-BN-2.5, R60000-UNBX	Brushed nickel finish	LEVEL 2
	PF-26	GUEST BATH	1	BRIZO	Widespread Lavatory Faucet With Arc Spout - Less Handles 1.2 GPM	65306LF-NKLHP-ECO, HX5306-NK	Luxe nickel finish, widespread lavatory cross handle	LEVEL 2
	PF-27	GUEST BATH	1	BRIZO Kitchen and Bath Company	SIDERNA Single-Function Wall Mount Hand Shower	88775-BN	Brushed nickel finish	LEVEL 2
	PF-28	GUEST BATH	1	KOHLER Co.	Bellwether	K-875-0	60in x 32in alcove bath with integral apron and left-hand drain	LEVEL 2
	PF-4	GUEST BATH 2	1	BRIZO Kitchen and Bath Company	KINTSU TempAssure Thermostatic Shower	T60206-BNXLHP, HL6006-BNX, R60000-UNBX	Brilliance Black Onyx finish, lever handle	LEVEL 2
	PF-20	GUEST BATH 2	1	Kohler	Linear drain grate with perforated pattern	K-80660-BL	2.5 x 48 drain in matte black	LEVEL 2
	PF-24	GUEST BATH 2	1	BRIZO Kitchen and Bath Company	ALLARIA Single-Handle Lavatory Faucet	65067LF-BNX-ECO	Brilliance Black Onyx finish	LEVEL 2
	PF-9	GUEST BATH 2 + SECOND VALVE FOR HANDHELD	1	BRIZO Kitchen and Bath Company	ALLARIA™ Wall Mount Handshower	88867-NK	Luxe nickel finish	LEVEL 2
	PF-29	GUEST BATH 3	1	BRIZO Kitchen and Bath Company	ALLARIA Single-Handle Lavatory Faucet	65067LF-NK-ECO	Luxe nickel finish	LEVEL 2
	PF-30	GUEST BATH 3	1	Kohler	Linear drain grate with perforated pattern	K-80662-SH	1.25 x 36 linear drain grate drain in bright silver	LEVEL 2
	PF-33	GUEST BATH 3	1	BRIZO Kitchen and Bath Company	KINTSU TempAssure Thermostatic Shower	T60206-NKLHP, HL6006-NK, R60000-UNBX	Luxe nickel finish, lever handle	LEVEL 2
	PF-14	GUEST BATH 3 + SECOND VALVE FOR HANDHELD	1	BRIZO Kitchen and Bath Company	ALLARIA™ Wall Mount Handshower	88867-BNX	Brilliance Black Onyx finish	LEVEL 2
Grand total: 18			18					

TILE SCHEDULE								
TYPE MARK	ROOM	LOCATION	MANUFACTOR	NAME	FINISH / SIZE	GROUT	IMAGE	LEVEL
T-101	Pool Bath	FLOOR	Emil Ceramica	Piase	Spazzolata, 60 x 120 cm	G-103		LEVEL 1
T-102	Guest Bath	FLOOR	Emil Group	Grain Stone, Ergon	Rough Grain - White, 60 x 120 cm	G-104		LEVEL 2
T-105	His Office	FLOOR	MIR Mosaics	JUMANJI	JUMANJI BLACK 12X25	G-100		LEVEL 1
T-106	His Office	SHOWER FLOOR	MIR Mosaics	JUMANJI	BLACK MOSAIC	G-100		LEVEL 1
T-107	His Office	SHOWER WALLS	MIR Mosaics	JUMANJI	BLACK 24X48	G-100		LEVEL 1
T-108	His Office	ACCENT SHOWER WALLS	MIR Mosaics	JUMANJI	BLACK TEXTURES DECO	G-100		LEVEL 1
T-109	Guest Bath 3	SHOWER FLOOR	Emil Group	Grain Stone, Ergon	SAND MOSAICO 3X3	G-104		LEVEL 2
T-110	Guest Bath 3	ACCENT SHOWER WALL, VANITY WALLS	MIR Mosaics	ATLANTIS	WHITE DECO	G-106		LEVEL 2
T-111	Guest Bath 3	SHOWER WALLS	MIR Mosaics	ATLANTIS	WHITE 12x40	G-105		LEVEL 2
T-113	Guest Bath 2	FLOOR	Tile Bar	Cobblestone	Obsidian Black Pebble Polished	G-100		LEVEL 2
T-114	Guest Bath	SHOWER WALLS	Emil Group	Salt Stone by Provenza	Grey Ash Naturale, 60 x 120 cm	G-104		LEVEL 2
T-115	Guest Bath 2	SHOWER WALLS	Atlas Concorde	Entice	Ash Oak Elegant, Matte, 18.5 cm x 150 cm	G-107		LEVEL 2
T-116	Outdoor	FLOOR	Contact Client for Specifications	Outdoor Floor	Outdoor Floor	G-100		LEVEL 1
T-117	<varies>	<varies>	<varies>	<varies>	<varies>	<varies>		<varies>
T-119	Powder Room	FLOOR	Zia Tile	Stars and Cross	Ash	G-102		LEVEL 1
T-200	Master Bathroom	FLOOR, SHOWER FLOOR	Cosentino	Dekton	Morpheus, 327 x 147 cm, 0.8 cm	G-100		LEVEL 1
T-201	Master Bathroom	SHOWER WALLS, VANITY WALLS	Cosentino	Dekton	Morpheus 327 x 147 cm, 0.8 cm	G-100		LEVEL 1
T-202	Scullery	BACKSPLASH	Emil Group	Ergon, Stone Talk, Martellata	Sand Martellata, 60 x 120 cm, 9.5 mm	G-101		LEVEL 1
T-203	Guest Bath 2	ACCENT SHOWER WALL, VANITY WALLS	Tile Bar	Kenridge	Ribbon Black 24x48	G-100		LEVEL 2
T-300		FLOOR	Emil Group	Grain Stone, Ergon	Rough Grain - Sand, 60 x 120 cm	G-104		

APPLIANCE SCHEDULE						
TAG	DESCRIPTION	MANUFACTURER	SKU	ROOM	LEVEL	COUNT
AP-1	36" Classic French Door	Subzero	CI3650UFD	SCULLERY	LEVEL 1	1
AP-2	24" Wolf Transitional E Series Stop Down	WOLF	MDD24TE-S-TH	SCULLERY	LEVEL 1	1
AP-3	30" Warming Drawer	Wolf	WWD30	SCULLERY	LEVEL 1	2
AP-4	48" 6 Burners, Charbroil	Wolf	SRT486C	KITCHEN	LEVEL 1	1
AP-5	48" Classic Side by side fridge/freezer, panel ready	Sub Zero	CL4850	KITCHEN	LEVEL 1	1
AP-6	Contemporary Series Stainless Steel Built in	Wolf	D030CMS	KITCHEN	LEVEL 1	1
AP-7	30" Designer refrigerator drawers, panel ready	Sub Zero	ID-30R	KITCHEN	LEVEL 1	1
AP-8	Built In, panel ready	Asko	DISHWASHER SKU HERE	SCULLERY	LEVEL 1	1
AP-9	15" Nugget ice maker	Scotsman	SCN60	KITCHEN	LEVEL 1	1
AP-10	48 x 19 stainless range hood insert, IB1200, 1200 cfm	FABER	INPL4819SSNB-B	KITCHEN	LEVEL 1	1

SOLID SURFACE SCHEDULE			
TAG	ROOM	LOCATION	PRODUCT
SS-1	KITCHEN	Kitchen Perimeter	TO BE DETERMINED
SS-1	KITCHEN	Kitchen Perimeter	TO BE DETERMINED
SS-1	KITCHEN	Kitchen Perimeter	TO BE DETERMINED
SS-2	KITCHEN	Kitchen Island	TO BE DETERMINED
SS-3	SCULLERY	Countertop	TO BE DETERMINED
SS-4	BAR	Countertop	Cambria - Charlestown
SS-5	POWDER ROOM	Countertop	Natural Stone - Calacatta Viola
SS-6	POOL BATH	Countertop	Sapient Stone - Bright Onyx
SS-7	OUTDOOR KITCHEN	Countertop	TO BE DETERMINED
SS-8	HIS BATH	Countertop	Sapient Stone - Ravere Buckskin
SS-9	UTILITY	Countertop	SapientStone - PIASENTINA
SS-10	MASTER BATH	Countertop	Dekton - Morpheus
SS-11	GUEST BATH 3	Countertop	Cambria - Deligate
SS-12	GUEST BATH 2	Countertop	SapientStone - Black Diamond
SS-13	GUEST BATH	Countertop	Cambria - Deligate
SS-14	KITCHEN	Kitchen Island Bar Height	TO BE DETERMINED



500 Madison unit 107,
Nashville, Tennessee 37208
w: murphymaudeinteriors.com
p: (901) 848-6402
copyright 2021

CLIENT
MR. AND MRS. CLIENT

PROJECT LOCATION
94 CUMBERLAND,
MEMPHIS, TN

PROJECT NAME
PERSONAL RESIDENCE

DATE ISSUED
DRAWING SCALE


8/14/2023

DRAWING TITLE


SCHEDULES

REVISIONS:
NUMBER DATE DESCRIPTION


SUPPLEMENTAL INTERIOR DESIGN
DOCUMENT
ID601

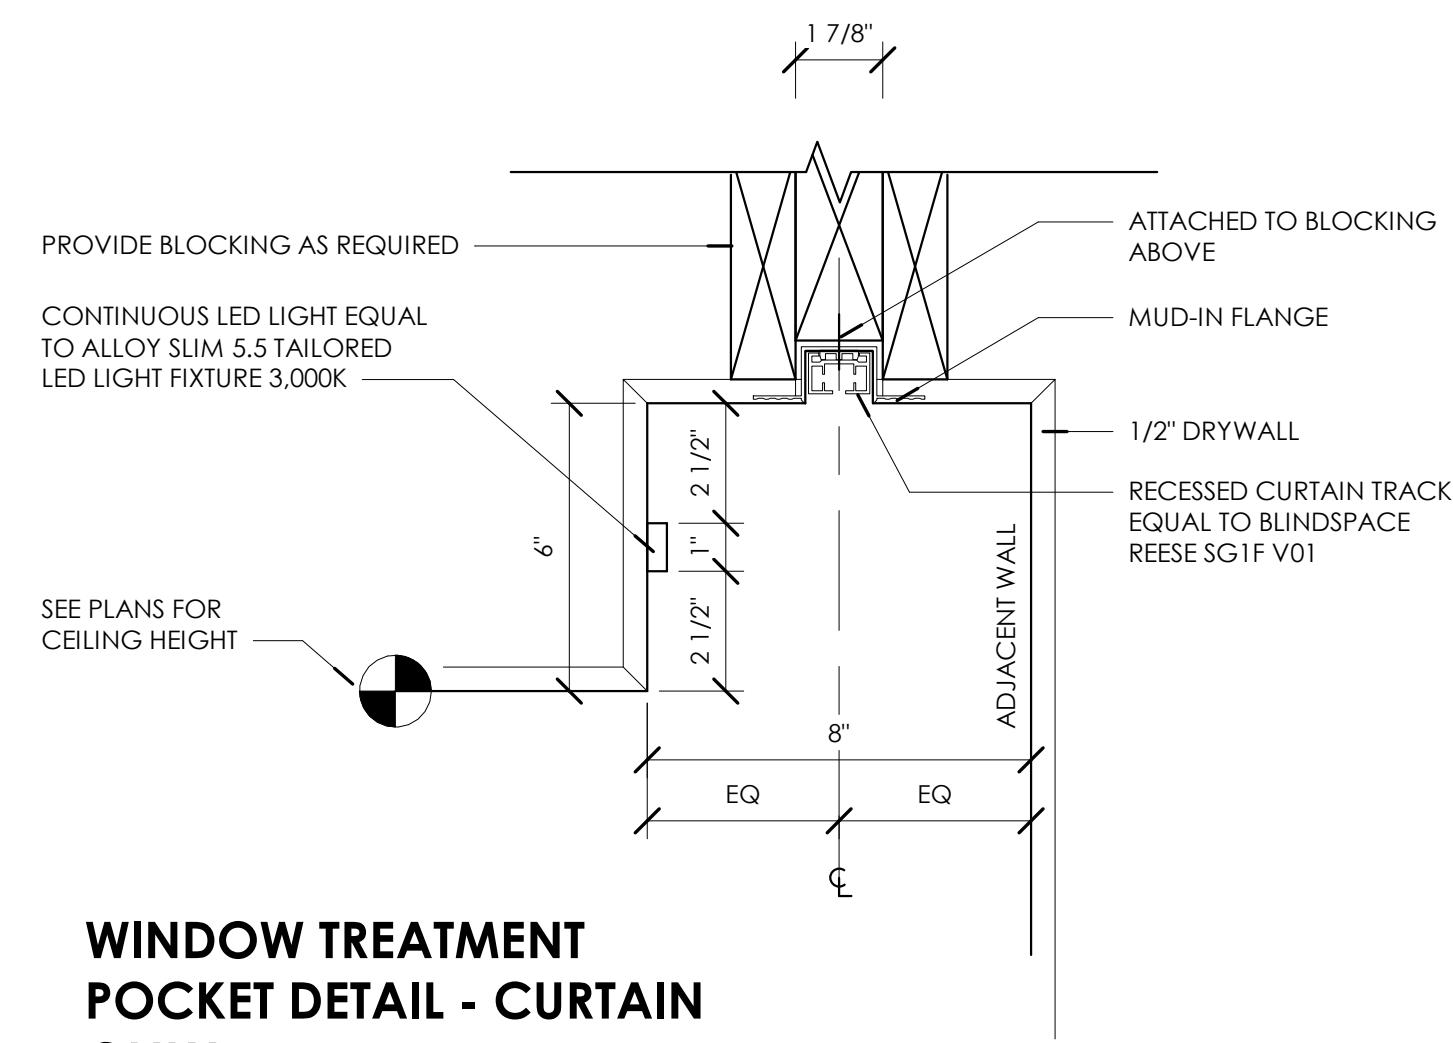

**WINDOW TREATMENT
POCKET DETAIL - CURTAIN
ONLY**
3" = 1'-0"

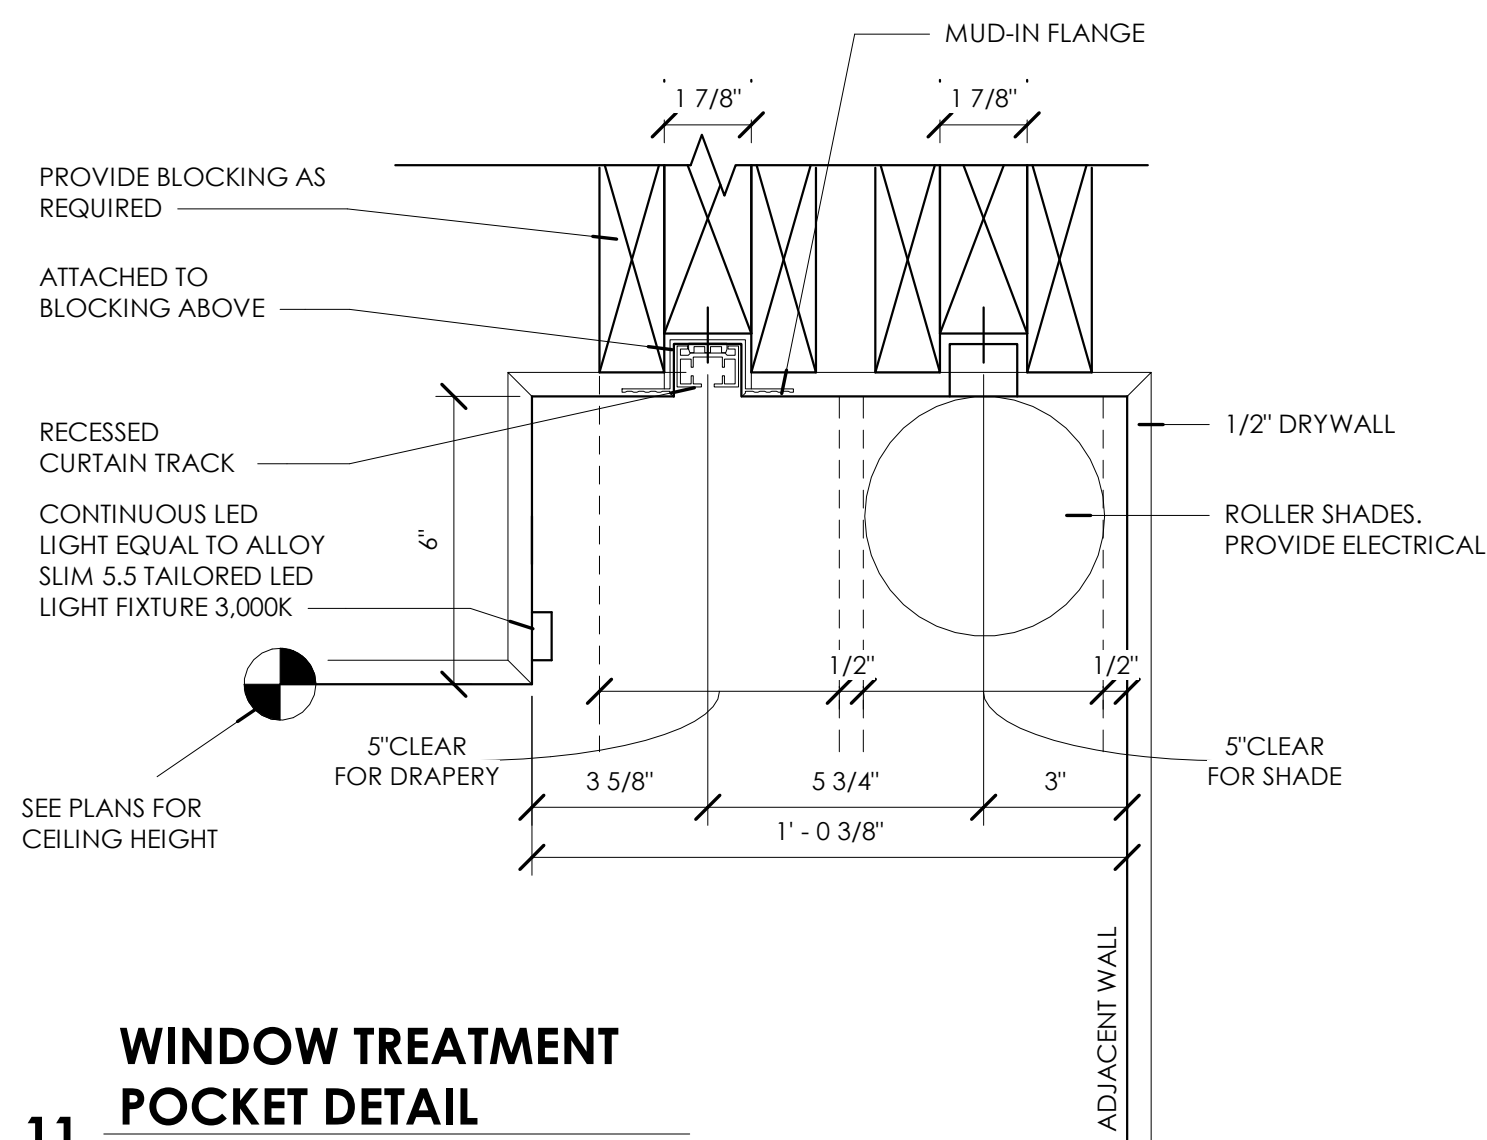


**WINDOW TREATMENT
POCKET DETAIL**
3" = 1'-0"

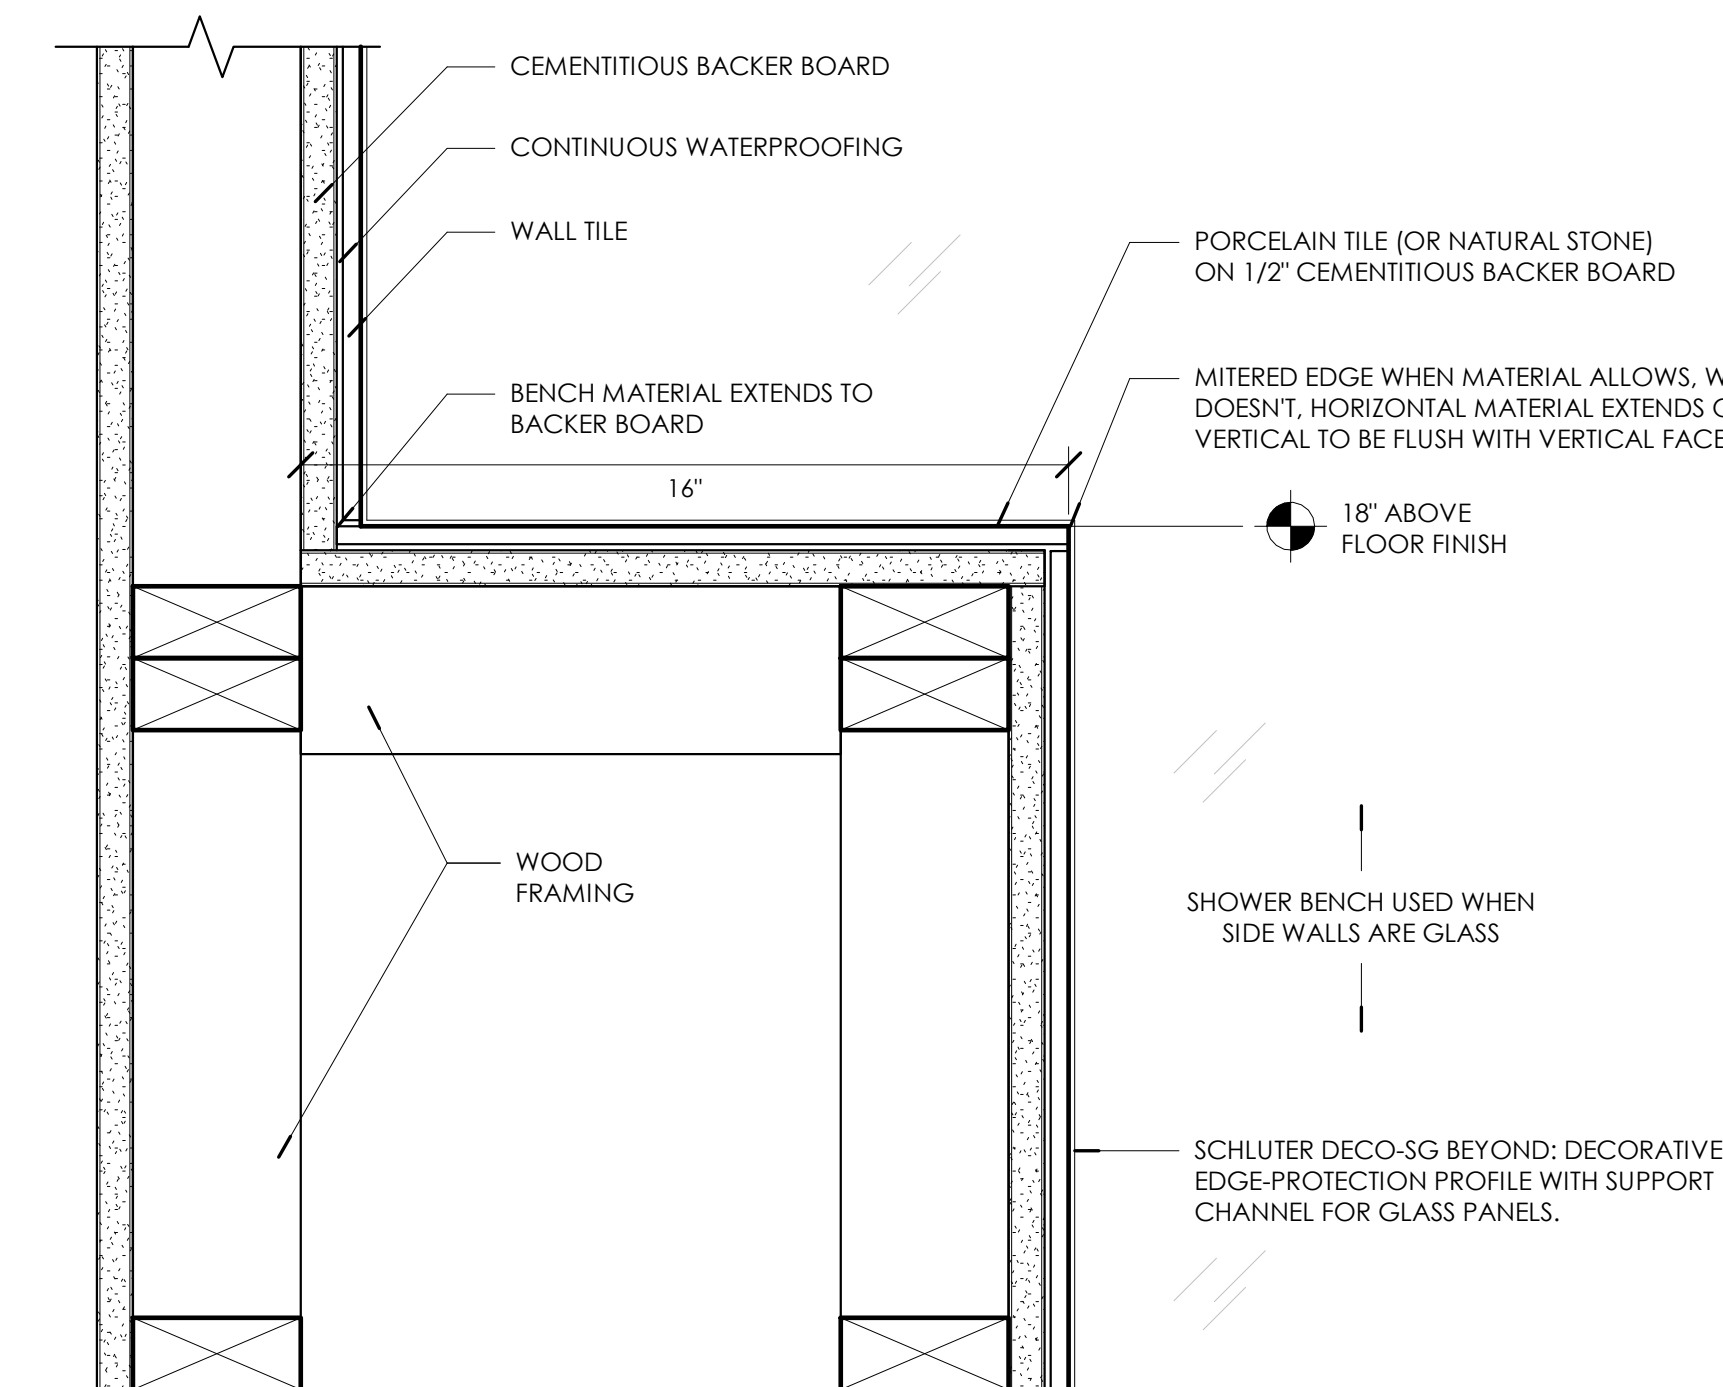


SHOWER BENCH
3" = 1'-0"

3 TRIM DETAILS
3" = 1'-0"

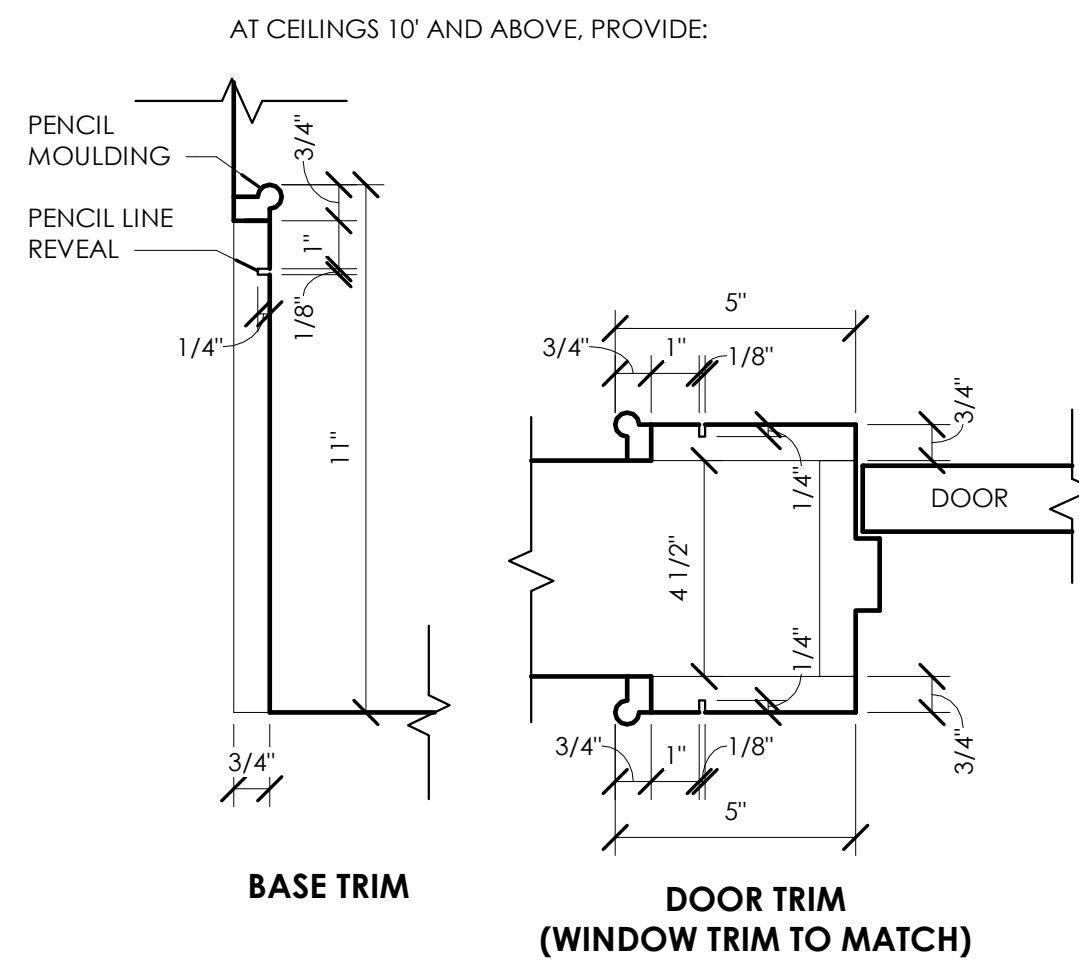


6 PAINT DETAILS
3" = 1'-0"

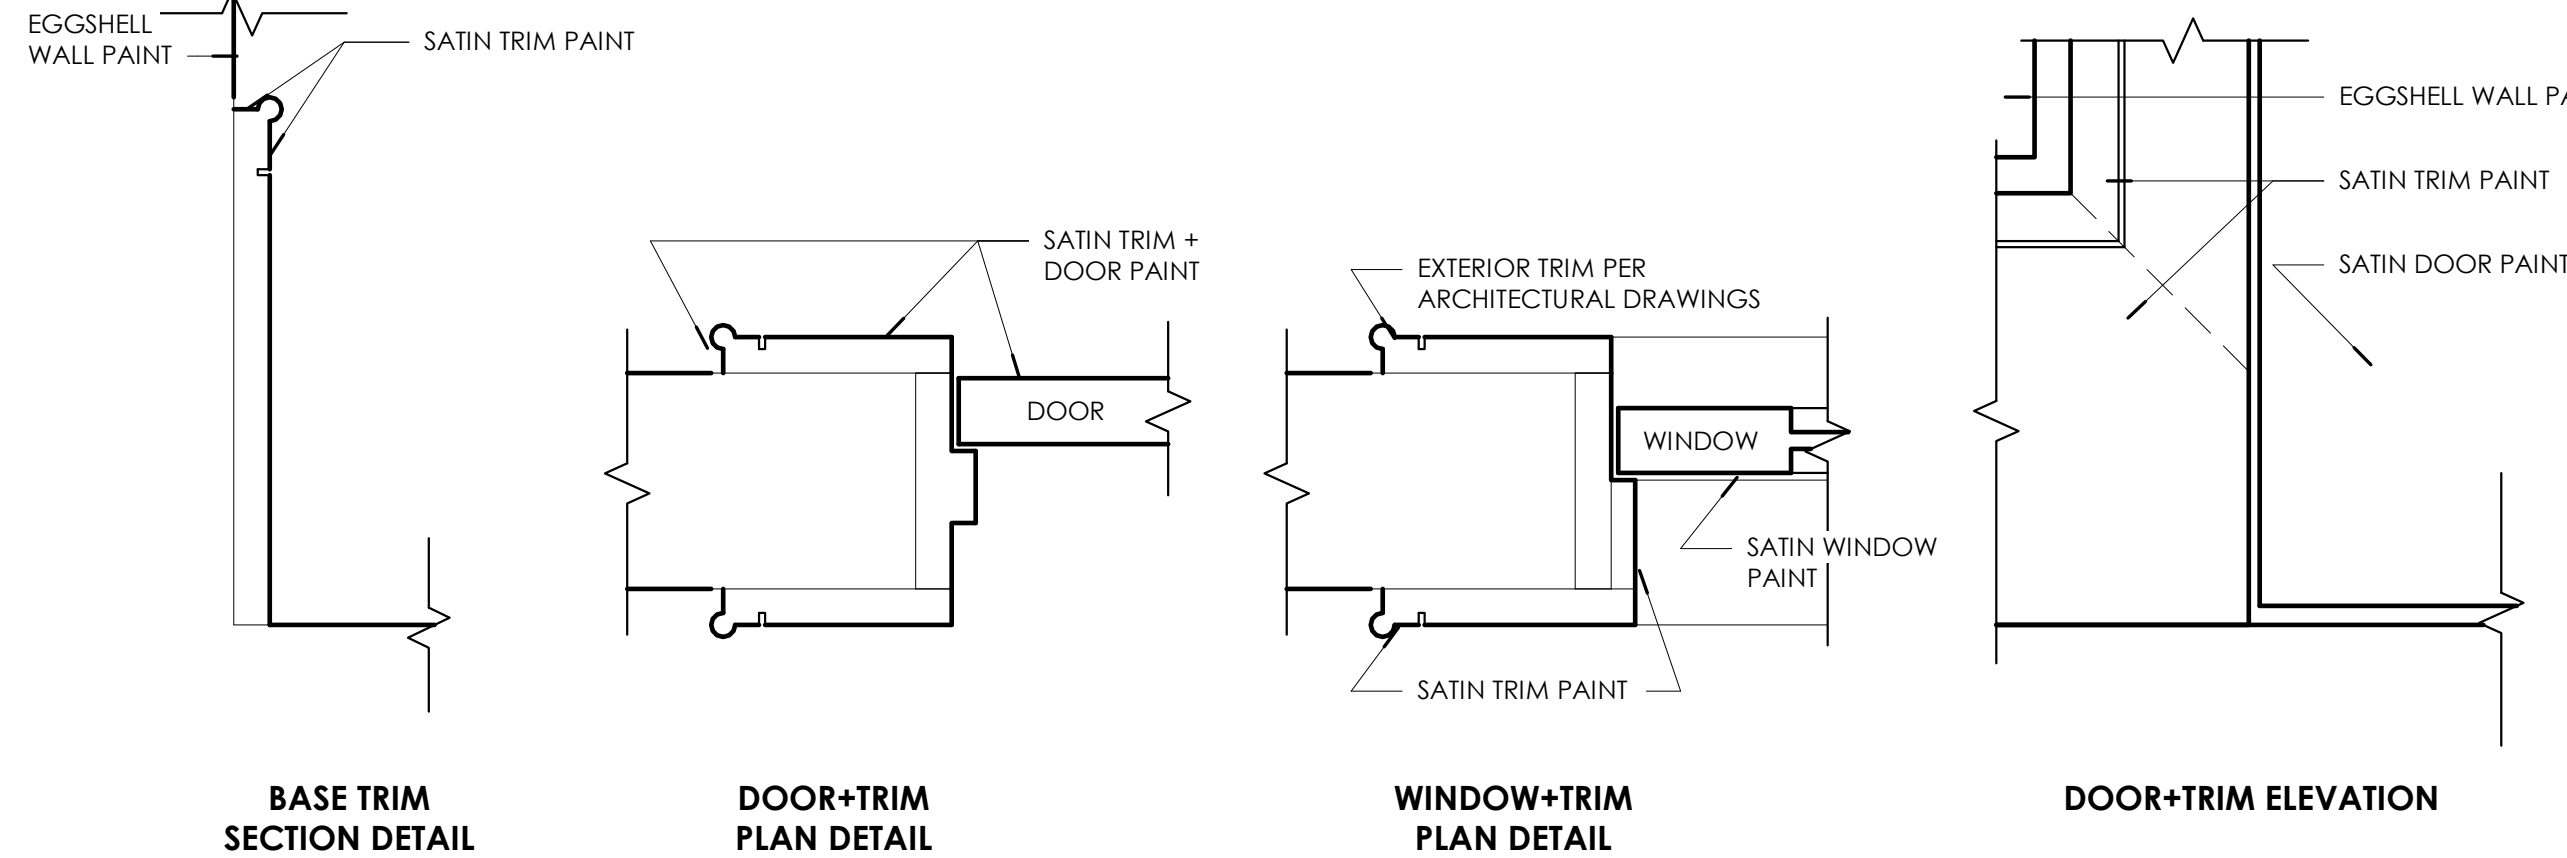


DOOR HARDWARE

1. EXTERIOR DOOR HARDWARE TO BE EQUAL TO ROCKY MOUNTAIN HARDWARE FLUTE ENTRY SET IN WHITE BRONZE DARK.
2. INTERIOR DOOR HARDWARE TO BE EQUAL TO ROCKY MOUNTAIN HARDWARE CROSS LEVER IN SILICON BRONZE DARK LUSTER.
3. CONTRACTOR SHALL COORDINATE ALL LOCK AND LATCH SETS AND FINAL KEYING WITH OWNER.
4. ALL DOOR HARDWARE ON EXIT DOORS SHALL BE READILY OPERABLE FROM THE EGRESS SIDE WITHOUT THE USE OF A KEY, SPECIAL KNOWLEDGE, OR EFFORT.
5. DOOR STOPS EQUAL TO ROCKY MOUNTAIN HARDWARE TALL FLOOR DOOR STOP 2.5" X 3" IN SILICON BRONZE DARK LUSTER.

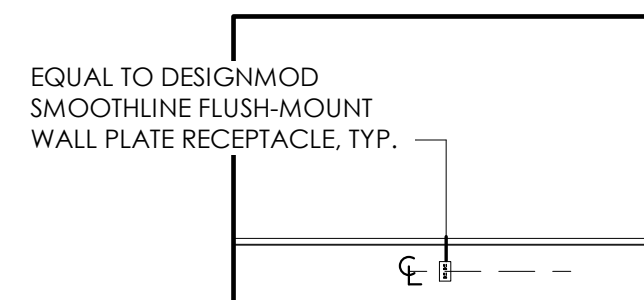

**1 FLUSHMOUNT RECEPTICAL
IN BASEBOARD**
3/8" = 1'-0"

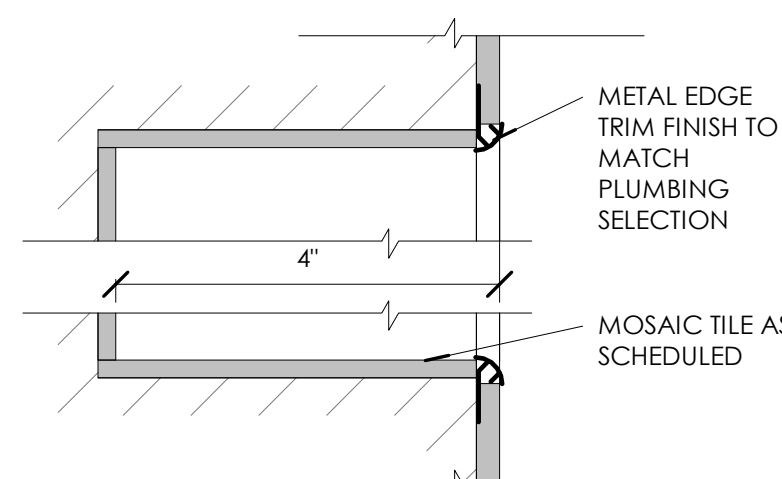


7 NICHE DETAIL
6" = 1'-0"



NOTE: ALL DOORS ON FIRST FLOOR TO BE EQUAL TO WHITE OAK AND STAINED EQUAL TO SW 3540 MOUNTAIN ASH. PROVIDE SAMPLE FOR APPROVAL. ALL DOORS ON SECOND FLOOR TO BE PAINTED BENJAMIN MOORE, OC-45, SWISS COFFEE.

9 STANDARD INTERIOR DOOR
3/8" = 1'-0"

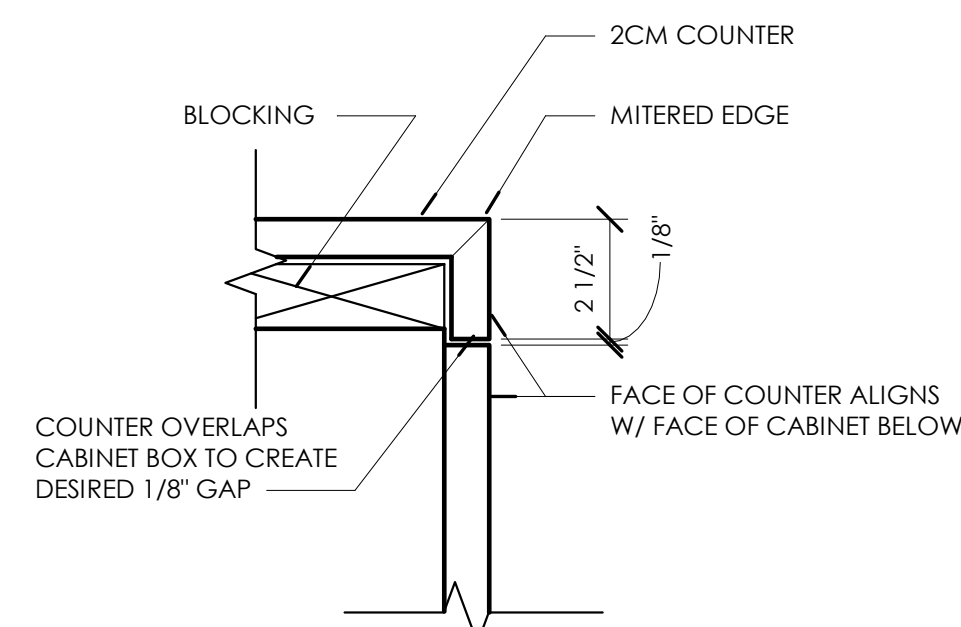

5 COUNTERTOP EDGE DETAIL
3" = 1'-0"

13 paneled opening detail
3/4" = 1'-0"



500 Madison unit 107,
Nashville, Tennessee 37208
w: murphymaudeinteriors.com
p: (901) 848-6402
copyright 2021

CLIENT
MR. AND MRS. CLIENT

PROJECT LOCATION
94 CUMBERLAND,
MEMPHIS, TN

PROJECT NAME
PERSONAL RESIDENCE

DATE ISSUED
DRAWING SCALE
8/14/2023
As Indicated

DRAWING TITLE
DIAGRAMS AND DETAILS

REVISIONS:
NUMBER DATE DESCRIPTION

SUPPLEMENTAL INTERIOR DESIGN
DOCUMENT
ID602